



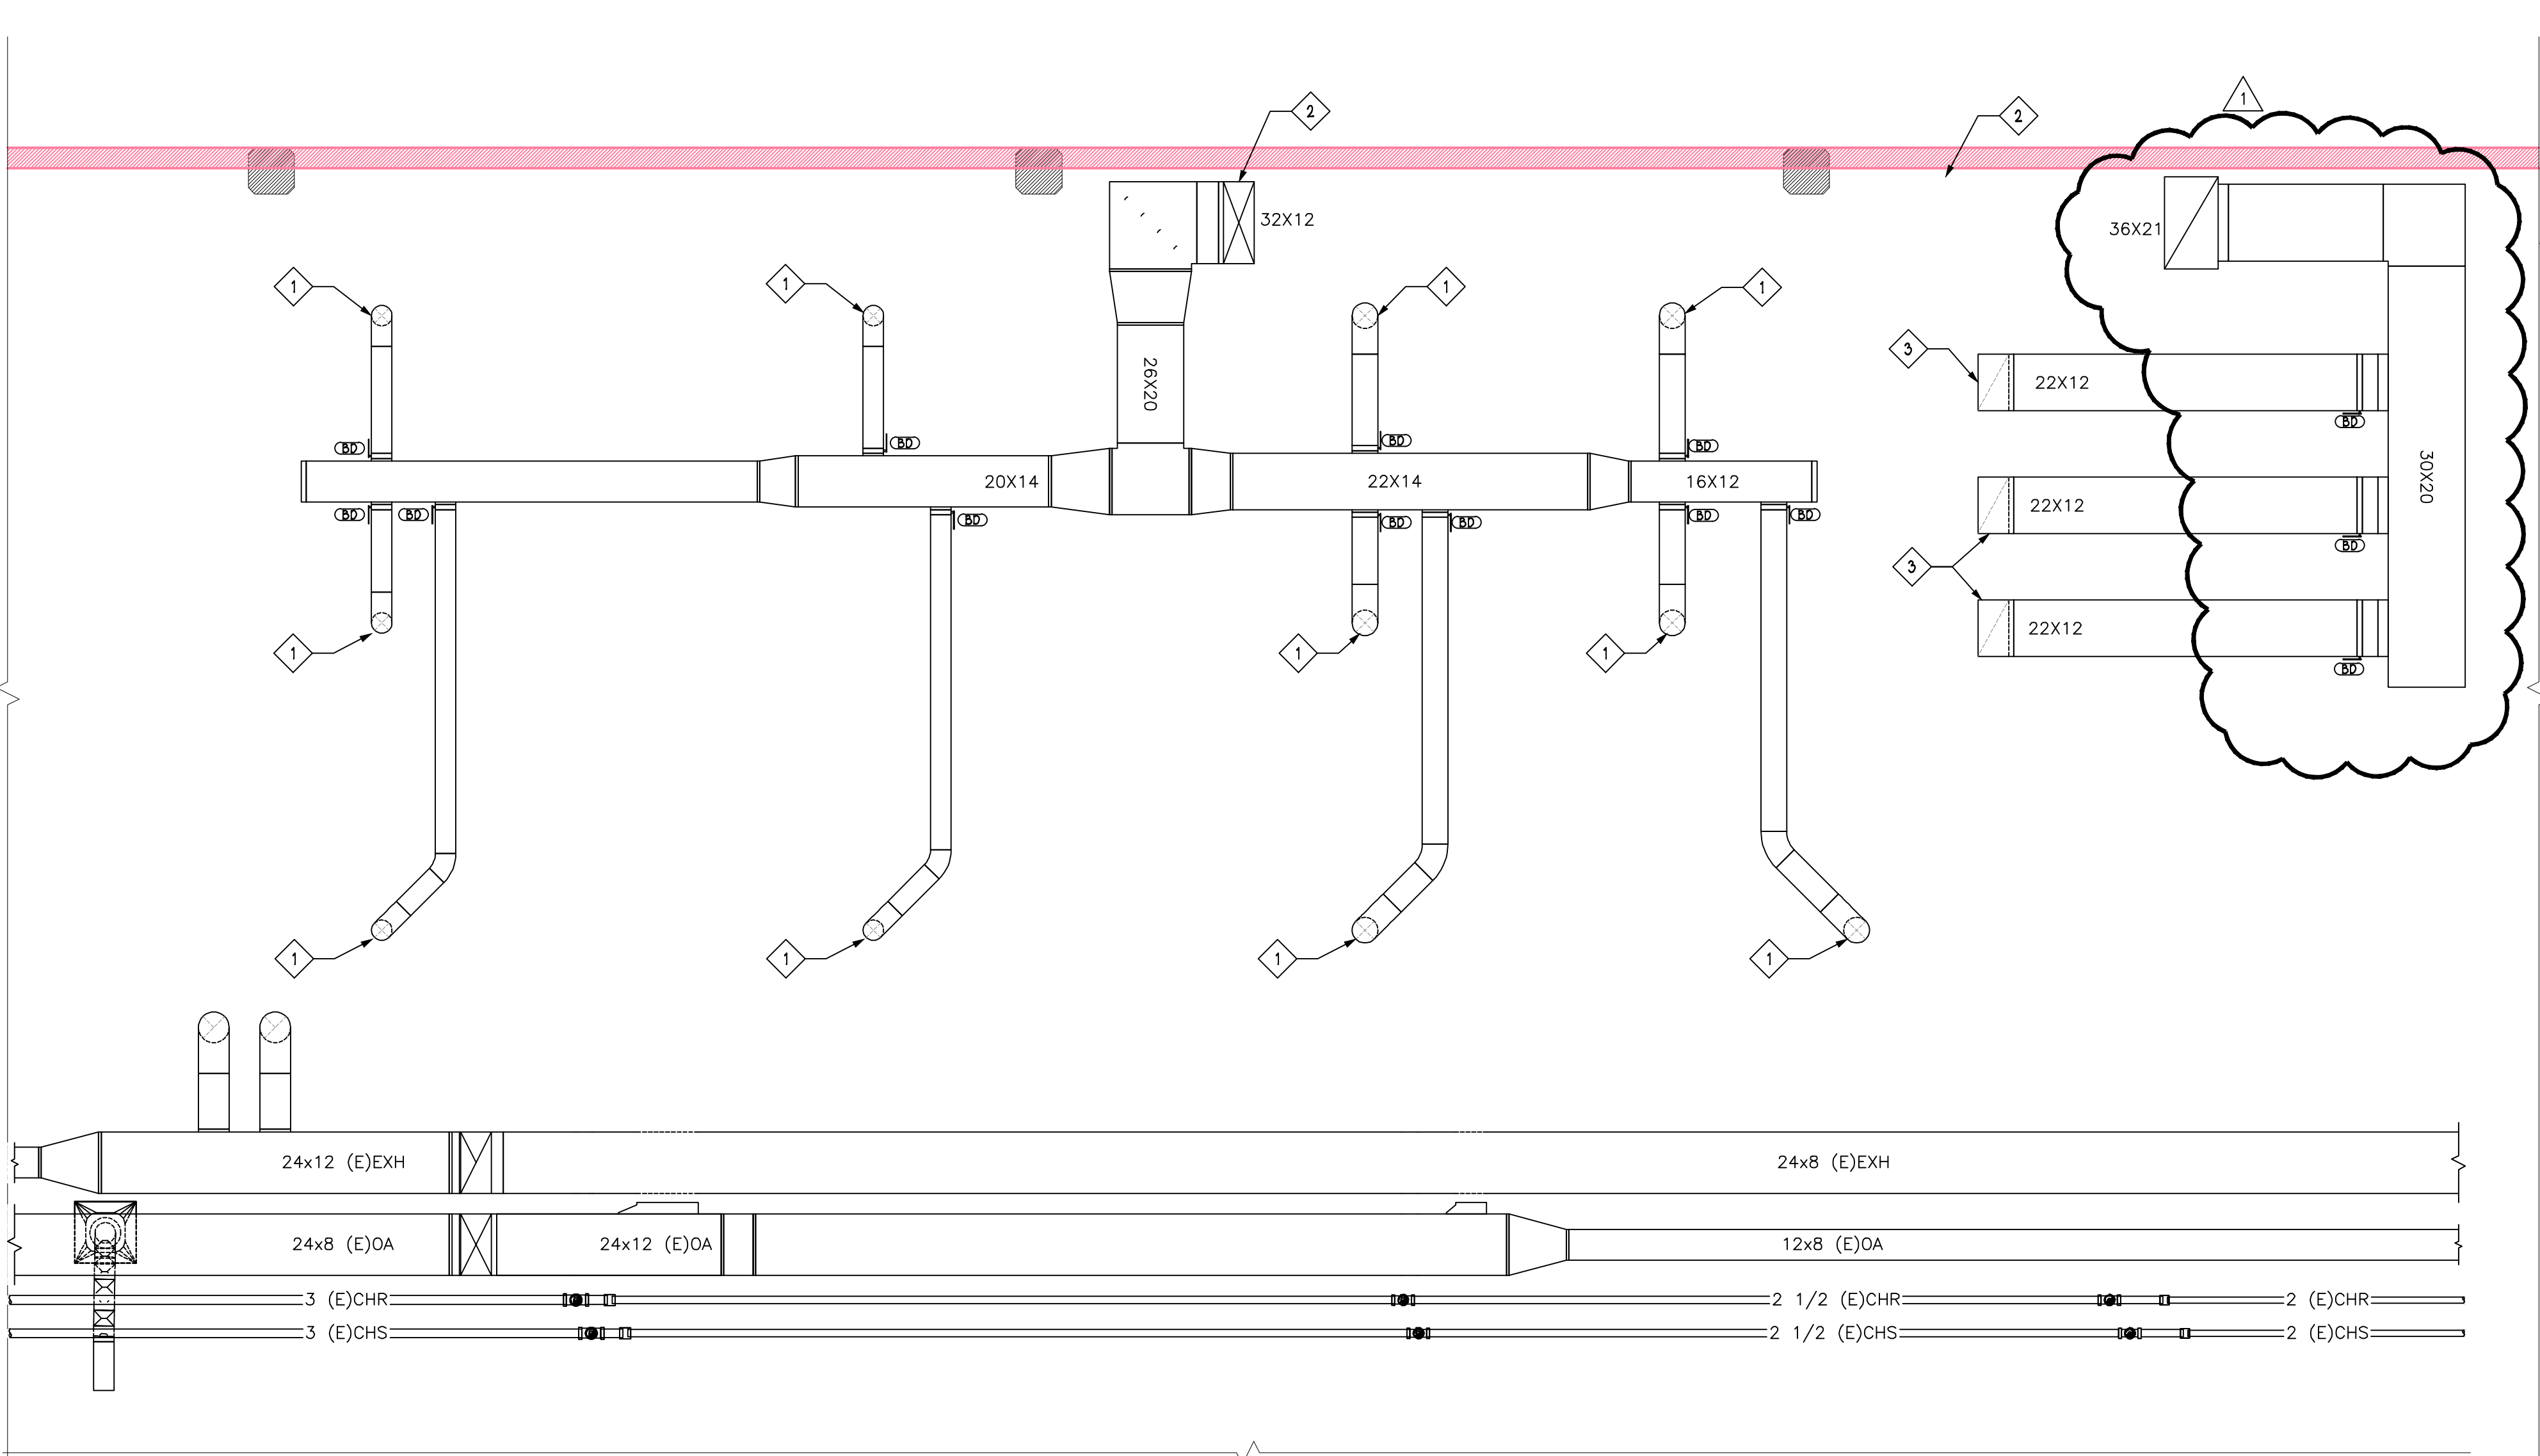

MECH MEZZANINE RENOVATION PLAN

1/4" = 1'-0"

SHEET KEYED NOTES	
1	ROUTE DUCTWORK DOWN THROUGH EXISTING CONCRETE PLANK. COORDINATE HOLES WITH STRUCTURAL STRANDS. SEAL SPACE BETWEEN DUCT AND HOLE EDGE WITH FOOD SAFE CAULK.
2	ROUTE DUCTWORK UP THROUGH ROOF TO ROOF MOUNTED EQUIPMENT. REFER TO ROOF PLAN FOR CONTINUATION.
3	ROUTE DUCTWORK DOWN THROUGH EXISTING CONCRETE PLANK AND TERMINATE IN BELOW CEILING SPACE. COORDINATE HOLES WITH STRUCTURAL STRANDS. SEAL SPACE BETWEEN DUCT AND WHOLE EDGE WITH FOOD SAFE CAULK.

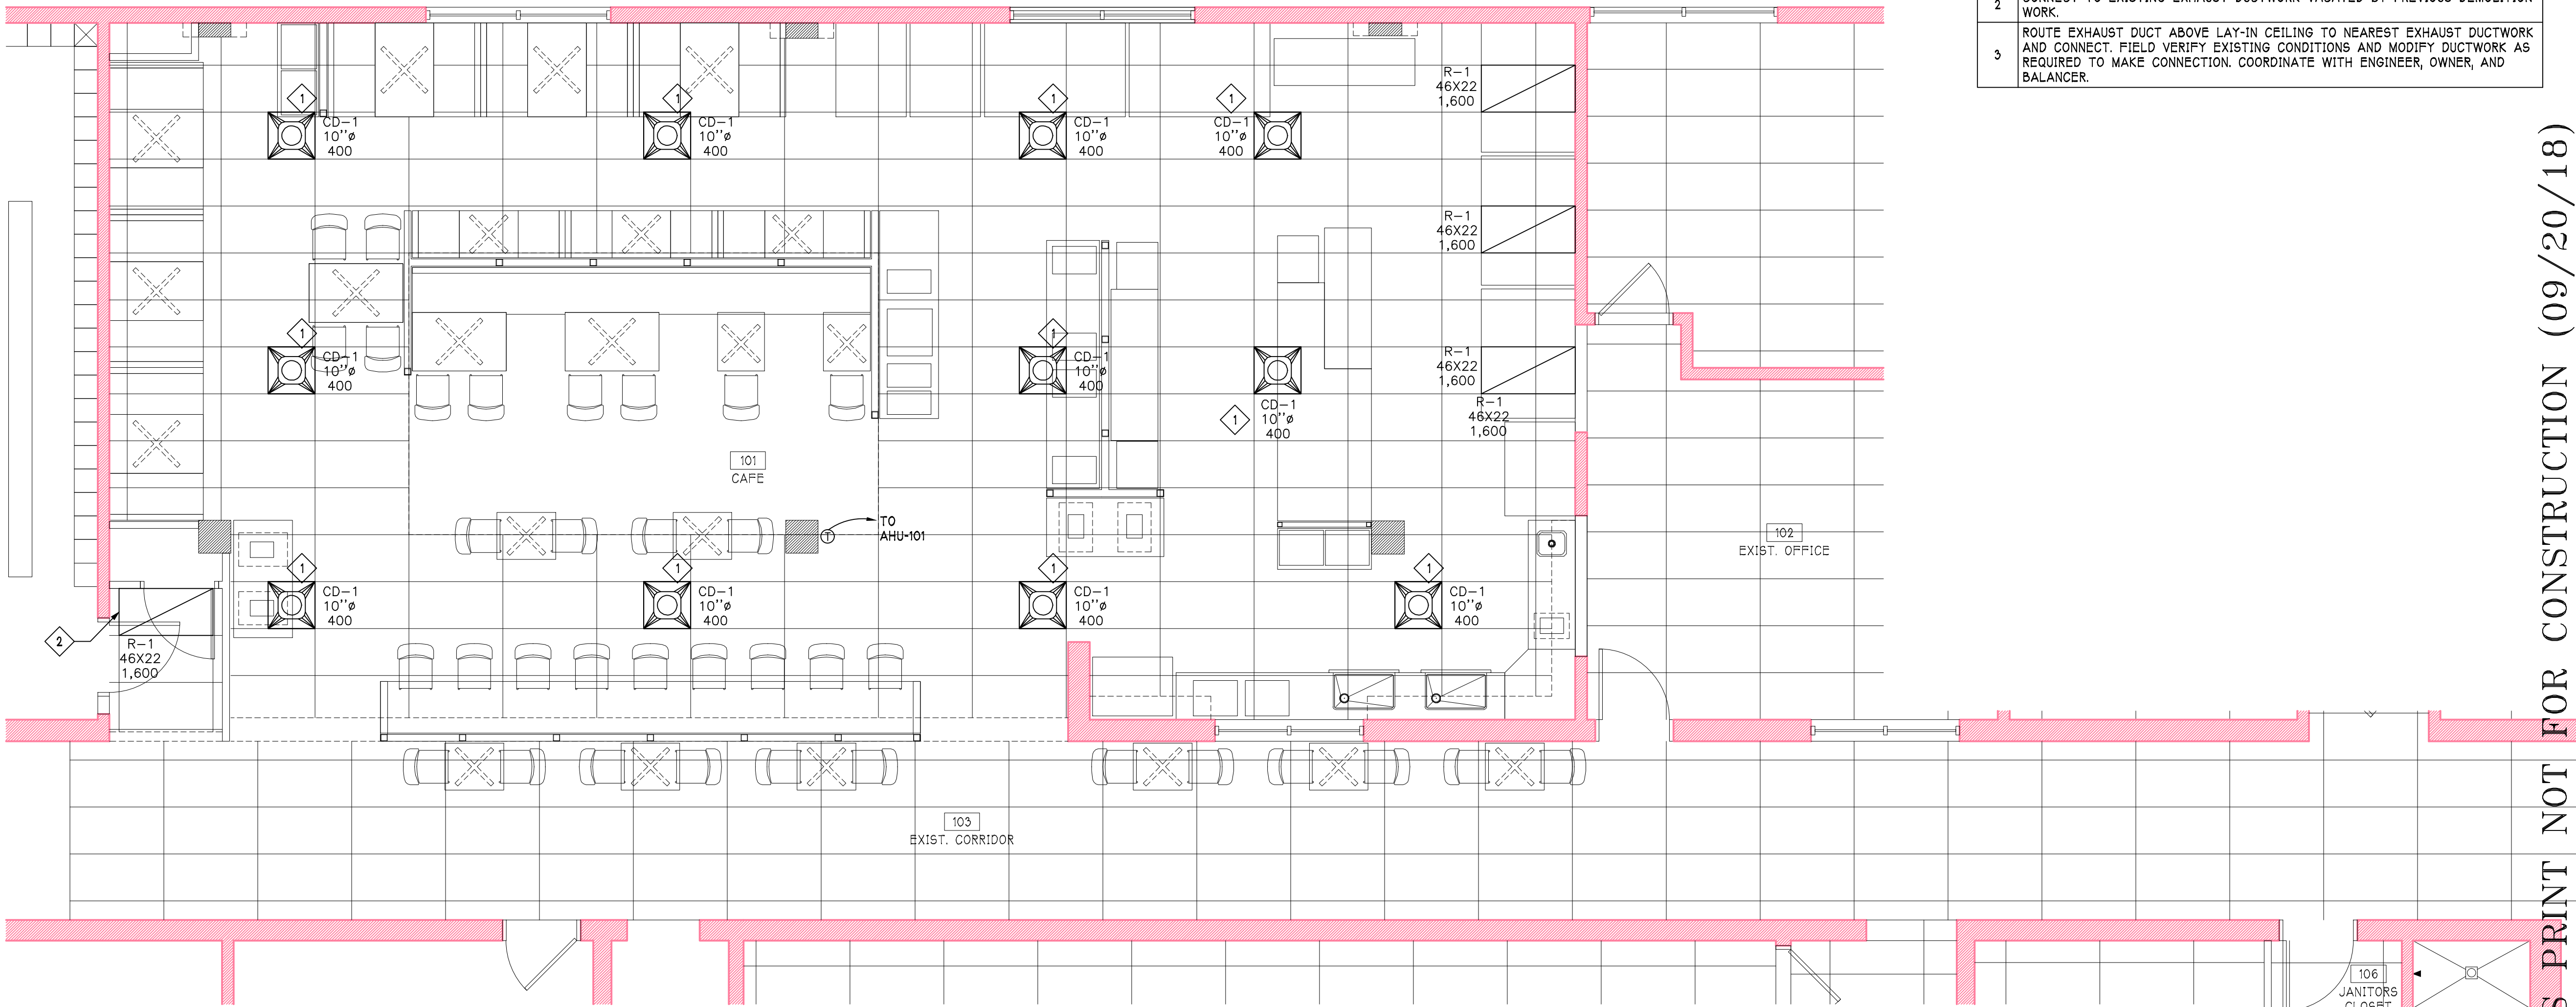

MECHANICAL RENOVATION PLAN

1/4" = 1'-0"

RENOVATION KEYED NOTES	
1	ROUTE BRANCH DUCTWORK UP THROUGH EXISTING CONCRETE PLANK. USE INSULATED FLEX DUCTWORK FROM DIFFUSER TO PLANK. REFER TO MEZZANINE PLAN FOR CONTINUATION.
2	CONNECT TO EXISTING EXHAUST DUCTWORK VACATED BY PREVIOUS DEMOLITION WORK.
3	ROUTE EXHAUST DUCT ABOVE LAY-IN CEILING TO NEAREST EXHAUST DUCTWORK AND CONNECT. FIELD VERIFY EXISTING CONDITIONS AND MODIFY DUCTWORK AS REQUIRED TO MAKE CONNECTION. COORDINATE WITH ENGINEER, OWNER, AND BALANCER.

PROGRESS PRINT NOT FOR CONSTRUCTION (09/20/18)

Job No: 1730
Drawn: MAB
Checked: SCP

Revisions:	
No: 1	Date: 02/20/19
Revisions Per Addendum #2	
No:	Date:
No:	Date:
No:	Date:
No:	Date:
No:	Date:
No:	Date:
No:	Date:



NEWCOMER ASSOCIATES

architecture + engineering

1105 Shiller Avenue Chambersburg, PA 17201 Tel: 717 263-0001 Fax: 717 263-7388 www.newcomerassociates.com

Martin's Famous Pastry Shoppe
Transportation Cafe

Chambersburg, Pennsylvania 17202

© 2017
Newcomer Associates, Inc.

Drawing Title:
MECHANICAL
RENOVATION
PLAN

Sheet No.
M101

Date: MM/DD/YY

Job No: 1730
Drawn: MAB
Checked: SCP

SHEET KEYED NOTES

- | | |
|---|--|
| 1 | MAKE FINAL CONNECTION TO MECHANICAL UNIT. |
| 2 | INCLUDE GAS REGULATOR TO STEP PRESSURE DOWN FROM 5 PSI TO 10" OF WC. |
| 3 | CONNECT NEW PIPING TO EXISTING. FIELD VERIFY EXISTING CONDITIONS PRIOR TO STARTING WORK. |
| 4 | PROVIDE HEAT TRACE AND INSULATION FOR CONDENSATE PIPING. COORDINATE WORK WITH ELECTRICAL TRADES. |

Revisions:

No: 1	Date: 02/20/2019
-------	------------------

Revised Per Addendum #2

No:	Date:
-----	-------

No:	Date:
-----	-------

No:	Date:
-----	-------

No:	Date:
-----	-------

No:	Date:
-----	-------

NEWCOMER ASSOCIATES
architecture + engineering

105 Sheller Avenue Chambersburg, PA 17201 Tel: 717 263 0101 Fax: 717 263 7380 www.newcomerassociates.com

Martin's Famous Pastry Shoppe Transportation Cafe

Chambersburg, Pennsylvania 17202


© 2017
Newcomer Associates, Inc.

Drawing Title:
ROOF
MECHANICAL
PLAN

Sheet No.

M102


Date: MM/DD/YY

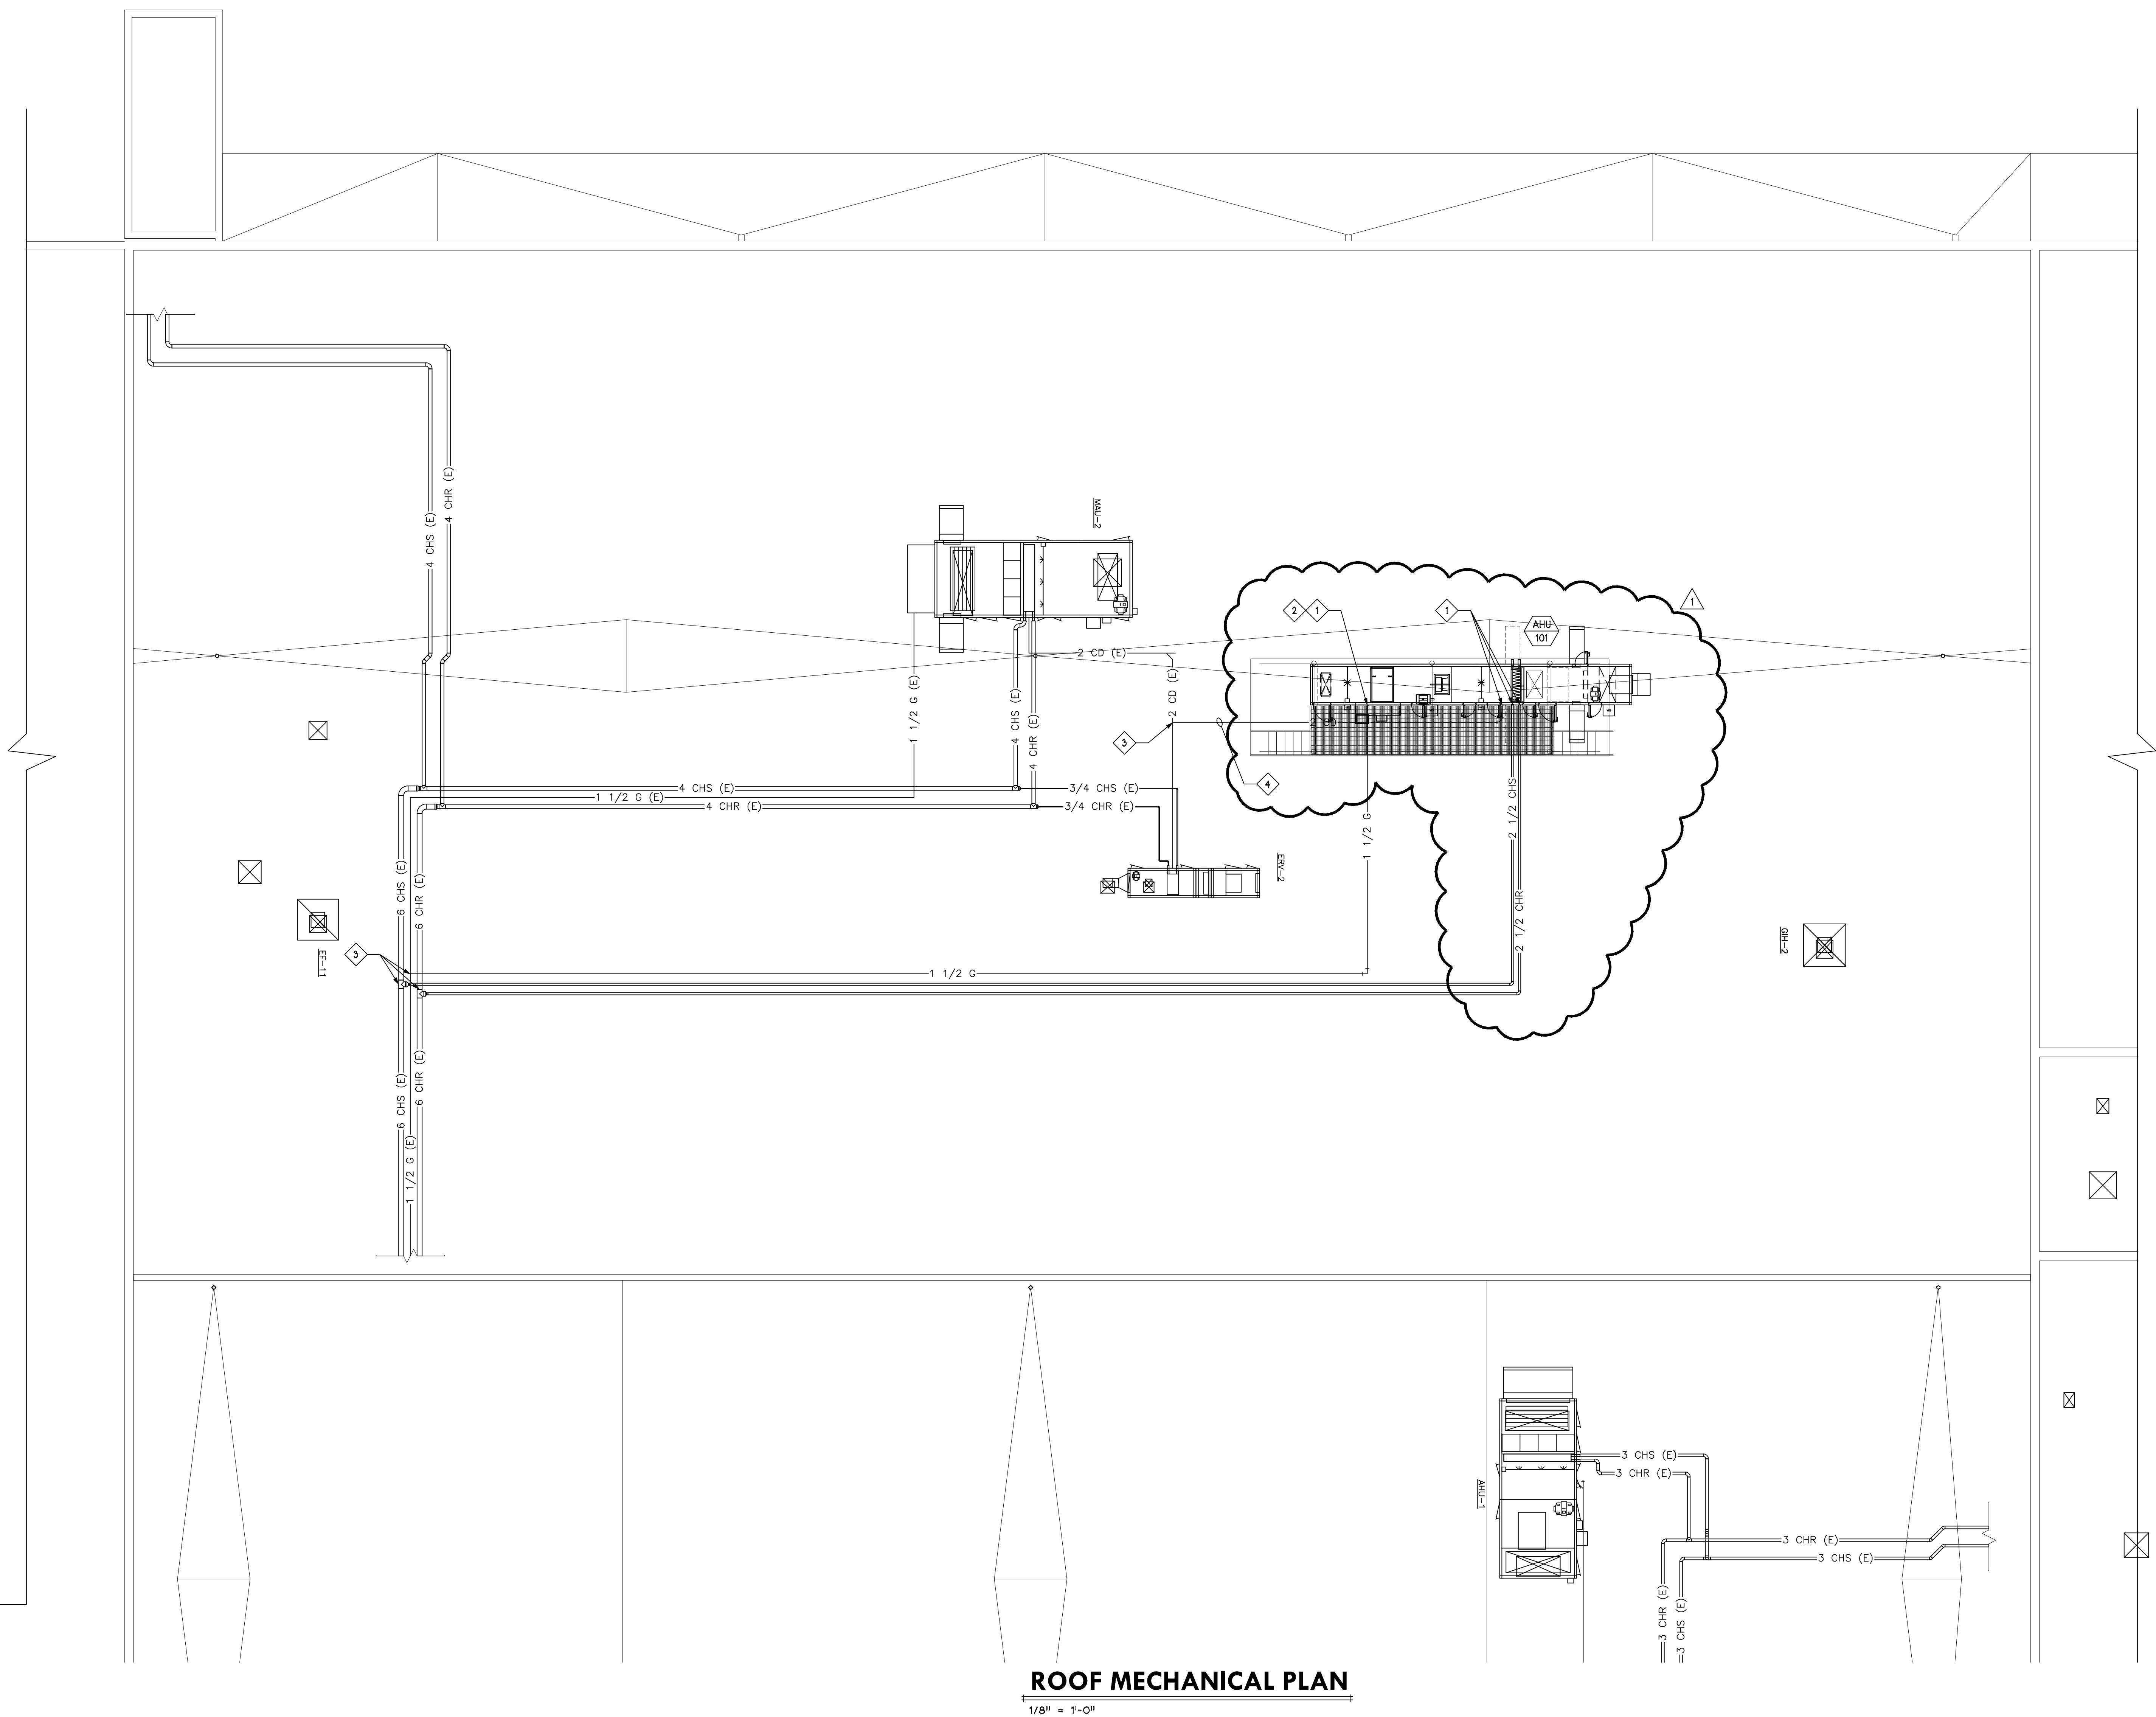

ROOF MECHANICAL PLAN


$$1/8^{II} = 1^I - O^{II}$$

PROGRESS PRINT NOT FOR CONSTRUCTION (09/20/18)

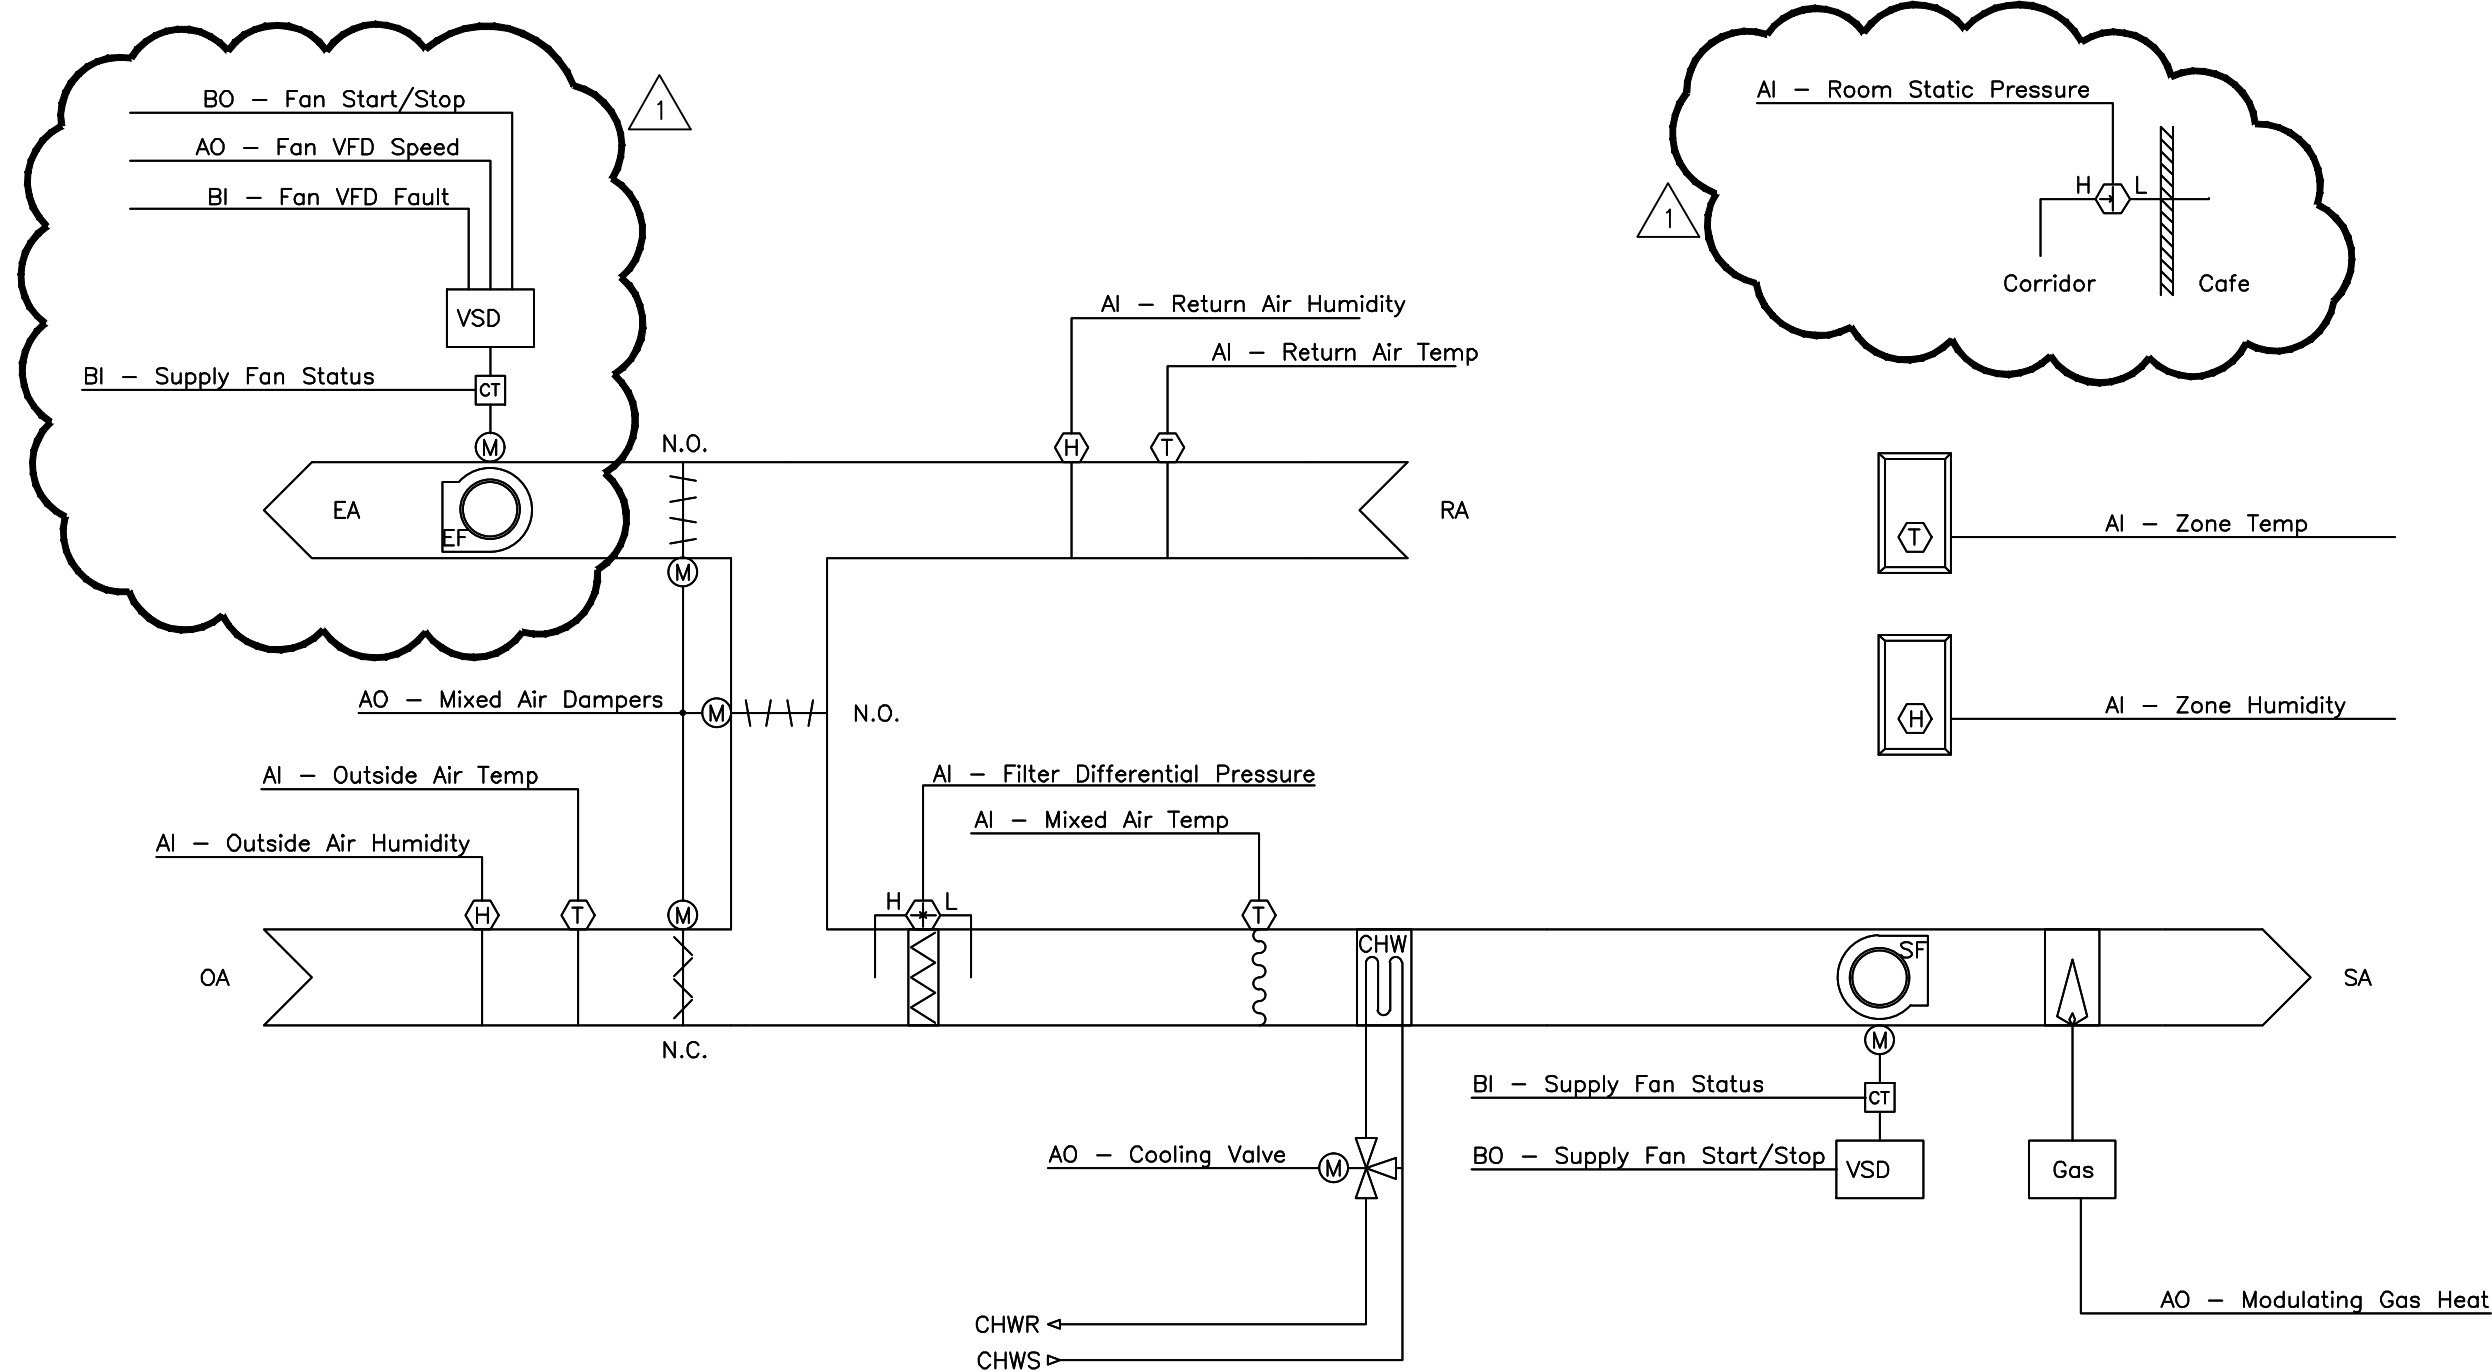


AHU-101 CONTROL SCHEMATIC

NOT TO SCALE

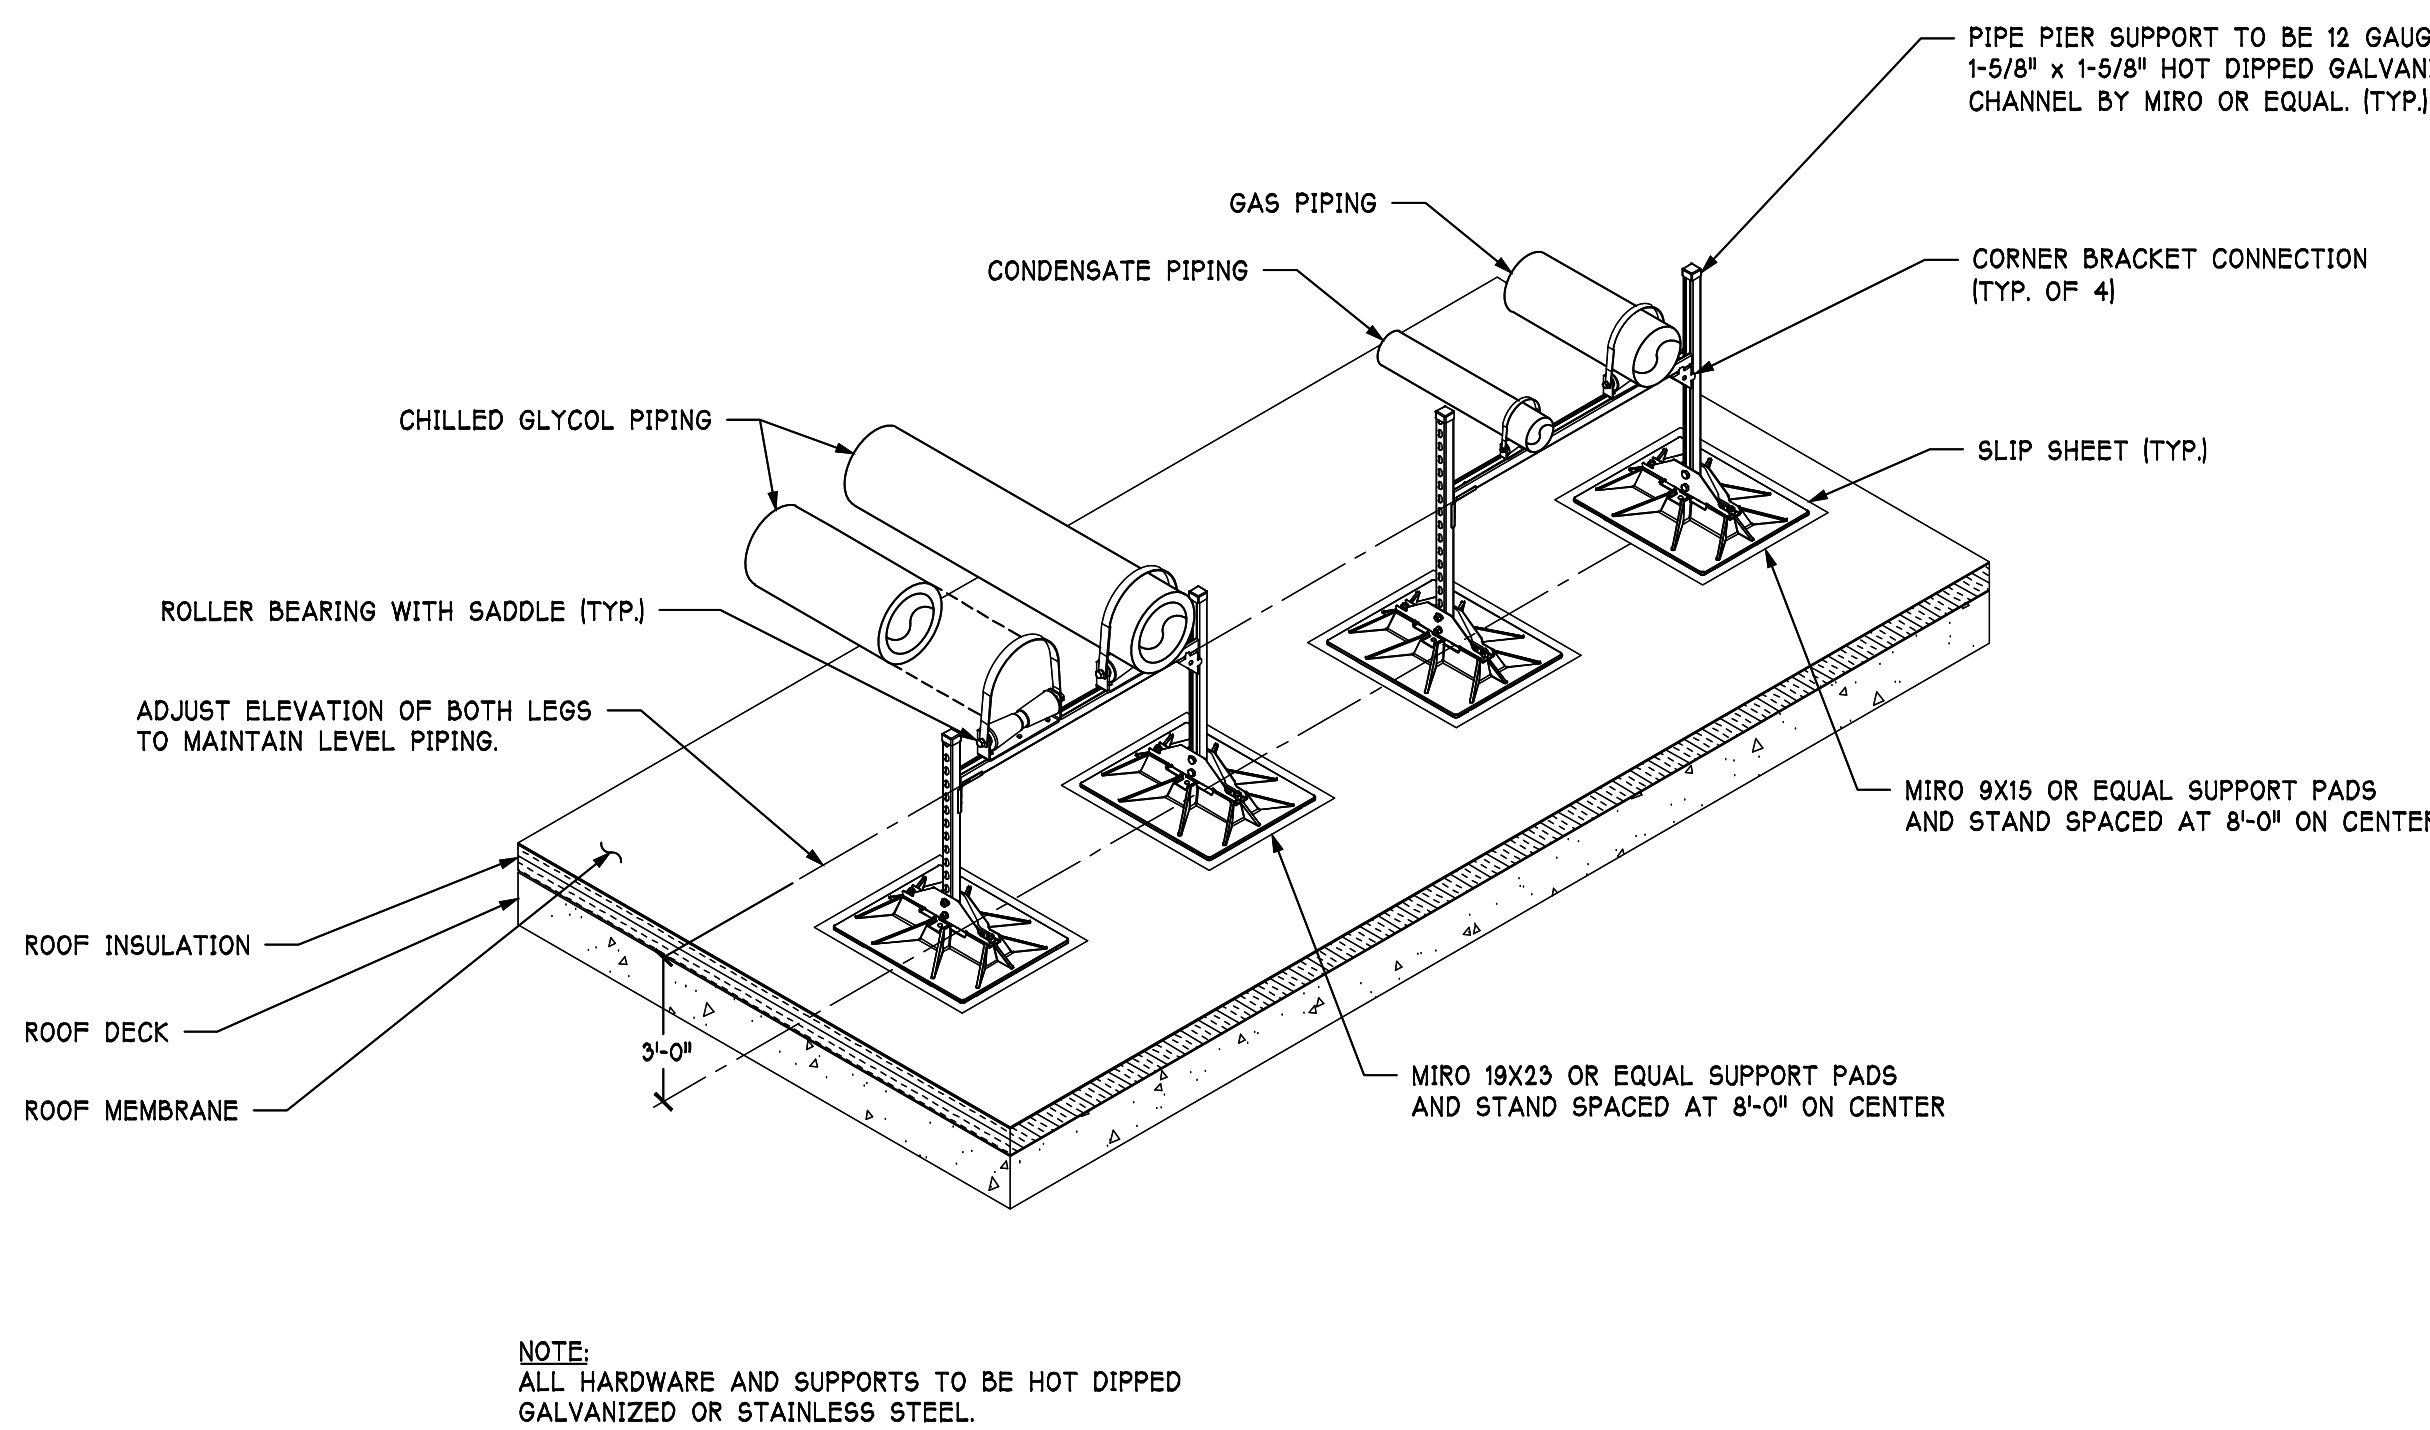

ROOF MOUNTED PIPING STAND DETAIL

NOT TO SCALE

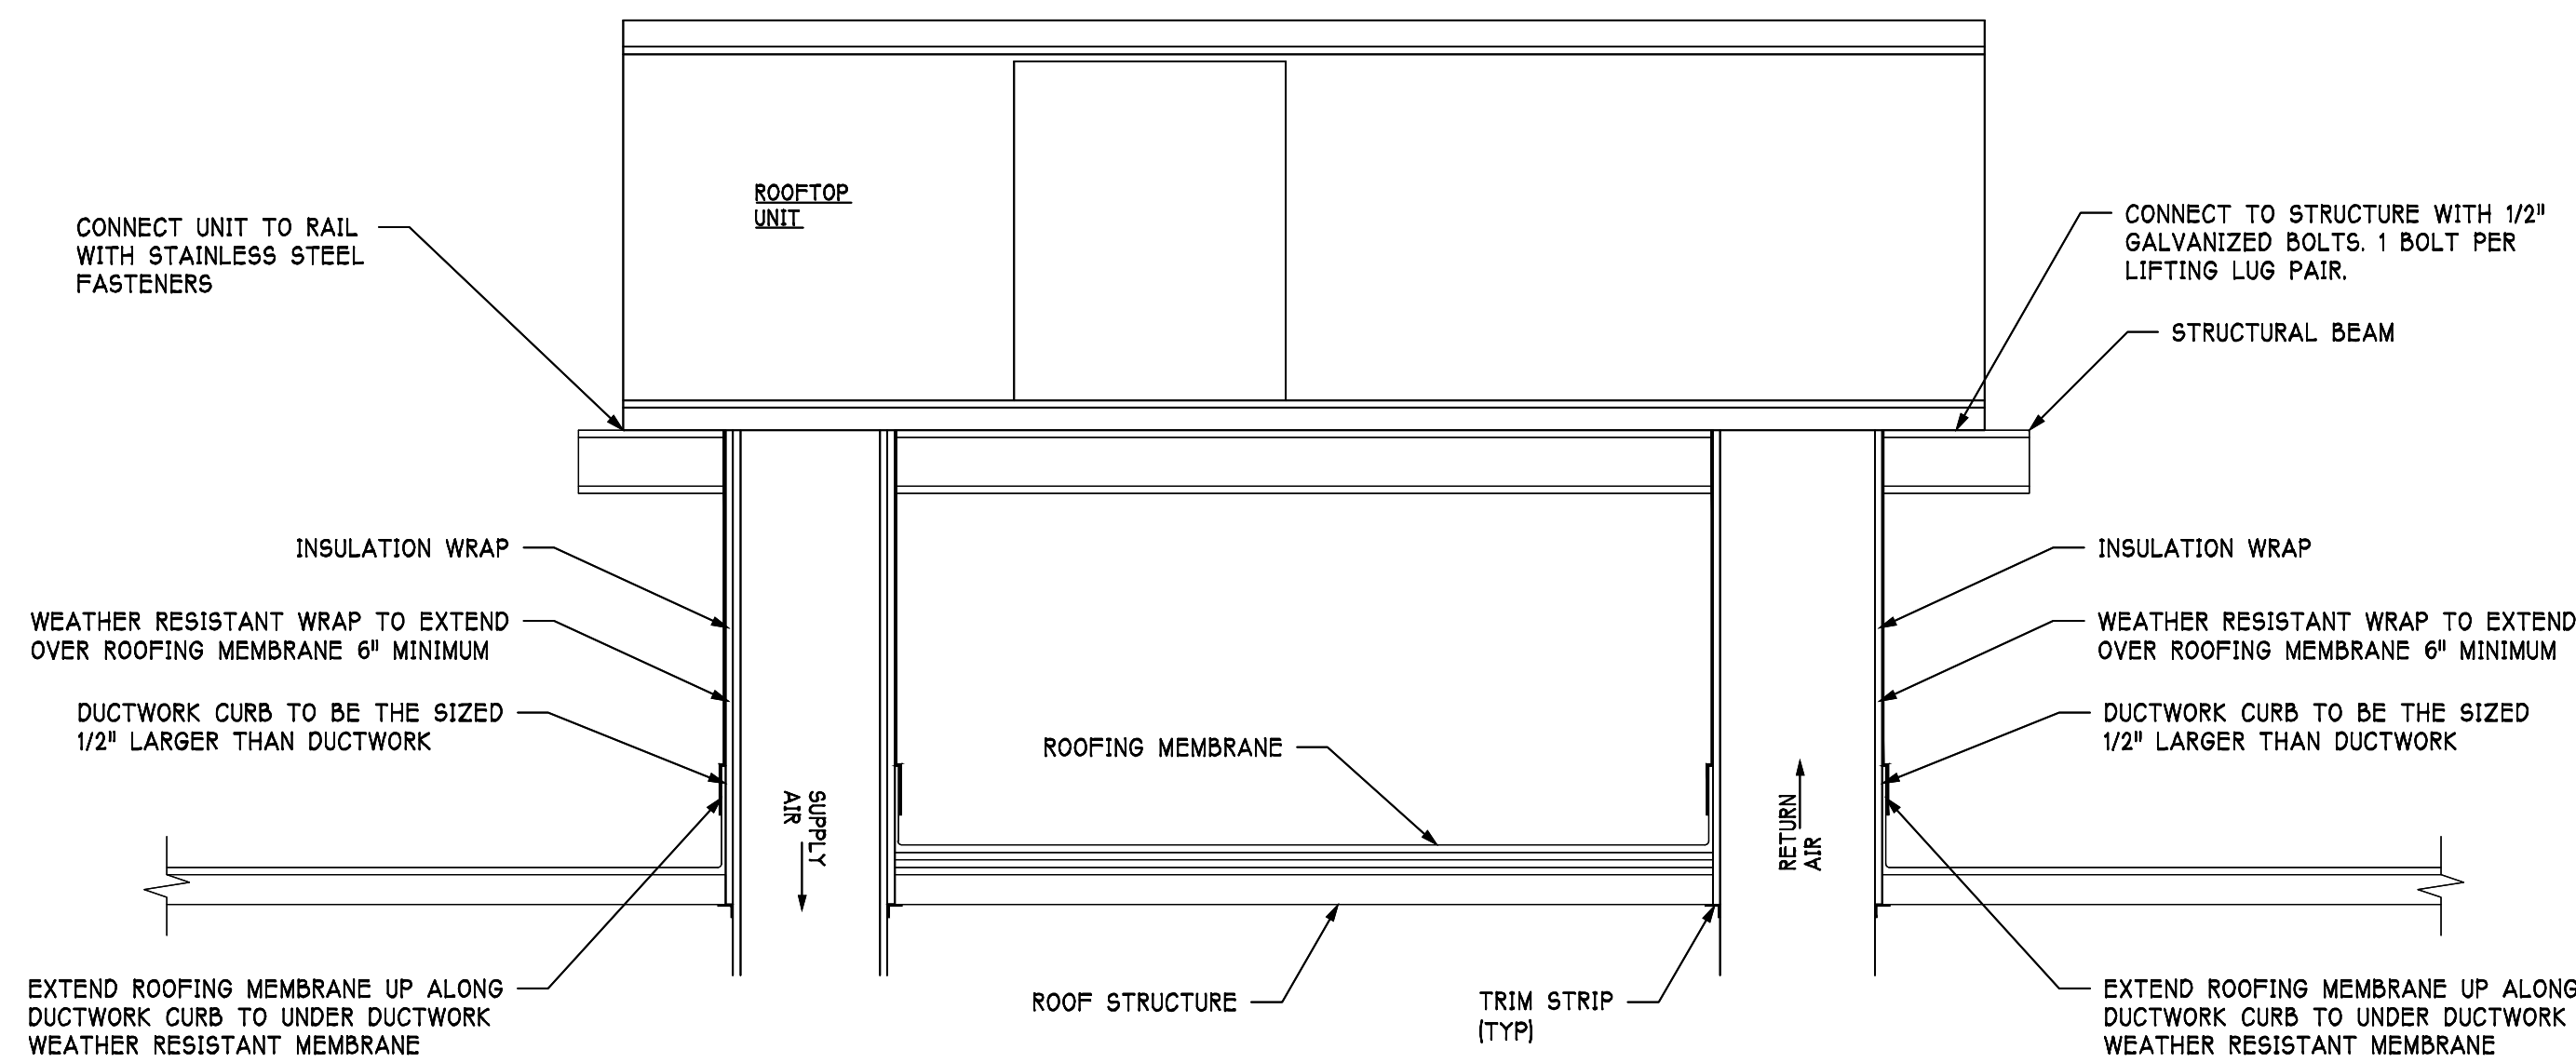


ROOFTOP EQUIPMENT MOUNTING AND DUCTWORK PENETRATION DETAIL

NOT TO SCALE

ROOFTOP AIR HANDLING UNIT (HYDRONIC COOL & GAS HEAT) SCHEDULE																									
TAG	FLOW RATE			SUPPLY	EXHAUST	HYDRONIC COOLING										GAS HEATING		SUPPLY FAN	EXHAUST FAN	ELECTRICAL	BASIS OF DESIGN			WEIGHT	NOTES
	SUPPLY	OA	EXHAUST	E.S.P.	E.S.P.	TOTAL	SENSIBLE	FLOW RATE	MAX WPD	AIR (DEG-F)				WATER (DEG-F)		INPUT	OUTPUT	MOTOR	MOTOR		VOLTAGE	MANUFACTURER	MODEL #	LBS	
	CFM	CFM	CFM	IN WG	IN WG	MBH	MBH	GPM	FEET	EAT DB	EAT WB	LAT DB	LAT WB	EWT	LWT	MBH	MBH	HP	HP						
AHU-101	4,400	825	4,400	1.7	0.8	173	128	37	2.6	76.0	64.0	51.4	51.3	35	45	250	200	7 1/2	2	480/3/60	YORK	SOLUTION XT	7,400	—	


NOTES:
1. CHILLED WATER IS 30% PROPYLENE GLYCOL.

GRILLES REGISTERS AND DIFFUSERS SCHEDULE						
TAG	DESCRIPTION	CONSTRUCTION			BASIS OF DESIGN	
		FINISH	MATERIAL	ACCESSORY	MANUFACTURER	MODEL NUMBER
CD-1	SQUARE PLAQUE DIFFUSER	WHITE	ALUMINUM	—	PRICE	ASP
R-1	PERFORATED DIFFUSER	WHITE	ALUMINUM	—	PRICE	APD

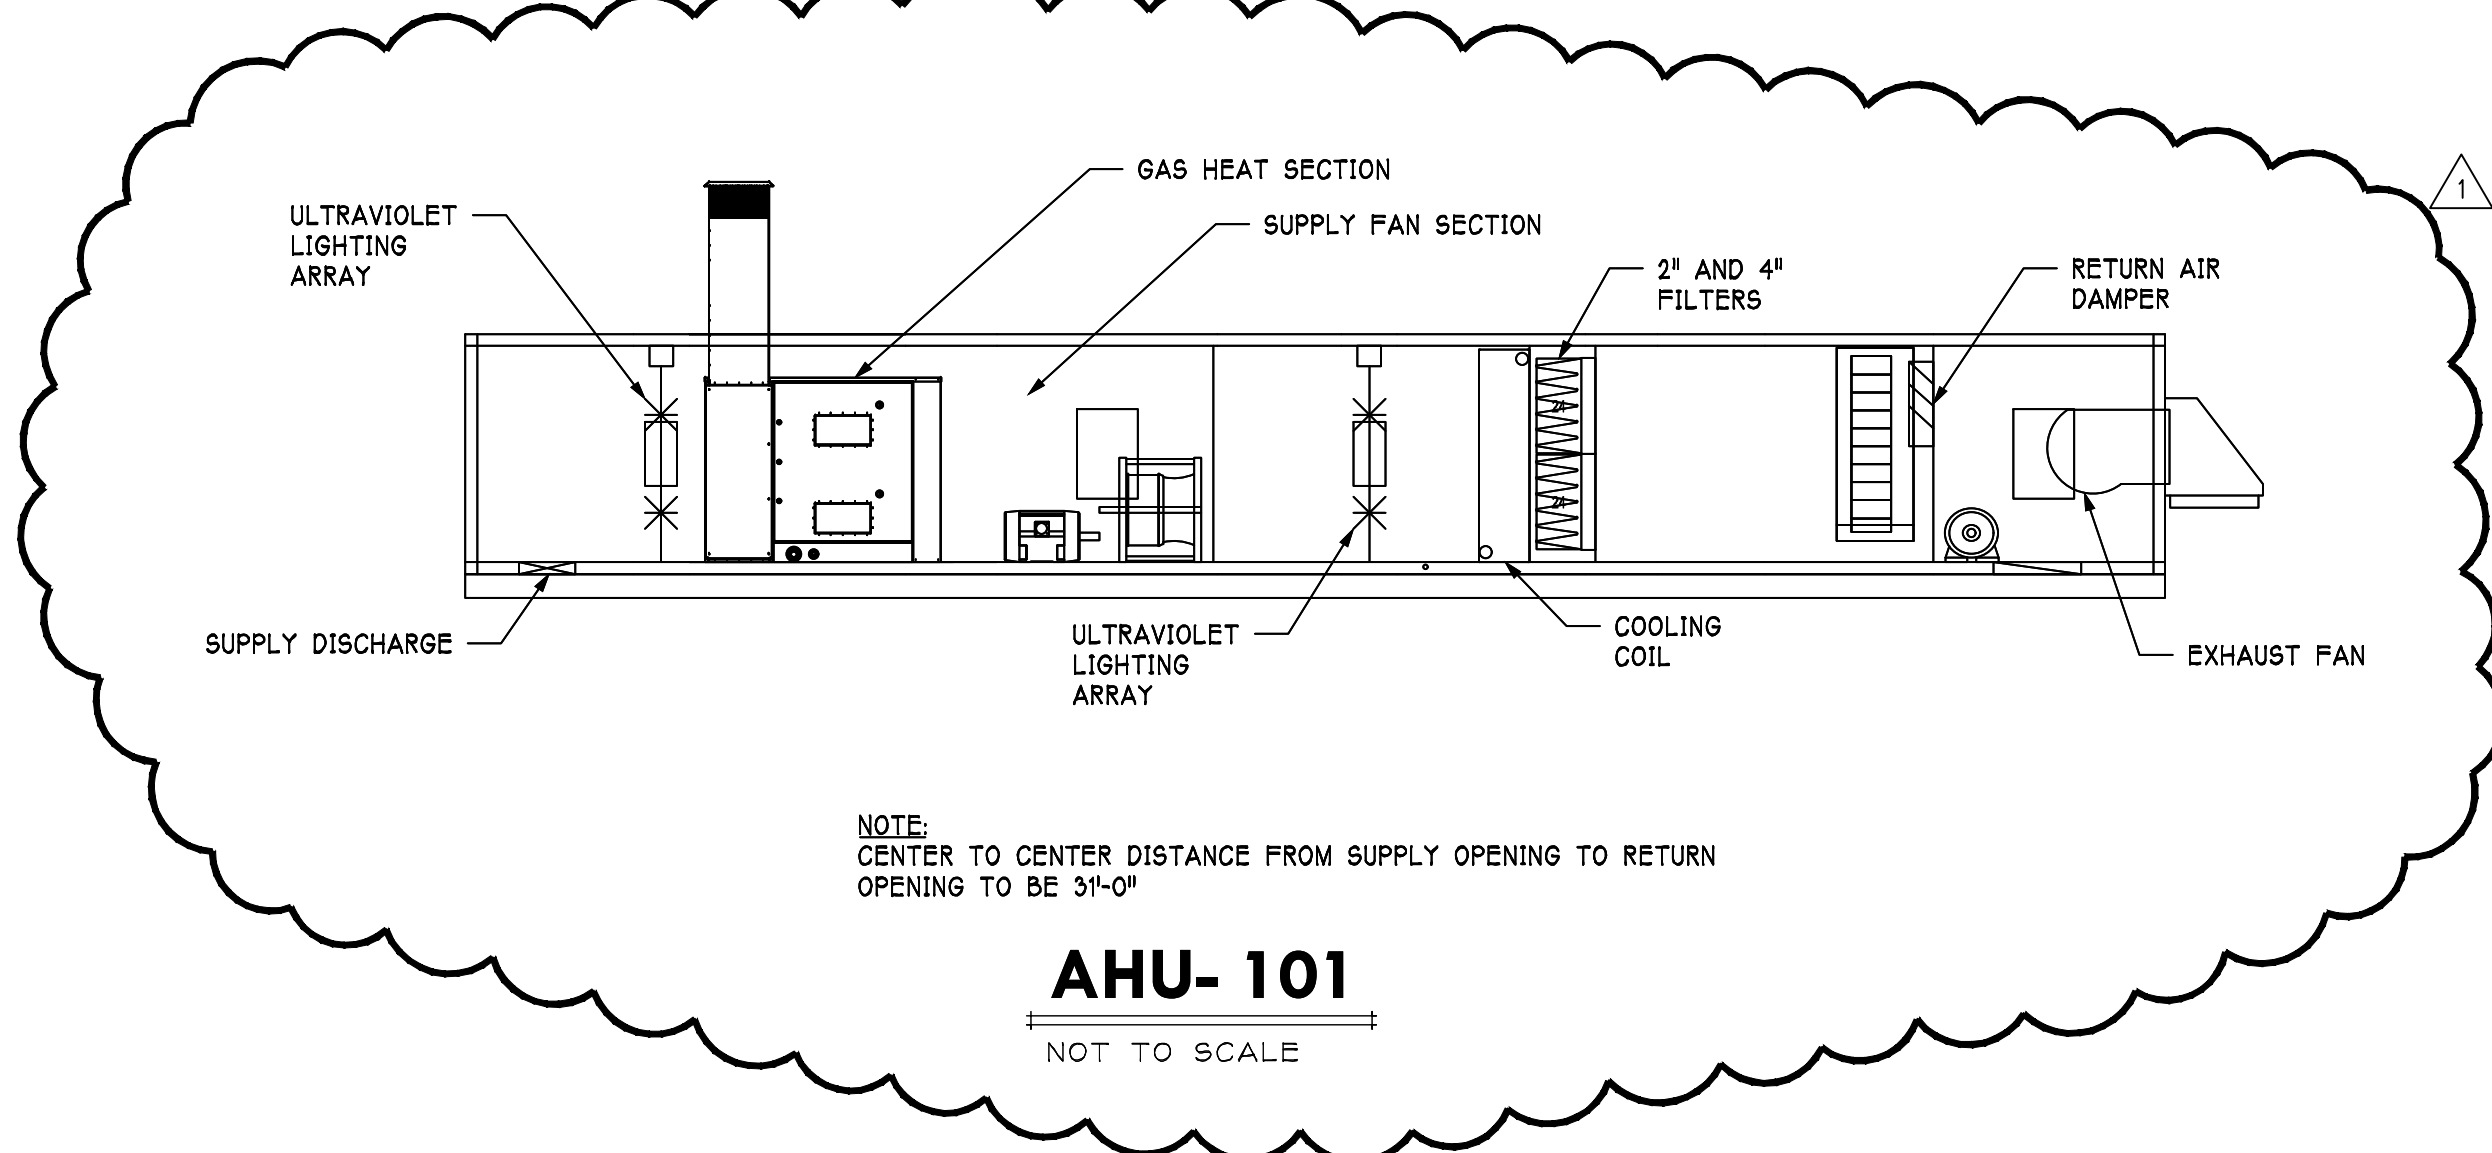


AHU- 101

NOT TO SCALE

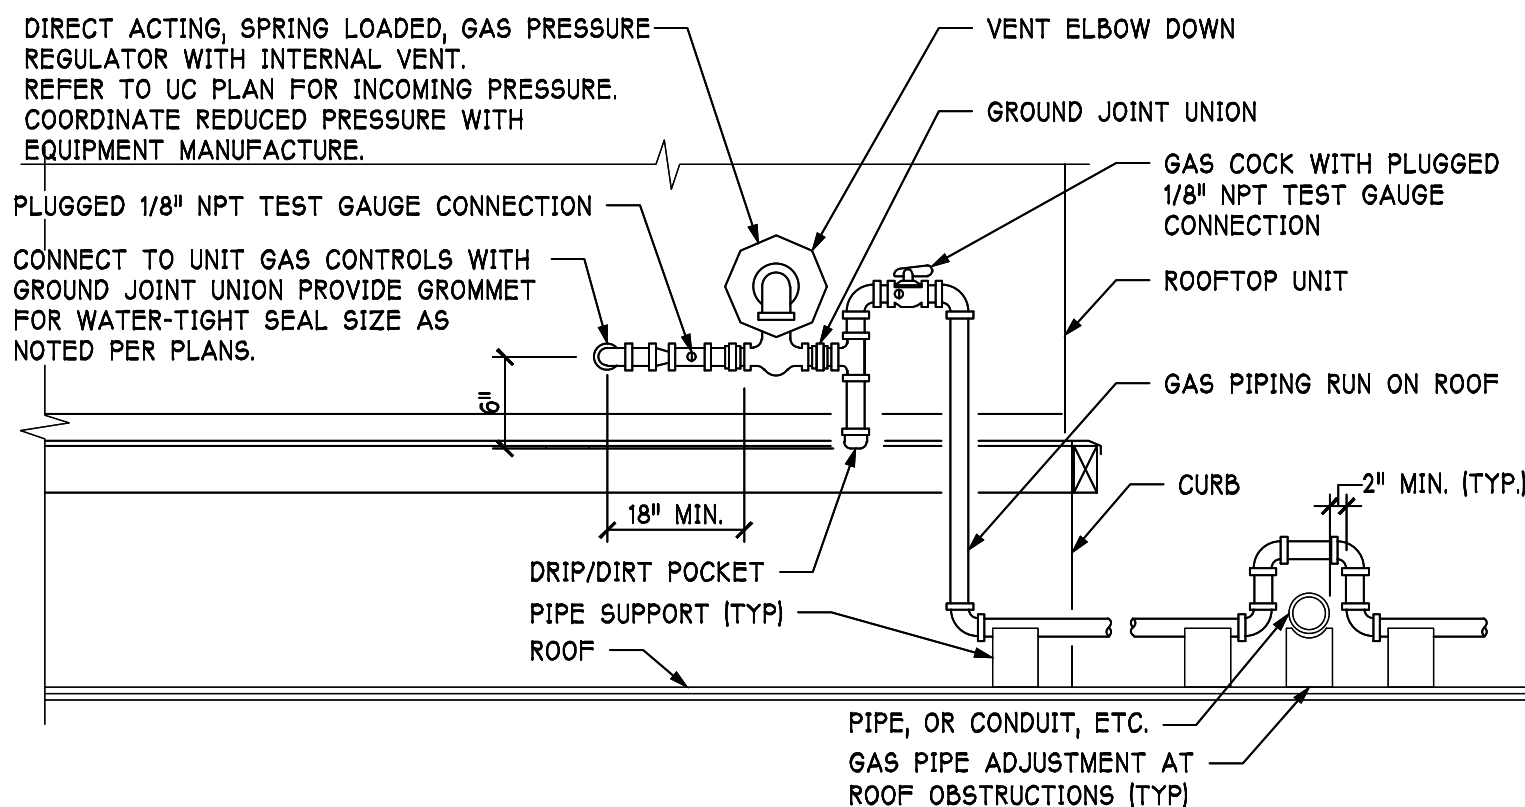


TYPICAL ROOFTOP UNIT GAS PIPING CONNECTION DETAIL

NOT TO SCALE

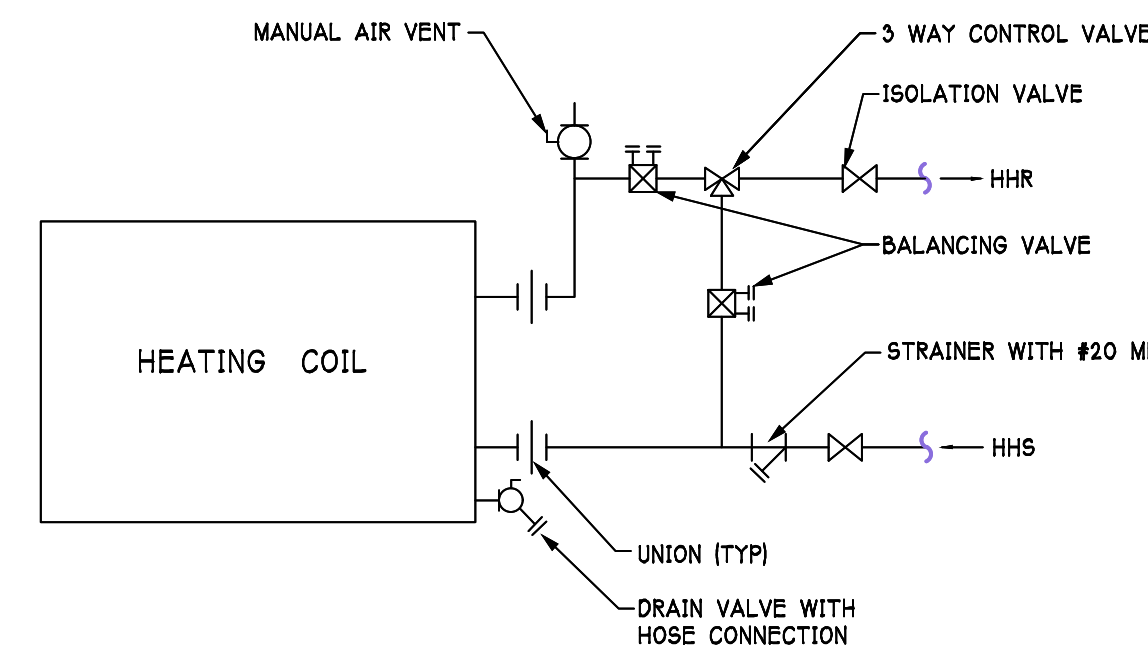


COOLING COIL PIPING DETAIL

NOT TO SCALE

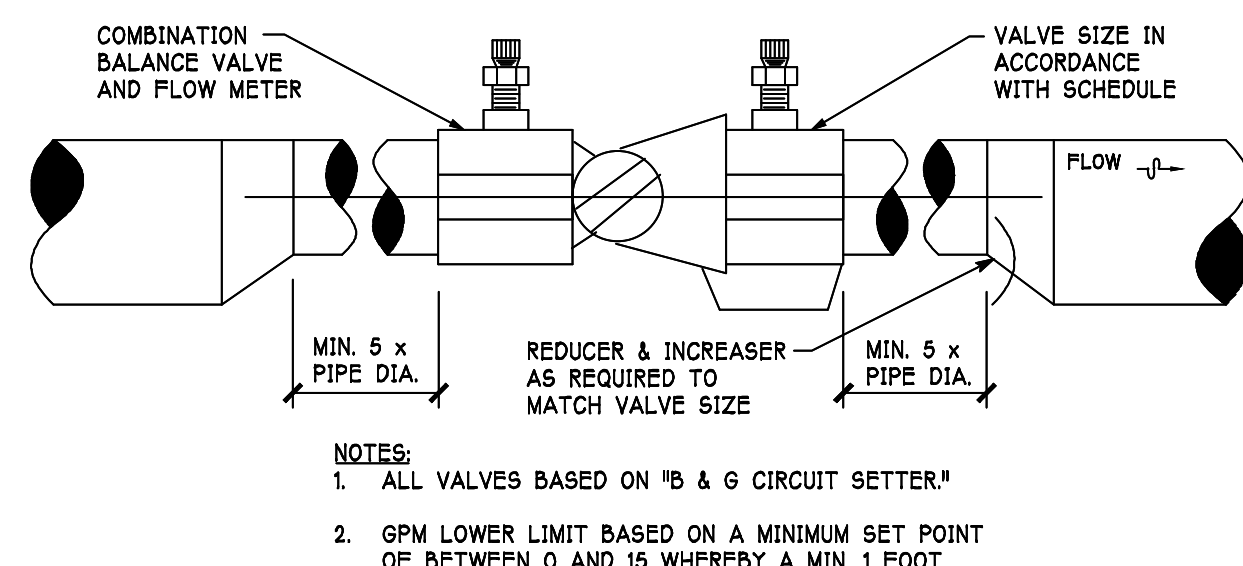

CIRCUIT SETTER DETAIL

NOT TO SCALE

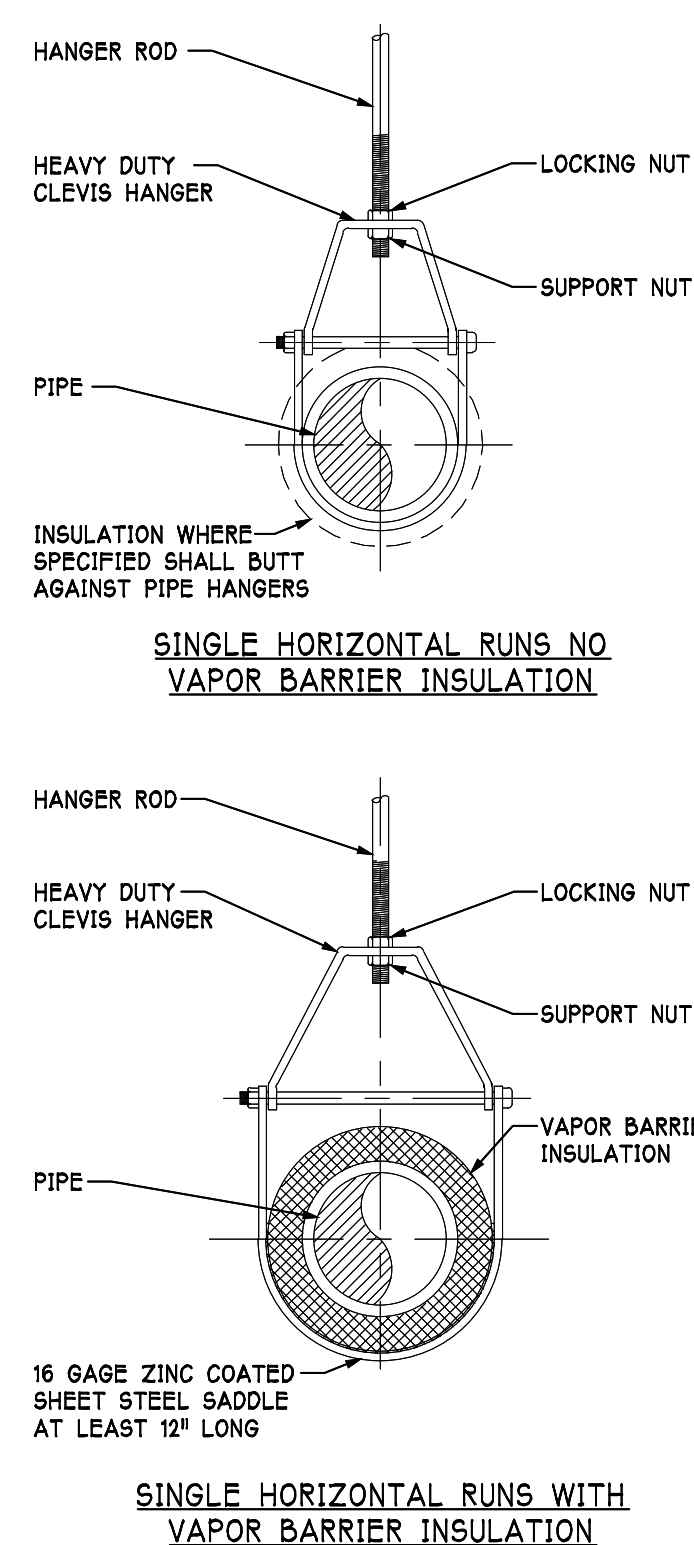

CLEVIS HANGER DETAIL

NOT TO SCALE

HANGER SPACING			
MATERIAL	PIPE SIZE	MAX. ALLOWABLE SPACING HORIZONTAL	MAX. ALLOWABLE SPACING VERTICAL
ABS PIPE	ALL	4'	10'
CAST-IRON PIPE	ALL	8'	10'
COPPER OR COPPER ALLOY TUBING	1-1/4" AND SMALLER 1-1/2" AND LARGER	6' 10'	6' 10'
CROSS-LINKED POLYETHYLENE (PEX) PIPE	ALL	52"	4'
CROSS-LINKED POLYETHYLENE/ ALUMINUMPOLYETHYLENE [PEX-AL-PEX] PIPE	ALL	52"	4'
CPVC PIPE OR TUBING	1" AND SMALLER 1-1/4" AND LARGER	3' 4'	10' 10'
STEEL PIPE	ALL	10'	10'
PB PIPE OR TUBING	ALL	52"	4'
POLYETHYLENE/ALUMINUM [POLYETHYLENE PIPE PEX-AL-PEX] PIPE	ALL	52"	4'
PVC PIPE	ALL	4'	10'

*MAXIMUM PIPE SPACING IS BASED ON 5' LENGTHS OF PIPE. IF 10' OR
LARGER PIPE LENGTHS ARE USED THEN MAXIMUM HORIZONTAL SPACING IS TO
BE INCREASED TO 10'

NOTES:
1. FOR TRAPEZE HANGER TAKE SPACING OF SMALLEST PIPE ON TRAPEZE.
2. THE SPACING SHOWN IN SCHEDULE IS MAXIMUM SPACING PIPE WILL SPAN.
3. THE HANGER SUPPORTS AND STRUCTURAL ELEMENTS OF THE BUILDING SHOULD BE CHECKED FOR LOAD SUPPORT.
4. SPACING MAY HAVE TO BE REDUCED TO LIGHTEN LOAD ON CERTAIN HANGER SUPPORTS.

HANGER ROD SCHEDULE			
PIPE SIZE	ROD SIZE	PIPE SIZE	ROD SIZE
UP TO 2"	3/8" DIA.	4" THRU 5"	5/8" DIA.
2 1/2" THRU 3"	1/2" DIA.	6" THRU 12"	7/8" DIA.

Job No: 1730
Drawn: MAB
Checked: SCP

Revisions:	
No: 1	Date: 02/20/2019
Revised Per Addendum #2	
No:	Date:
No:	Date:
No:	Date:
No:	Date:
No:	Date:
No:	Date:



NEWCOMER ASSOCIATES
architecture + engineering

1105 Shiller Avenue Chambersburg, PA 17201 Tel: 717 263 7380 Fax: 717 263 1001 www.newcomerassoc.com

Martin's Famous Pastry Shoppe
Transportation Cafe

Chambersburg, Pennsylvania 17202

© 2017 Newcomer Associates, Inc.
Drawing Title:
MECHANICAL DETAILS AND SCHEDULES

Sheet No.
M201
Date: MM/DD/YY

PROGRESS PRINT NOT FOR CONSTRUCTION (09/20/18)

Revisions:	
No: 1	Date: 02/20/2019
Revised Per Addendum #2	
No:	Date:
No:	Date:
No:	Date:
No:	Date:
No:	Date:



NEWCOMER ASSOCIATES

architecture + engineering

1105 Shiller Avenue Chambersburg, PA 17201 Tel: 717 263 0001 Fax: 717 263 7380 www.newcomerassociates.com

Martin's Famous Pastry Shoppe
Transportation Cafe


Chambersburg, Pennsylvania 17202

© 2018
Newcomer Associates, Inc.

Drawing Title:
ENLARGED
MEZZANINE
POWER PLAN

Sheet No.
E102
Date: MM/DD/YY


SHEET KEYED NOTES	
1	ADD FEED THOUGHT LUGS TO EXISTING ELECTRICAL PANEL AND CONNECT TO NEW PANEL SECTION. CONNECT USING 3-3/0 AWG WITH #6 GROUND IN A 2-1/2" CONDUIT. FIELD VERIFY EXISTING EQUIPMENT AND CONDITIONS PRIOR TO STARTING WORK.
2	INSTALL NEW PANEL SECTION ADJACENT TO EXISTING PANEL. FIELD VERIFY EXISTING EQUIPMENT AND CONDITIONS PRIOR TO STARTING WORK.
3	INSTALL NEW 30 AMP, 3 POLE BUS PLUG CIRCUIT BREAKER TO SERVE NEW ROOFTOP AIR HANDING UNIT. REFER TO ROOF PLAN FOR CONTINUATION.
4	EXISTING 480 VOLT 3 PHASE BUS DUCT. FIELD VERIFY EXISTING CONDITIONS PRIOR TO STARTING WORK.
5	ROUTE TO PANEL IEI763 AND TERMINATE WITH NEW 15 AMP 3 POLE CIRCUIT BREAKER. FIELD VERIFY EXISTING EQUIPMENT AND CAPACITIES PRIOR TO STARTING WORK.

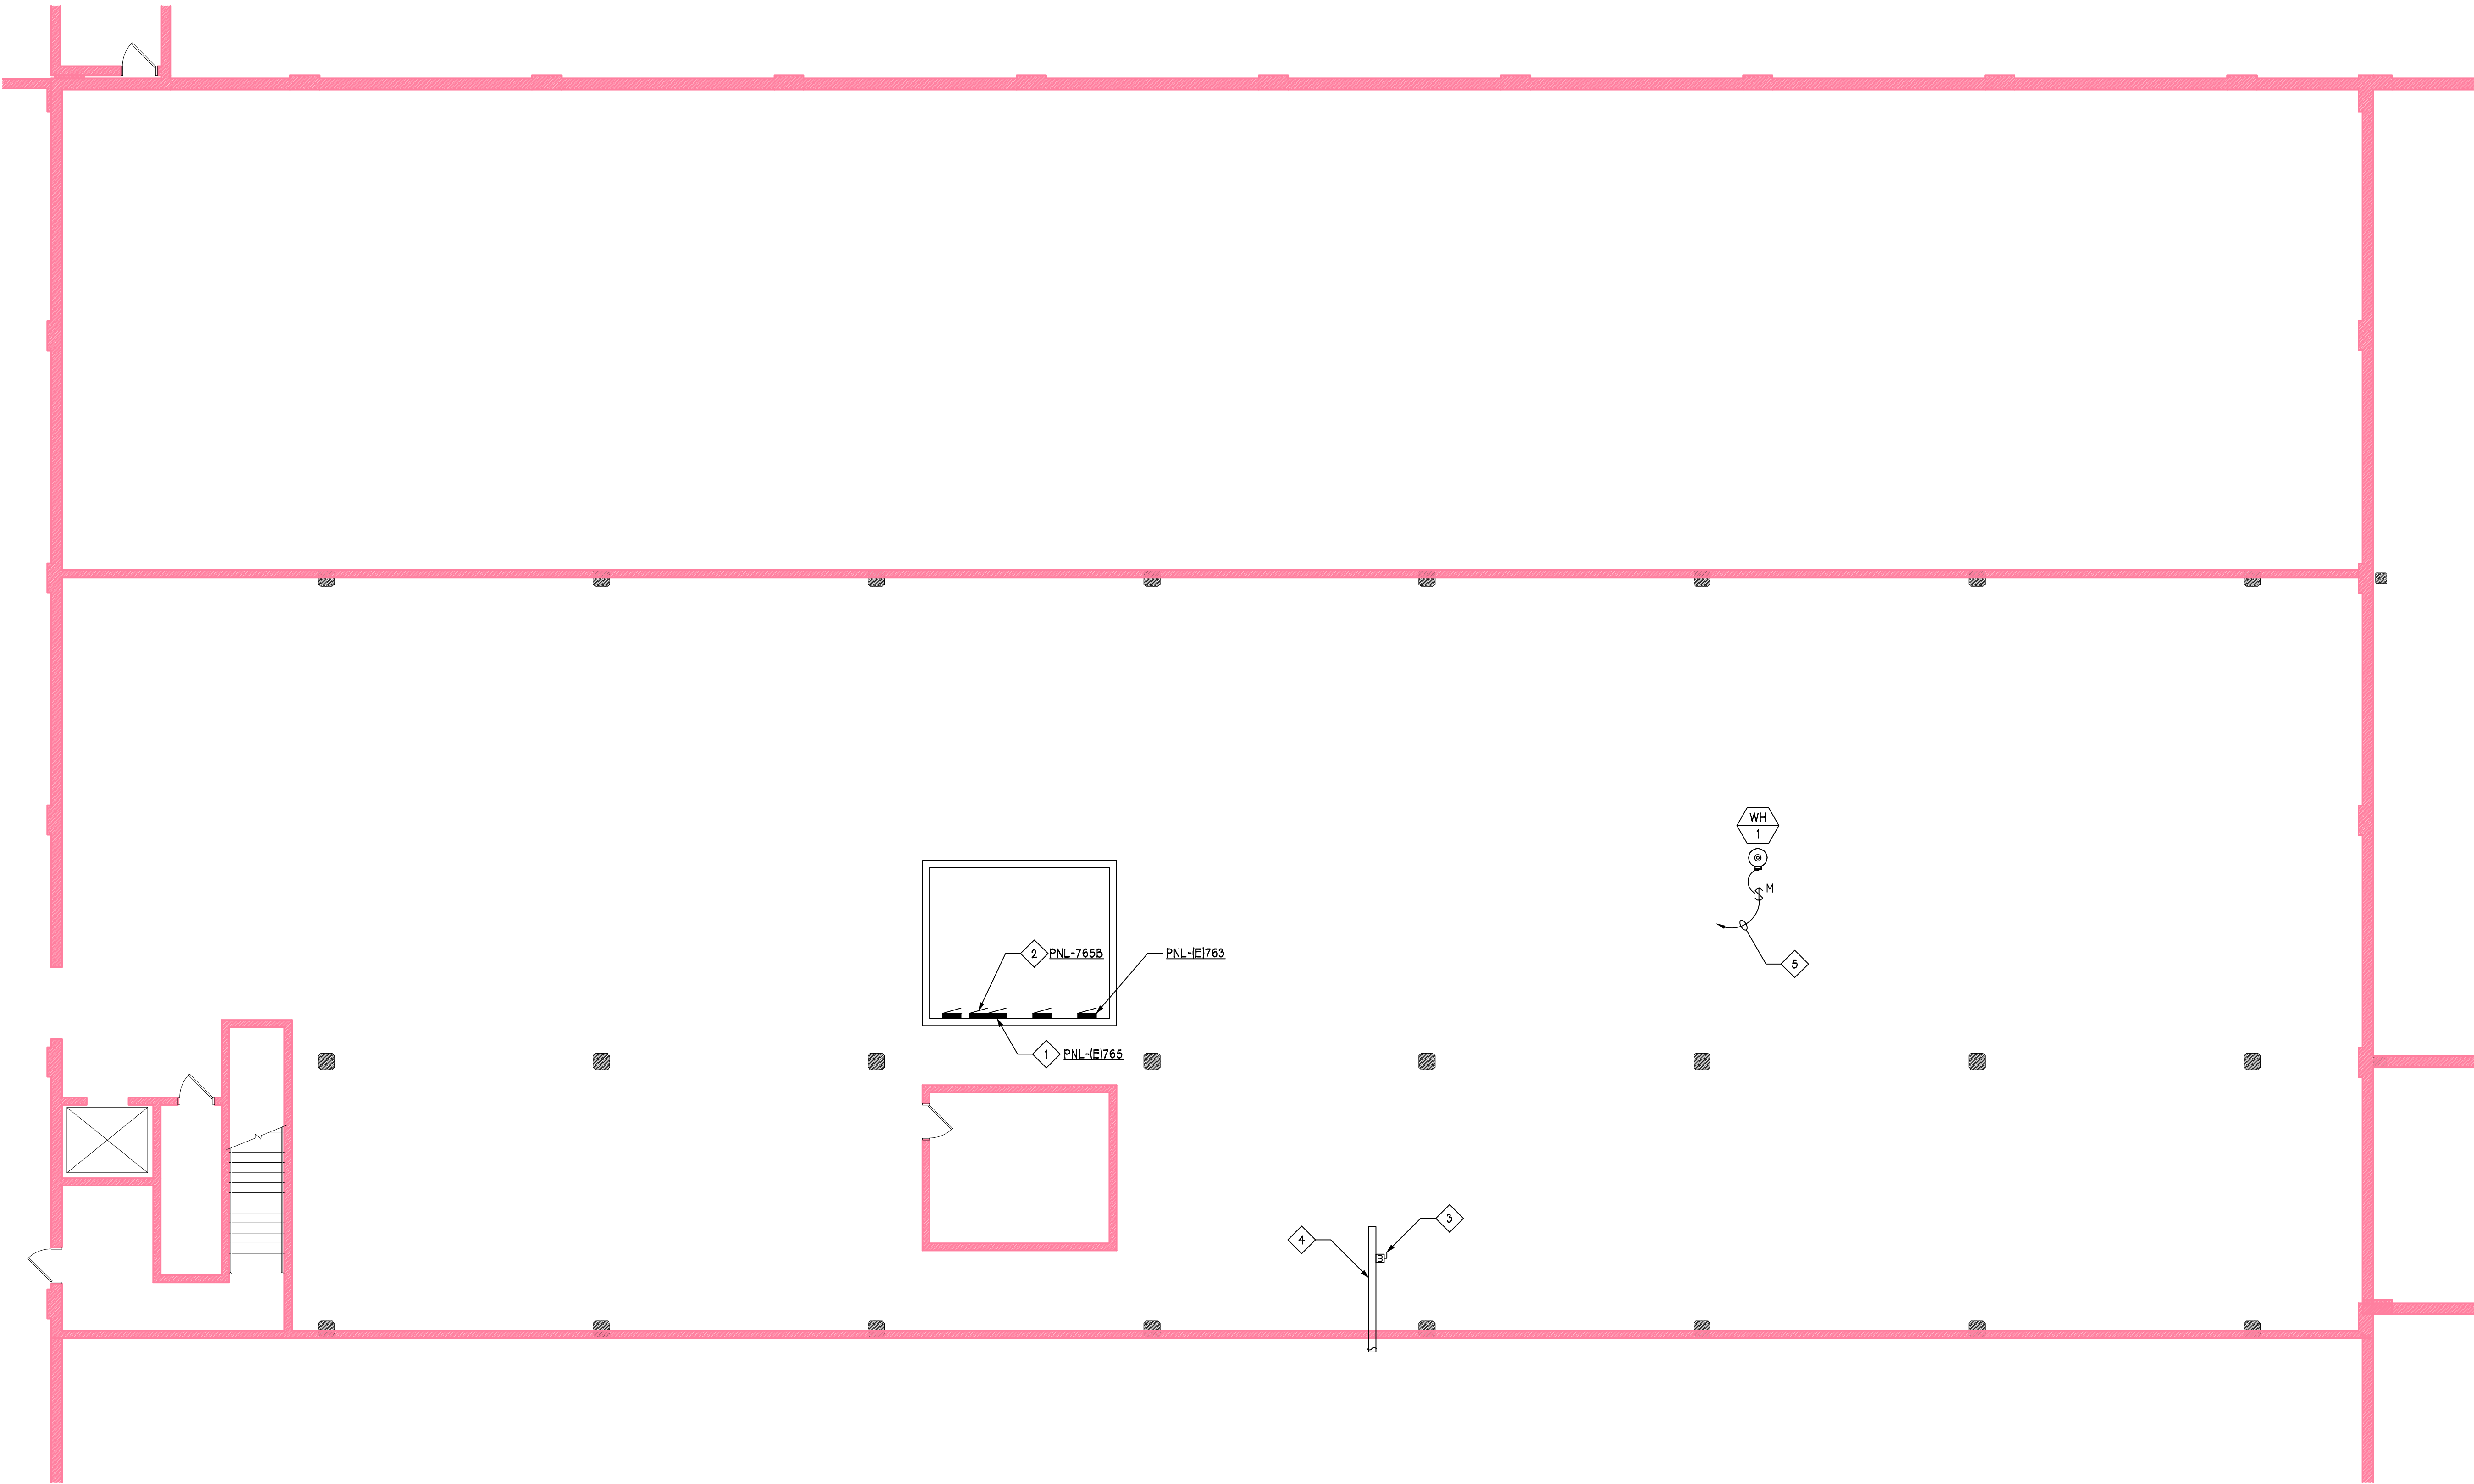

ENLARGED MEZZANINE POWER PLAN
1/8" = 1'-0"

PROGRESS PRINT NOT FOR CONSTRUCTION (09/20/18)

Revisions:	
No: 1	Date: 02/20/2019
Revised Per Addendum #2	
No:	Date:
No:	Date:
No:	Date:
No:	Date:
No:	Date:

 

NEWCOMER ASSOCIATES

architecture + engineering

1105 Shiller Avenue Chambersburg, PA 17201 Tel: 717 263-1001 Fax: 717 263-7380 www.newcomerassociates.com

Martin's Famous Pastry Shoppe
Transportation Cafe


Chambersburg, Pennsylvania 17202

© 2017
Newcomer Associates, Inc.

Drawing Title:
ROOF POWER
PLAN

Sheet No.
E103
Date: MM/DD/YY

SHEET KEYED NOTES	
1	ROUTE BRANCH CIRCUIT TO BUS LOCATED IN MEZZANINE BELOW. REFER TO ADDITIONAL PLANS FOR CONTINUATION AND BRANCH CIRCUIT SIZE.
2	CONNECT TO CONDENSATE HEAT TRACE. REFER TO MECHANICAL FOR LOCATION.
3	CONNECT NOTED CIRCUIT TO UV LIGHTS, UNIT RECEPTACLES, AND UNIT LIGHTING. COORDINATE REQUIREMENTS WITH PROVIDED EQUIPMENT.
4	CONNECT NOTED CIRCUIT TO GAS HEATER AND UNIT CONTROLS. COORDINATE REQUIREMENTS WITH PROVIDED EQUIPMENT.

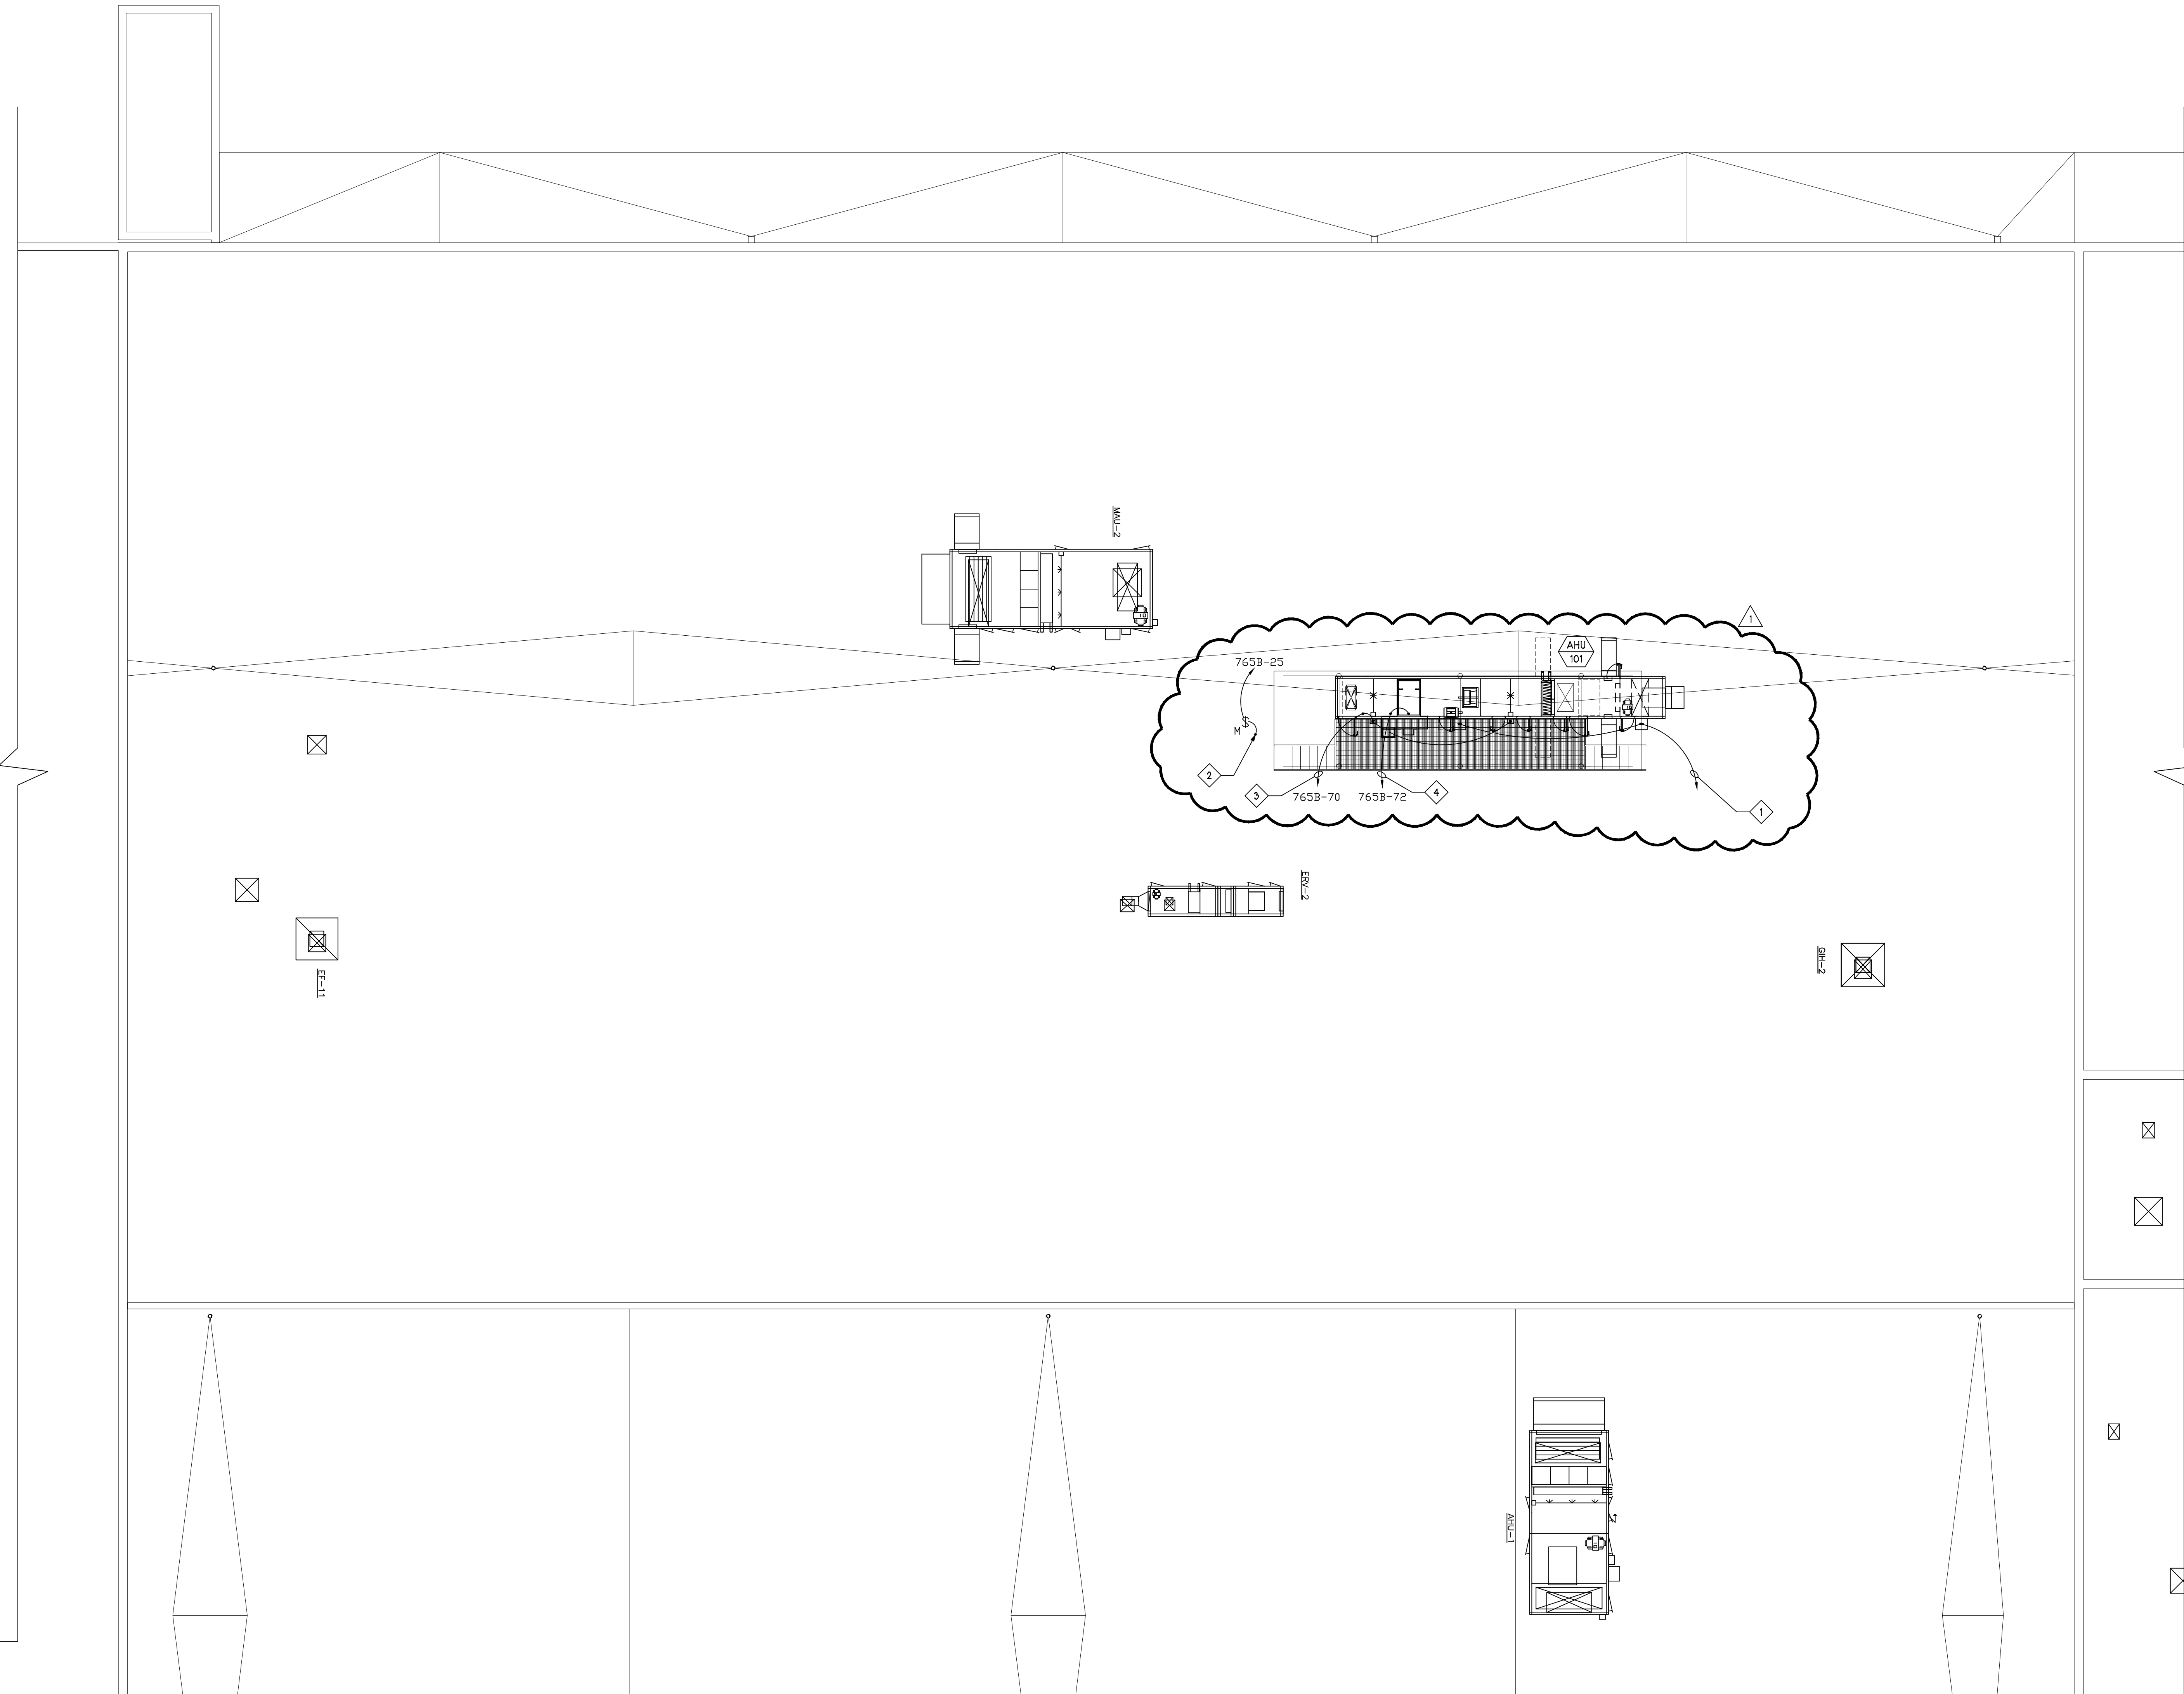

ROOF POWER PLAN
1/8" = 1'-0"

PROGRESS PRINT NOT FOR CONSTRUCTION (09/20/18)

