


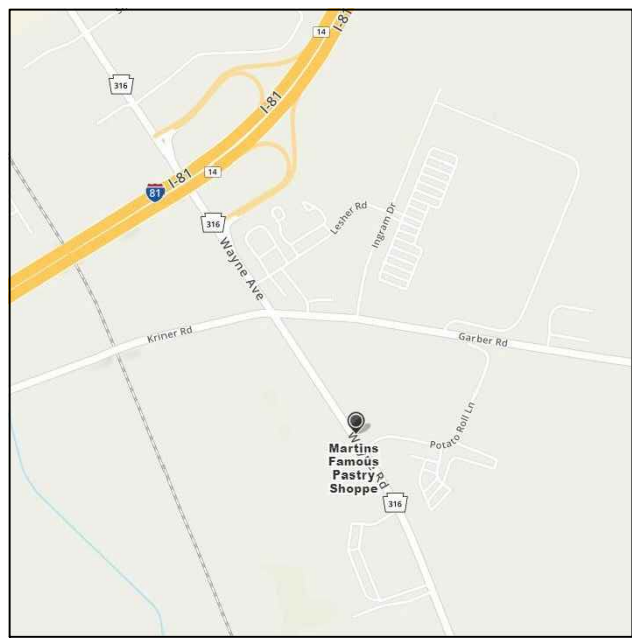

SITE MAP
NOT TO SCALE

Martin's Famous Pastry Shoppe Transportation Cafe

Chambersburg, Pennsylvania 17202

NEWCOMER ASSOCIATES
architecture + engineering

1105 Sheller Avenue Chambersburg PA 17201
Tel: 717 263 0101 Fax: 717 263 7380
www.newcomerassociates.com

Owner:
Martin's Famous Pastry Shoppe
1000 Potato Roll Lane
Chambersburg, PA 17202


Materials Legend:

TYP. FOR ARCHITECTURAL AND STRUCTURAL DRAWINGS



Drawing Symbols Legend:

TYP. FOR ARCHITECTURAL AND STRUCTURAL DRAWINGS

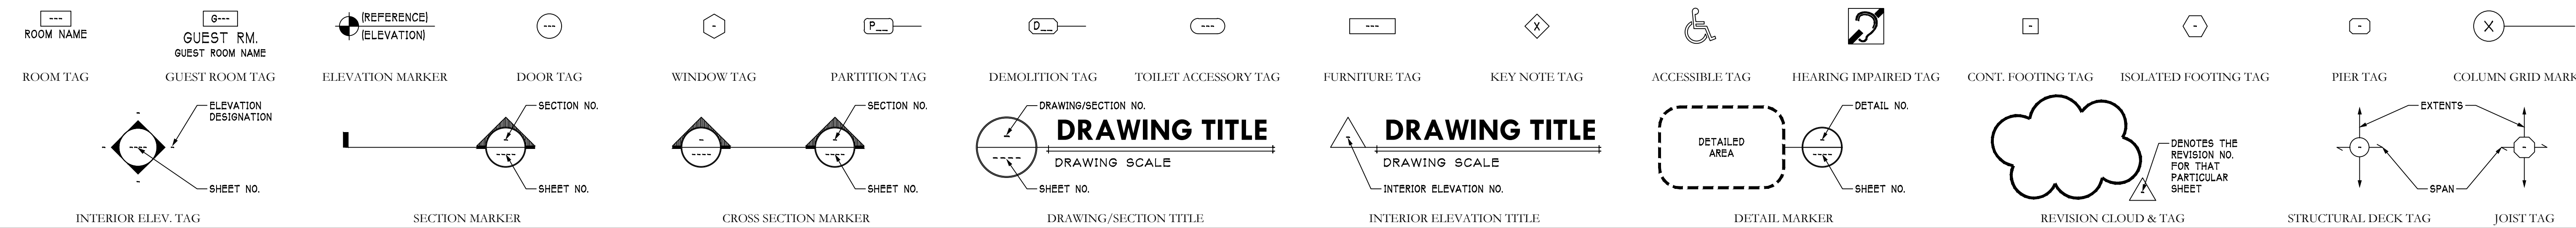

Abbreviations:

ABBR.	DEFINITION	ABBR.	DEFINITION	ABBR.	DEFINITION	ABBR.	DEFINITION	ABBR.	DEFINITION	ABBR.	DEFINITION	ABBR.	DEFINITION	ABBR.	DEFINITION	ABBR.	DEFINITION	ABBR.	DEFINITION	
ABV.	ABOVE	BTM.	BOTTOM	DIA.	DIAMETER	EXT.	EXTERIOR	HLH	HIGH	LLH	LONG LEG HORIZONTAL	N.T.S.	NOT TO SCALE	PTAC	PACKAGED TERMINAL AIR	SGR	SUSPENDED GYPSUM BOARD	T.R.	TOILET ROOM	
ACC.	ACCESSIBLE	CAB.	CABINET	DN.	DOWN	FBRGLS.	FIBERGLASS	LLV	HARDWARE	LOC.	LOCATED/LOCATIONS	O.C.	ON CENTER	PTD.	PAINTED	SGL.	SINGLE	T.S.	TOP OF STEEL	
ADA	AMERICANS WITH DISABILITIES ACT	CLIP.	CAST IN PLACE	DTL.	DETAIL	FD	FLOOR DRAIN	H.M.	HOLLOW METAL	LVC.	LOCATED/LOCATIONS	O.C.E.W.	ON CENTER EACH WAY	PTD.	PAINTED	SH.	SHEET	TS	TUBE STEEL	
ADJ.	ADJUSTABLE/ADJACENT	E.	CENTER LINE	D/W.	DRAWING	FDN.	FOUNDATION	H.M.L.	HOLLOW METAL W/ INSULATED CORE	LONG.	LONGITUDE	O.D.	OUTSIDE DIAMETER	PTN.	PARTITION	SIM.	SIMILAR	TV	TELEVISION	
A.F.F.	ABOVE FINISHED FLOOR	CL.G.	CEILING	DWG.	DRAWING	FE	FIRE EXTINGUISHER	LV.	LAMINATED VENEER LUMBER	LV.	LAMINATED VENEER LUMBER	O.F.	OVERFLOW	Q.T.	QUARRY TILE	SL.	SLOPE	TYP.	TYPICAL	
ALT.	ALTERNATE	CL.G.	CEILING	EA.	EACH	F.F.	FOIL FACED	HORIZ.	HORIZONTAL	M.F.	MAXIMUM	O.H.	OVERHANG/OVERHEAD	R.	RISER	SPECS.	SPECIFICATIONS	U/C	UNDER COUNTER	
A.L.T.	ALTERNATE	CLO.	CLOSET	E.C.	ELECTRICAL CONTRACTOR	FIN.	FINISHED/FINISH	HR.	HOLLOW SHAPED SECTIONS	MAX.	MAXIMUM	OPNG.	OPENING	RD	ROOF DRAIN	S.S.	STAINLESS STEEL	U.L.	UNDERWRITERS LABORATORY	
ALUM.	ALUMINUM	CLR.	CLEAR	EHS	EXTERIOR INSULATION AND FINISH SYSTEM	FLR.	FLOOR	HT.	HEIGHT	M.B.L.	MARBLE	OPP.	OPPOSITE	REF.	REFRIGERATOR	ST&V	STAINED AND VARNISHED	U.N.O.	UNLESS NOTED OTHERWISE	
AN.	ANNEALED	CMU	CONCRETE MASONRY UNIT	F.O.	FACE OF FRAMING/FURRING	HT.	HEIGHT	M.C.	MECHANICAL CONTRACTOR	MECH.	MECHANICAL	OS.F.O.	OUTSIDE FACE OF	REIN.	REINFORCE/REINFORCED/ REINFORCEMENT	STC	SOUND TRANSFER COEFFICIENT	VCT	VINYL COMPOSITION TILE	
ANOD.	ANODIZED	COL.	COLUMN	ELEC.	ELECTRICAL	F.O.F.	FACE OF FRAMING/FURRING	HVAC	HEATING, VENTILATING AND AIR CONDITIONING	MFR.	MANUFACTURER	OS.F.O.	OUTSIDE FACE OF	PAF	POWDER ACTUATED FASTENER	REQD	REQUIRED	STL	STEEL	
APPROX.	APPROXIMATE	CONC.	CONCRETE	ELEV.	ELEVATION/ELEVATOR	FRG.	FURRING	H.W.	HOT WATER	MICRO.	MICROWAVE	REV.	REVISION/REVISE	RFG.	ROOFING	STRUC.	STRUCTURAL	V.L.F.	VERIFY IN FIELD	
ARCH.	ARCHITECT	CONN.	CONNECTION/CONNECTED	EMB.	EMBODIMENT	FRM.	FRAMING	INSUL.	INSULATION	MIN.	MINIMUM/MINUTE	R.M.	ROOM	R.O.	ROUGH OPENING	SUSP.	SUSPENDED	W/	WITH	
A/V	AUDIO / VISUAL	CONST.	CONSTRUCTION	ERD	EMERGENCY ROOF DRAIN	FRP	FIBERGLASS REINFORCED PLASTIC PANELS	INT.	INTERIOR	MISC.	MISCELLANEOUS	PERF.	PERFORATED	P.E.M.B.	PRE-ENGINEERED METAL BUILDING	TEMP.	TEMPERED/TEMPERATURE	W/I	WITHIN	
BD.	BOARD	CONT.	CONTINUOUS	E.O.D.	EDGE OF DECK	FT	FIRE RETARDANT TREATED	INS.	INSIDE	ML.	MASONRY OPENING	RF.	RAIN WATER CONDUCTOR	R.O.	ROUGH OPENING	TF	TEMP.	W/O	WITHOUT	
BEV.	BEVELED	COORD.	COORDINATE	EPDM	ETHYLENE PROPYLENE DIENE MONOMER	FTG.	FOOT/FEET	IS.F.O.	INSIDE FACE OF	MR.	MOISTURE RESISTANT	RWC	RAIN WATER CONDUCTOR	R.O.	ROUGH OPENING	RWC	RAIN WATER CONDUCTOR	WC	WALL CABINET	
B.F.G.	BELOW FINISHED GRADE	CPT.	CARPET	EQ.	EQUAL	FTG.	FOOTING	JST.	JOIST	MTD.	MOUNTED	SACT	SUSPENDED ACOUSTICAL CEILING TILE	SACT	SUSPENDED ACOUSTICAL CEILING TILE	THK.	THICK	WD.	WOOD	
BLDG.	BUILDING	CR.	CRUSHED	JST.	JOIST	GA.	GAGE	JT.	JOINT	MTL.	METAL	SCOT	SUSPENDED CERAMIC GUARD	SCOT	SUSPENDED CERAMIC GUARD	THR.	THRESHOLD	WM	WOOD MOULDING	
BLKG.	BLOCKING	C.T.	CERAMIC TILE	ERD	EMERGENCY ROOF DRAIN	GA.	GAGE	JT.	JOINT	MTL.	METAL	SCOT	SUSPENDED CERAMIC GUARD	SCOT	SUSPENDED CERAMIC GUARD	THR.	THRESHOLD	WM	WOOD MOULDING	
BLKHD.	BULKHEAD	CTL.	CONTROL	E.S.	EACH SIDE	GALV.	GALVANIZED	K.F.	KRAFT FACED	N/A	NOT APPLICABLE	SB	SINK BASE CABINET	SB	SINK BASE CABINET	T.O.	TOP OF	W.W.F.	WELDED WIRE FABRIC	
BL.	BEAM	D.	DIET	E.W.	EACH WAY	G.C.	GENERAL CONTRACTOR	K.O.	KNOCK OUT	NECY	NECESSARY	PLUMB.	PLUMBING	PLUMB.	PLUMBING	T.O.D.	TOP OF DECK	XX	INCHES PER FOOT	
BRG.	BEARING	PI	PINNY	EWC	ELECTRIC WATER COOLER	GWB	GYPSUM WALL BOARD	LAM.	LAMINATED	N/C	NOT IN CONTRACT	PLYWD.	PLYWOOD	PLYWD.	PLYWOOD	CEILING TILE	T.O.M.	TOP OF MASONRY	@	AT
B.S.	BOTH SIDES	DBL.	DOUBLE	EXST.	EXISTING	GYP.	GYPSUM	LAV.	LAVATORY	NO./#	NUMBER	PSL	PANEL	SCHED.	SCHEDULE	SCHEDULE	T.O.P.	TOP OF PARAPET	Ø	DIAMETER
BSMT.	BASEMENT	DEMO.	DEMOLITION	EXP.	EXPANSION/EXPOSED	GYP. ASSOC.	GYPSUM ASSOCIATION	LBS./#	POUNDS	NOM.	NOMINAL	P.T.	PRESSURE TREATED	S.F.	SQUARE FEET	TP	TOP OF PIER	±	PLUS OR MINUS	

Building Data:

APPLICABLE BUILDING CODES 2015 IEBC LEVEL 2 ALTERATION PER SECTION 404 ADA 2009 ANSI 117.1	T.R.	TOILET ROOM
USE GROUP TYPE B	BUSINESS (IBC 304)	
CONSTRUCTION TYPE TYPE IIB (IBC 602)		

PROGRESS PRINT NOT FOR CONSTRUCTION (09/20/18)

Job No: 1730
Drawn: WShoop
Checked:

Revisions:

No.	Date:
No.	Date:
No.	Date:
No.	Date:
No.	Date:
No.	Date:



NEWCOMER ASSOCIATES
architecture + engineering

1105 Sheller Avenue Chambersburg, PA 17201 Tel: 717 263 0101 Fax: 717 263 7380 www.newcomerassociates.com

Martin's Famous Pastry Shoppe
Transportation Cafe


© 2018 Newcomer Associates, Inc.

Drawing Title:
COVER SHEET

Sheet No.
000

Date: MM/DD/YY


PROGRESS PRINT NOT FOR CONSTRUCTION (09/20/18)

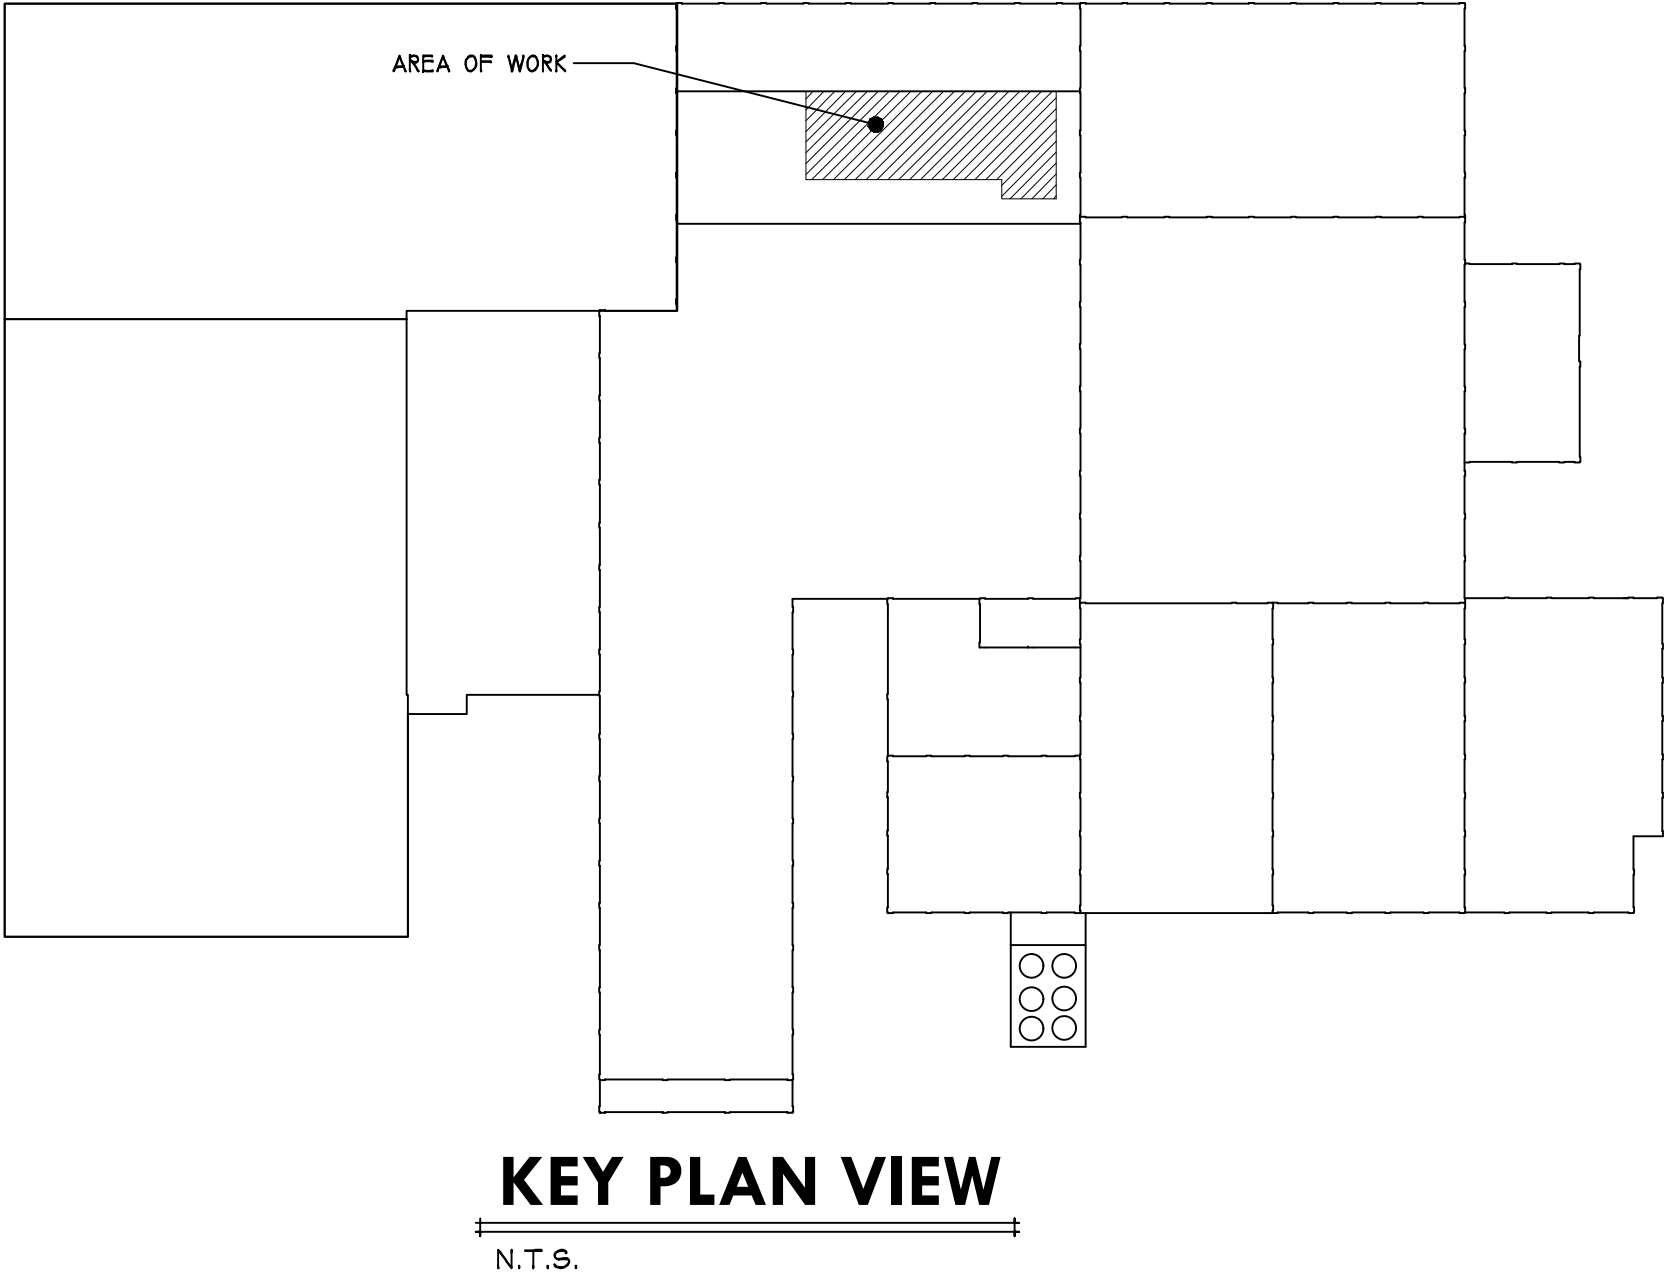

DEMOLITION SCHEDULE	
TYPE	DESCRIPTION
D1	REMOVE EXIST. DOOR & FRAME
D2	REMOVE EXIST. WALL
D3	REMOVE EXIST. WINDOW
D4	REMOVE EXIST. PARTITION WALL, DOOR, AND TRACK
D5	REMOVE EXIST. MOP SINK
D6	REMOVE EXIST. SHELVING
D7	REMOVE EXIST. MILLWORK
D8	DEMO. EXIST. WALL AT RELOCATED DOOR LOCATION. PATCH & REPAIR ADJACENT WALLS.
D9	REMOVE EXIST. DOOR & FRAME. SAVE FOR RELOCATION.
D10	REMOVE EXIST. SINK.
D11	REMOVE EXIST. REFRIGERATOR.
D12	REMOVE EXIST. ACT CEILING TILE.
D13	REMOVE EXIST. GYP. BD & FINISHES TO EXPOSE EXIST. CONC. COLUMN. PATCH & PREPARE FOR NEW PAINT.
D14	REMOVE EXIST. SHOWER.
D15	REMOVE WOOD MAINSCOT, BASE, AND DRYWALL FOR NEW CEMENT BOARD ON EXISTING FRAMING

DEMOLITION GENERAL NOTES:

- OWNER RESERVES SALVAGE RIGHTS TO ANY CONSTRUCTION TO BE DEMOLISHED. ITEMS REJECTED BY THE OWNER SHALL BECOME THE REMOVING CONTRACTORS PROPERTY. CONTRACTOR IS TO DISPOSE OF DEMOLISHED CONSTRUCTION OFF SITE. COORDINATE ALL DEMOLITION WORK WITH OWNER.
- MAINTAIN STRUCTURAL INTEGRITY OF REMAINING BUILDING AT ALL TIMES DURING DEMOLITION.
- MAINTAIN BUILDING IN A WEATHER TIGHT CONDITION AT ALL TIMES DURING DEMOLITION.
- SEE PLUMBING, MECHANICAL, AND ELECTRICAL DRAWINGS FOR ADDITIONAL DEMOLITION INFORMATION.
- TAKE ALL PRECAUTIONS NECESSARY TO MAINTAIN SECURITY OF THE OWNERS NORMAL OPERATIONS DURING DEMOLITION.

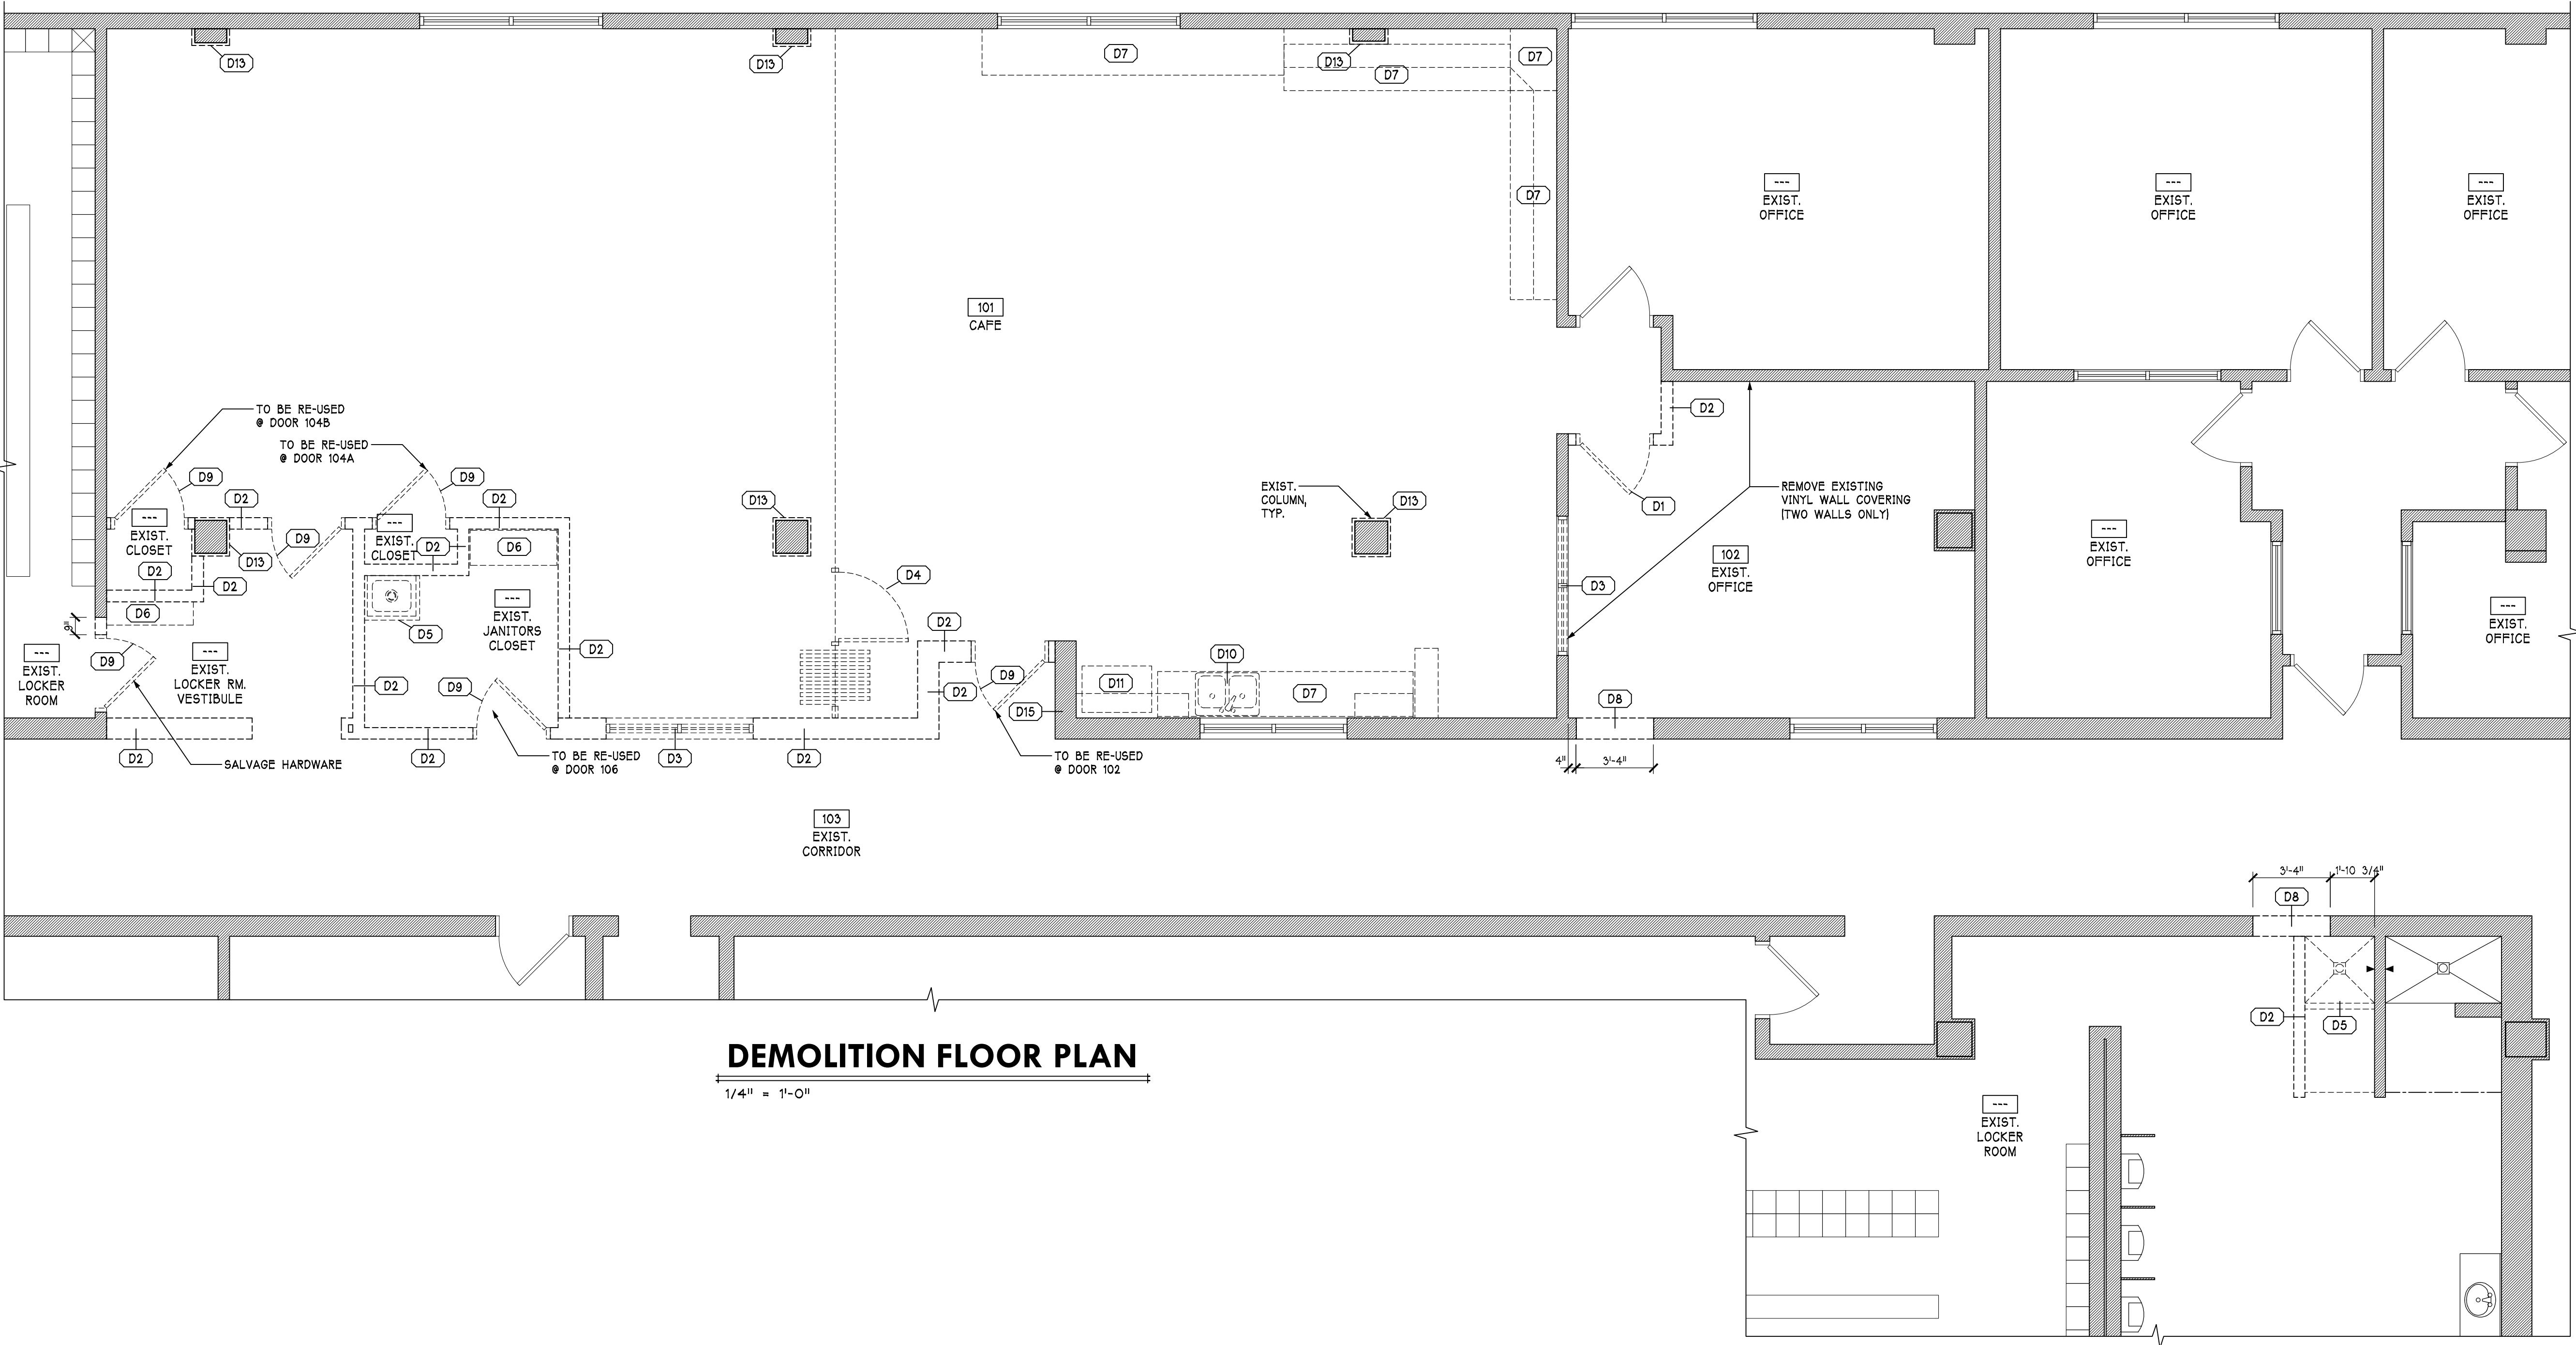

PROGRESS PRINT NOT FOR CONSTRUCTION (09/20/18)

Job No: 1730
Drawn: WShoop
Checked:

Revisions:	
No: 1	Date: 05/13/19
Revisions per Addendum No. 4	
No:	Date:
No:	Date:
No:	Date:
No:	Date:
No:	Date:
No:	Date:
No:	Date:

NEWCOMER ASSOCIATES
architecture + engineering
1105 Shiller Avenue Chambersburg, PA 17201 Tel: 717 263 1001 Fax: 717 263 7388 www.newcomerassociates.com

Martin's Famous Pastry Shoppe
Transportation Cafe
Chambersburg, Pennsylvania 17202

© 2018 Newcomer Associates, Inc.

Drawing Title:
DEMOLITION FLOOR PLAN

Sheet No.
A001
Date: MM/DD/YY

PAINT SCHEDULE				
FINISH #	MANUFACTURER	COLOR	FINISH	REMARKS
PT-2	SHERWIN WILLIAMS	SW8012 POLVO DE ORO	FLAT	VERTICAL & HORIZONTAL FACES @ CENTRAL BULKHEAD
PT-4	SHERWIN WILLIAMS	SW6141 SOFTER TAN	EGGSHELL	WALL PAINT
PT-6	SHERWIN WILLIAMS	SW7005 PURE WHITE	FLAT	BOTTOM OF BULKHEAD @ EXISTING CORRIDOR 103
PT-11	SHERWIN WILLIAMS	SW2811 ROOKWOOD BLUE GREEN	EGGSHELL	ACCENT PAINT @ CONCRETE COLUMNS

BASE SCHEDULE						
FINISH #	MANUFACTURER	PRODUCT	COLOR	SIZE	THICKNESS	REMARK
B-2	JOHNSONITE	RESILIENT BASE	09 CLAY	4" H	1/8"	-
B-10	JOHNSONITE	RESILIENT BASE	40 BLACK	4" H	1/8"	-





CERAMIC TILE SCHEDULE							TILE GROUT SCHEDULE				
FINISH #	MANUFACTURER	COLLECTION	COLOR	SIZE	PATTERN	REMARKS	MANUF.	PRODUCT	COLOR	JOINT	REMARKS
CT-1	AMERICAN OLEAN	INFUSION	GOLD WENSE II#63	12" x 24" x 3/8"	STAGGERED 33X	SEE INTERIOR ELEVATIONS FOR PATTERN LAYOUT	CUSTOM BUILDING PRODUCTS	HIGH PERFORMANCE GROUT	360 HAYSTACK	1/8"	-
CT-2	AMERICAN OLEAN	THEORETICAL	DEEP COLOR TH88	6" x 24" x 3/8"	STAGGERED 33X	SEE INTERIOR ELEVATIONS FOR PATTERN LAYOUT	CUSTOM BUILDING PRODUCTS	HIGH PERFORMANCE GROUT	50 NUTMES	1/8"	-
CT-5	DALTILE	COLORWAVE	WHIPPED CREAM CW05	1" x 6" x 5/16"	SEE REMARKS	SEE INTERIOR ELEVATIONS FOR PATTERN LAYOUT	CUSTOM BUILDING PRODUCTS	HIGH PERFORMANCE GROUT	172 URBAN PUTTY	1/8"	-

ROOM FINISH SCHEDULE																
ROOM		FLOOR		WALLS								CEILING			REMARKS	
				NORTH		EAST		SOUTH		WEST						
NO.	DESCRIPTION	MAT.	BASE	MAT.	FIN.	MAT.	FIN.	MAT.	FIN.	MAT.	FIN.	MAT.	FIN.	HT.		
101	CAFE	EPOXY	VINYL	EXIST.	-	EXIST.	-	EXIST.	PTD.	EXIST.	PTD.	SACT	--	7'-9"	--	
102	EXIST. OFFICE	EXIST.	VINYL	EXIST.	PTD.	EXIST.	PTD.	EXIST.	PTD.	EXIST.	PTD.	SACT	--	EXIST.	--	
103	EXIST. CORRIDOR	EXIST.	EXIST.	EXIST.	EXIST.	EXIST.	EXIST.	EXIST.	*	EXIST.	-	SACT	--	EXIST.	--	* PAINT @ NEW BULKHEAD
104	LOCKER ROOM EGRESS	EPOXY	B-2	GWB	PT.-4	GWB	PT.-4	GWB	PT.-4	EXIST.	PT.-4	SACT	--	7'-9"	--	
106	JANITORS CLOSET	EPOXY	B-2	EXIST.	FRP	EXIST.	FRP	GWB	FRP	GWB	FRP	SACT	--	7'-9"	--	FRP TO BE FULLY ADHERED




DOOR AND FRAME SCHEDULE																
DOOR												FRAME			REMARKS	
NO.	TYPE	STYLE	SIZE	THK.	MAT.	FIN.	GLAZING	RATING	HDWR.	SILL	JAMB	TYPE	MAT.	FIN.		
102	HINGED	HL	3'-0" x 7'-0"	1 3/4"	H.M.	PTD.	EXIST. G2	--	EXIST./NEW	--	1	1	H.M.	PTD.	RELOCATED DOOR TO BE PAINTED/NEW FRAME; PROVIDE NEW LEVER LOCKSET	
104A	HINGED	F	3'-0" x 7'-0"	1 3/4"	H.M.	PTD.	--	--	EXIST. *	--	2	1	H.M.	PTD.	RELOCATED DOOR TO BE PAINTED/NEW FRAME; * REUSE LOCKER ROOM DOOR HARDWARE	
104B	HINGED	F	3'-0" x 7'-0"	1 3/4"	H.M.	PTD.	--	--	EXIST.	--	3	1	H.M.	PTD.	RELOCATED DOOR TO BE PAINTED/NEW FRAME	
106	HINGED	F	3'-0" x 7'-0"	1 3/4"	H.M.	PTD.	--	--	EXIST.	--	1	1	H.M.	PTD.	RELOCATED DOOR TO BE PAINTED/NEW FRAME	

ABBREVIATIONS	
ABBR.	DEFINITION
EXIST.	EXISTING
GWB	GYPSUM WALL BOARD
H.M.	HOLLOW METAL
PTD.	PAINTED
FRP	FIBER REINFORCED PLASTIC PANEL
EPOXY	EPOXY FLOORING BY OWNER

GLAZING SCHEDULE	
ABBR.	DEFINITION
G2	1/4" TEMPERED SAFETY GLASS-LAMINATED

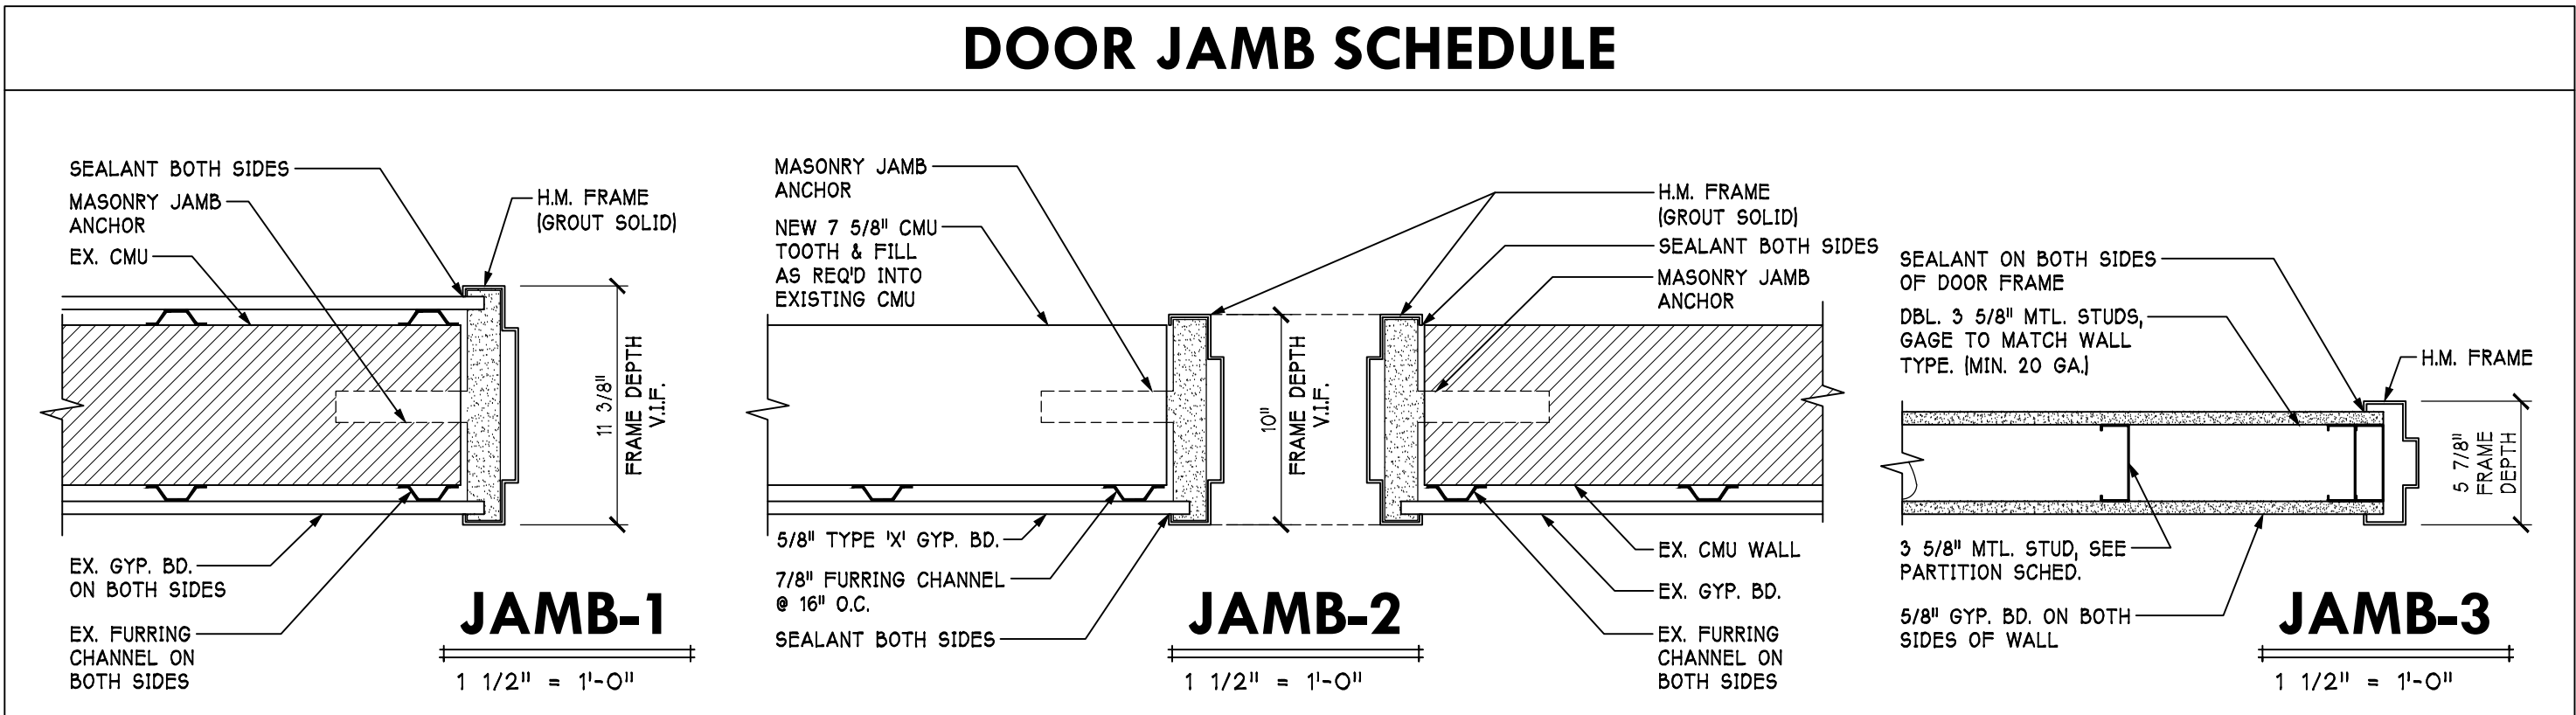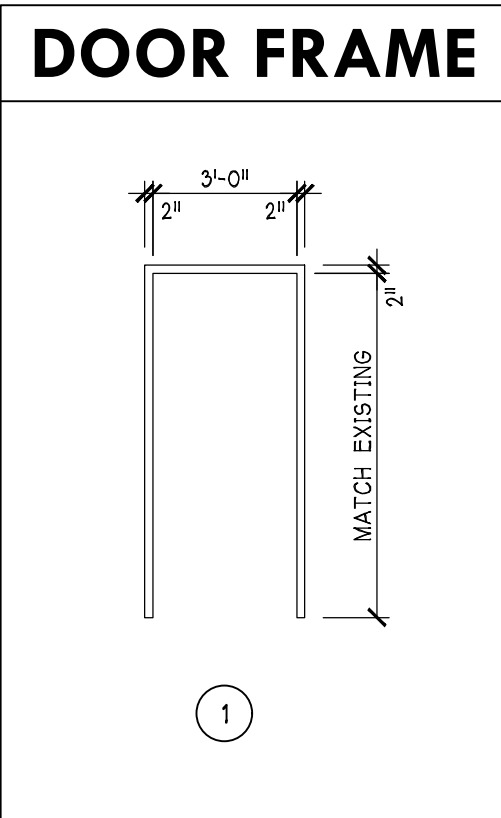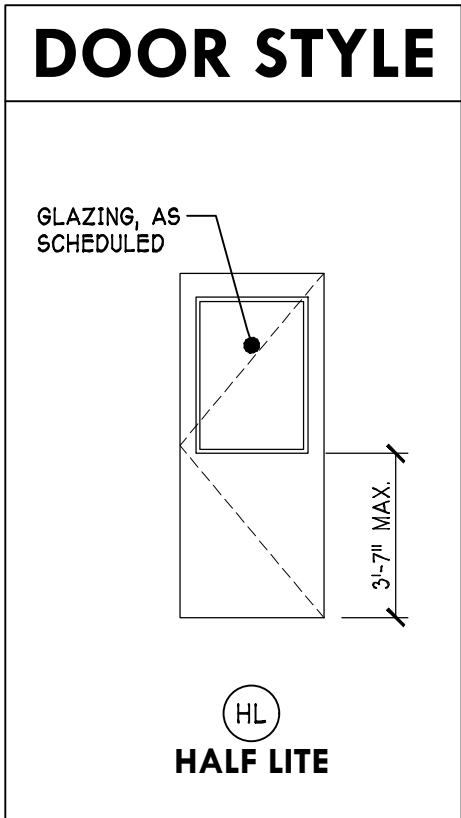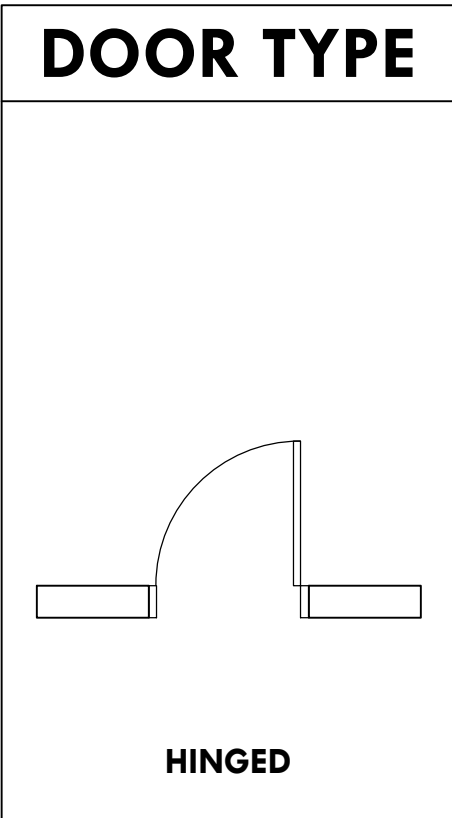

PARTITION TYPE SCHEDULE			
TYPE	CONSTRUCTION	REMARKS	RATINGS
PA1	2509163-33, 33 KSI (DRYWALL) MTL. STUDS @ 16" O.C. W/ 5/8" TYPE 'X' GYP. BD. ON BOTH SIDES	---	---
PB1	36255125-33, 33 KSI (DRYWALL) MTL. STUDS @ 16" O.C. W/ 5/8" TYPE 'X' GYP. BD. ON BOTH SIDES	USE CEMENT BD. IN LIEU OF TYPE 'X' GYP. BD. WHERE CERAMIC TILE OCCURS. USE MOISTURE RESISTANT GWB @ FRP LOCATIONS.	---
PB2	36255125-33, 33 KSI (DRYWALL) MTL. STUDS @ 16" O.C. W/ 5/8" TYPE 'X' GYP. BD. ON ONE SIDE	USE CEMENT BD. IN LIEU OF TYPE 'X' GYP. BD. WHERE CERAMIC TILE OCCURS.	---
PC1	MATCH EXISTING ADJACENT WALL CONSTRUCTION W/ METAL STUD FRAMING @ 16" O.C.	---	---
PD1	MATCH EXISTING ADJACENT WALL CONSTRUCTION W/ CMU, FURRING STRIPS @ 16" O.C. & 5/8" GWB	G.C. TO CONFIRM EXISTING CONSTRUCTION	---

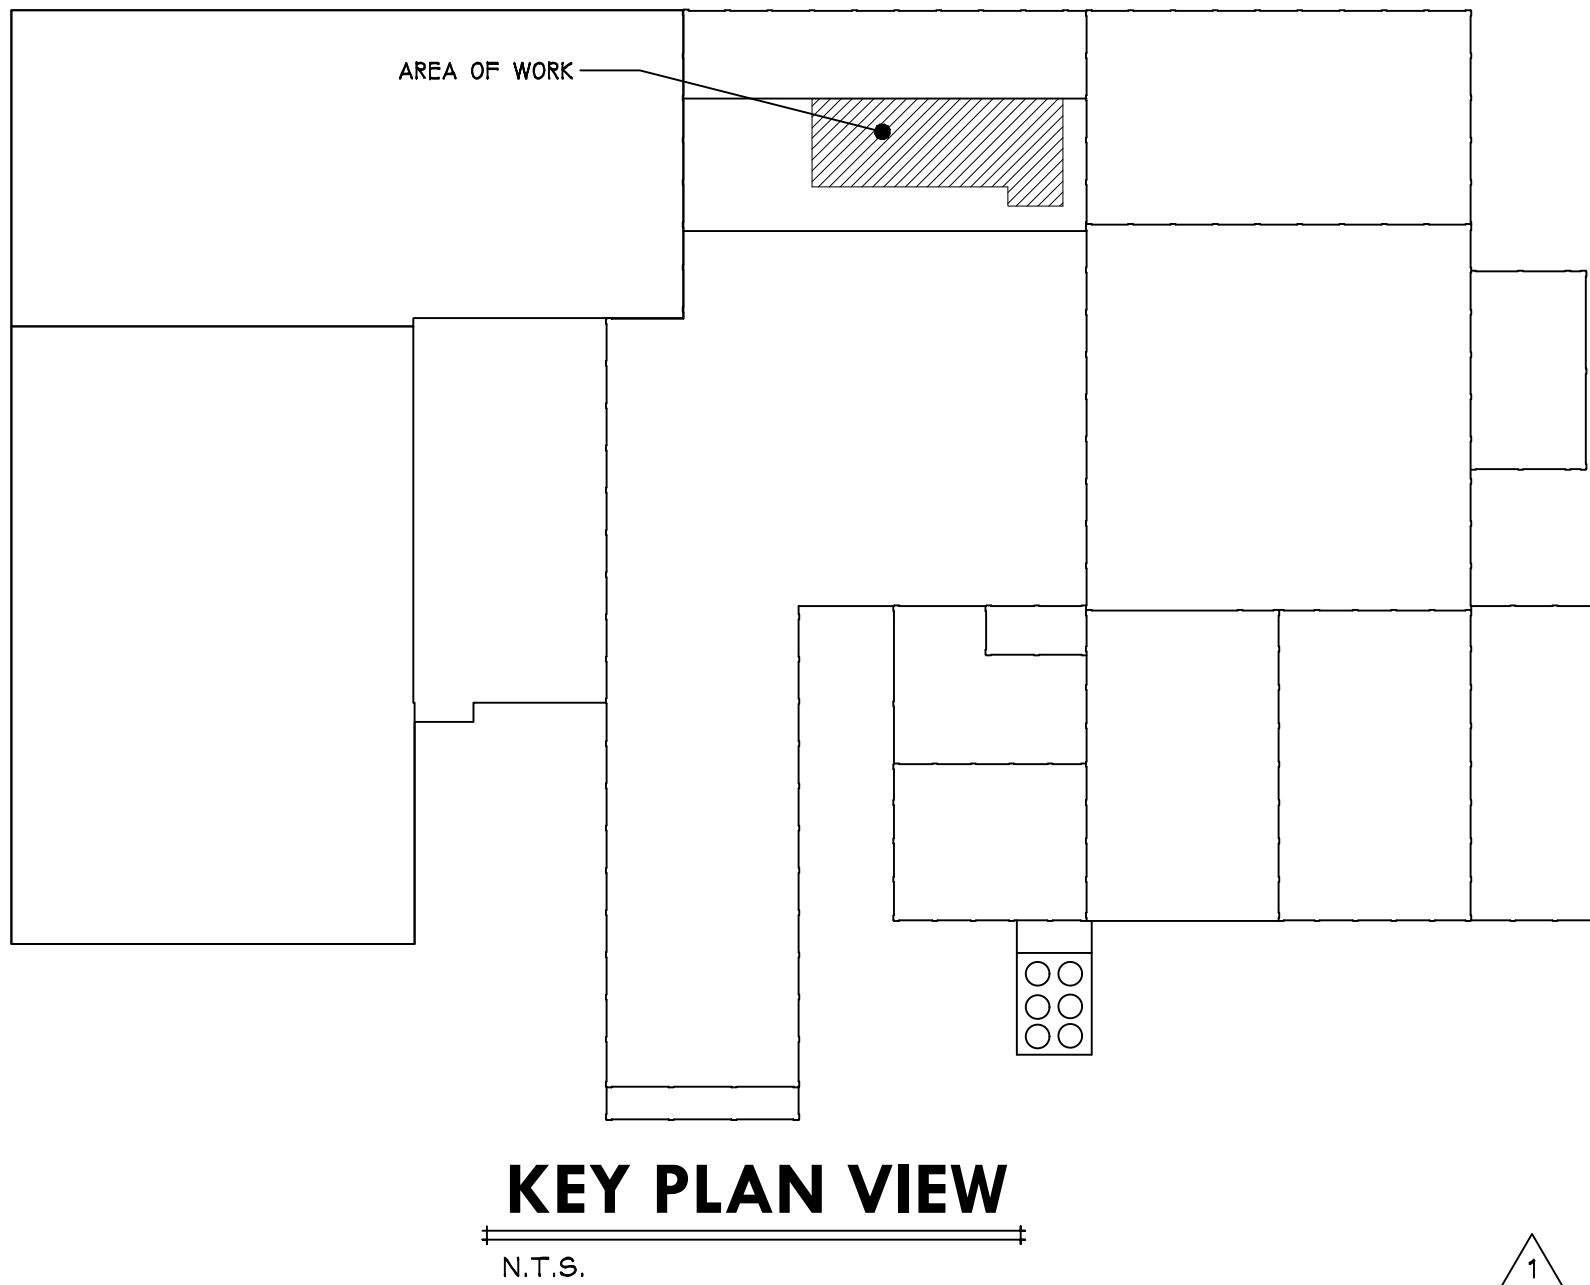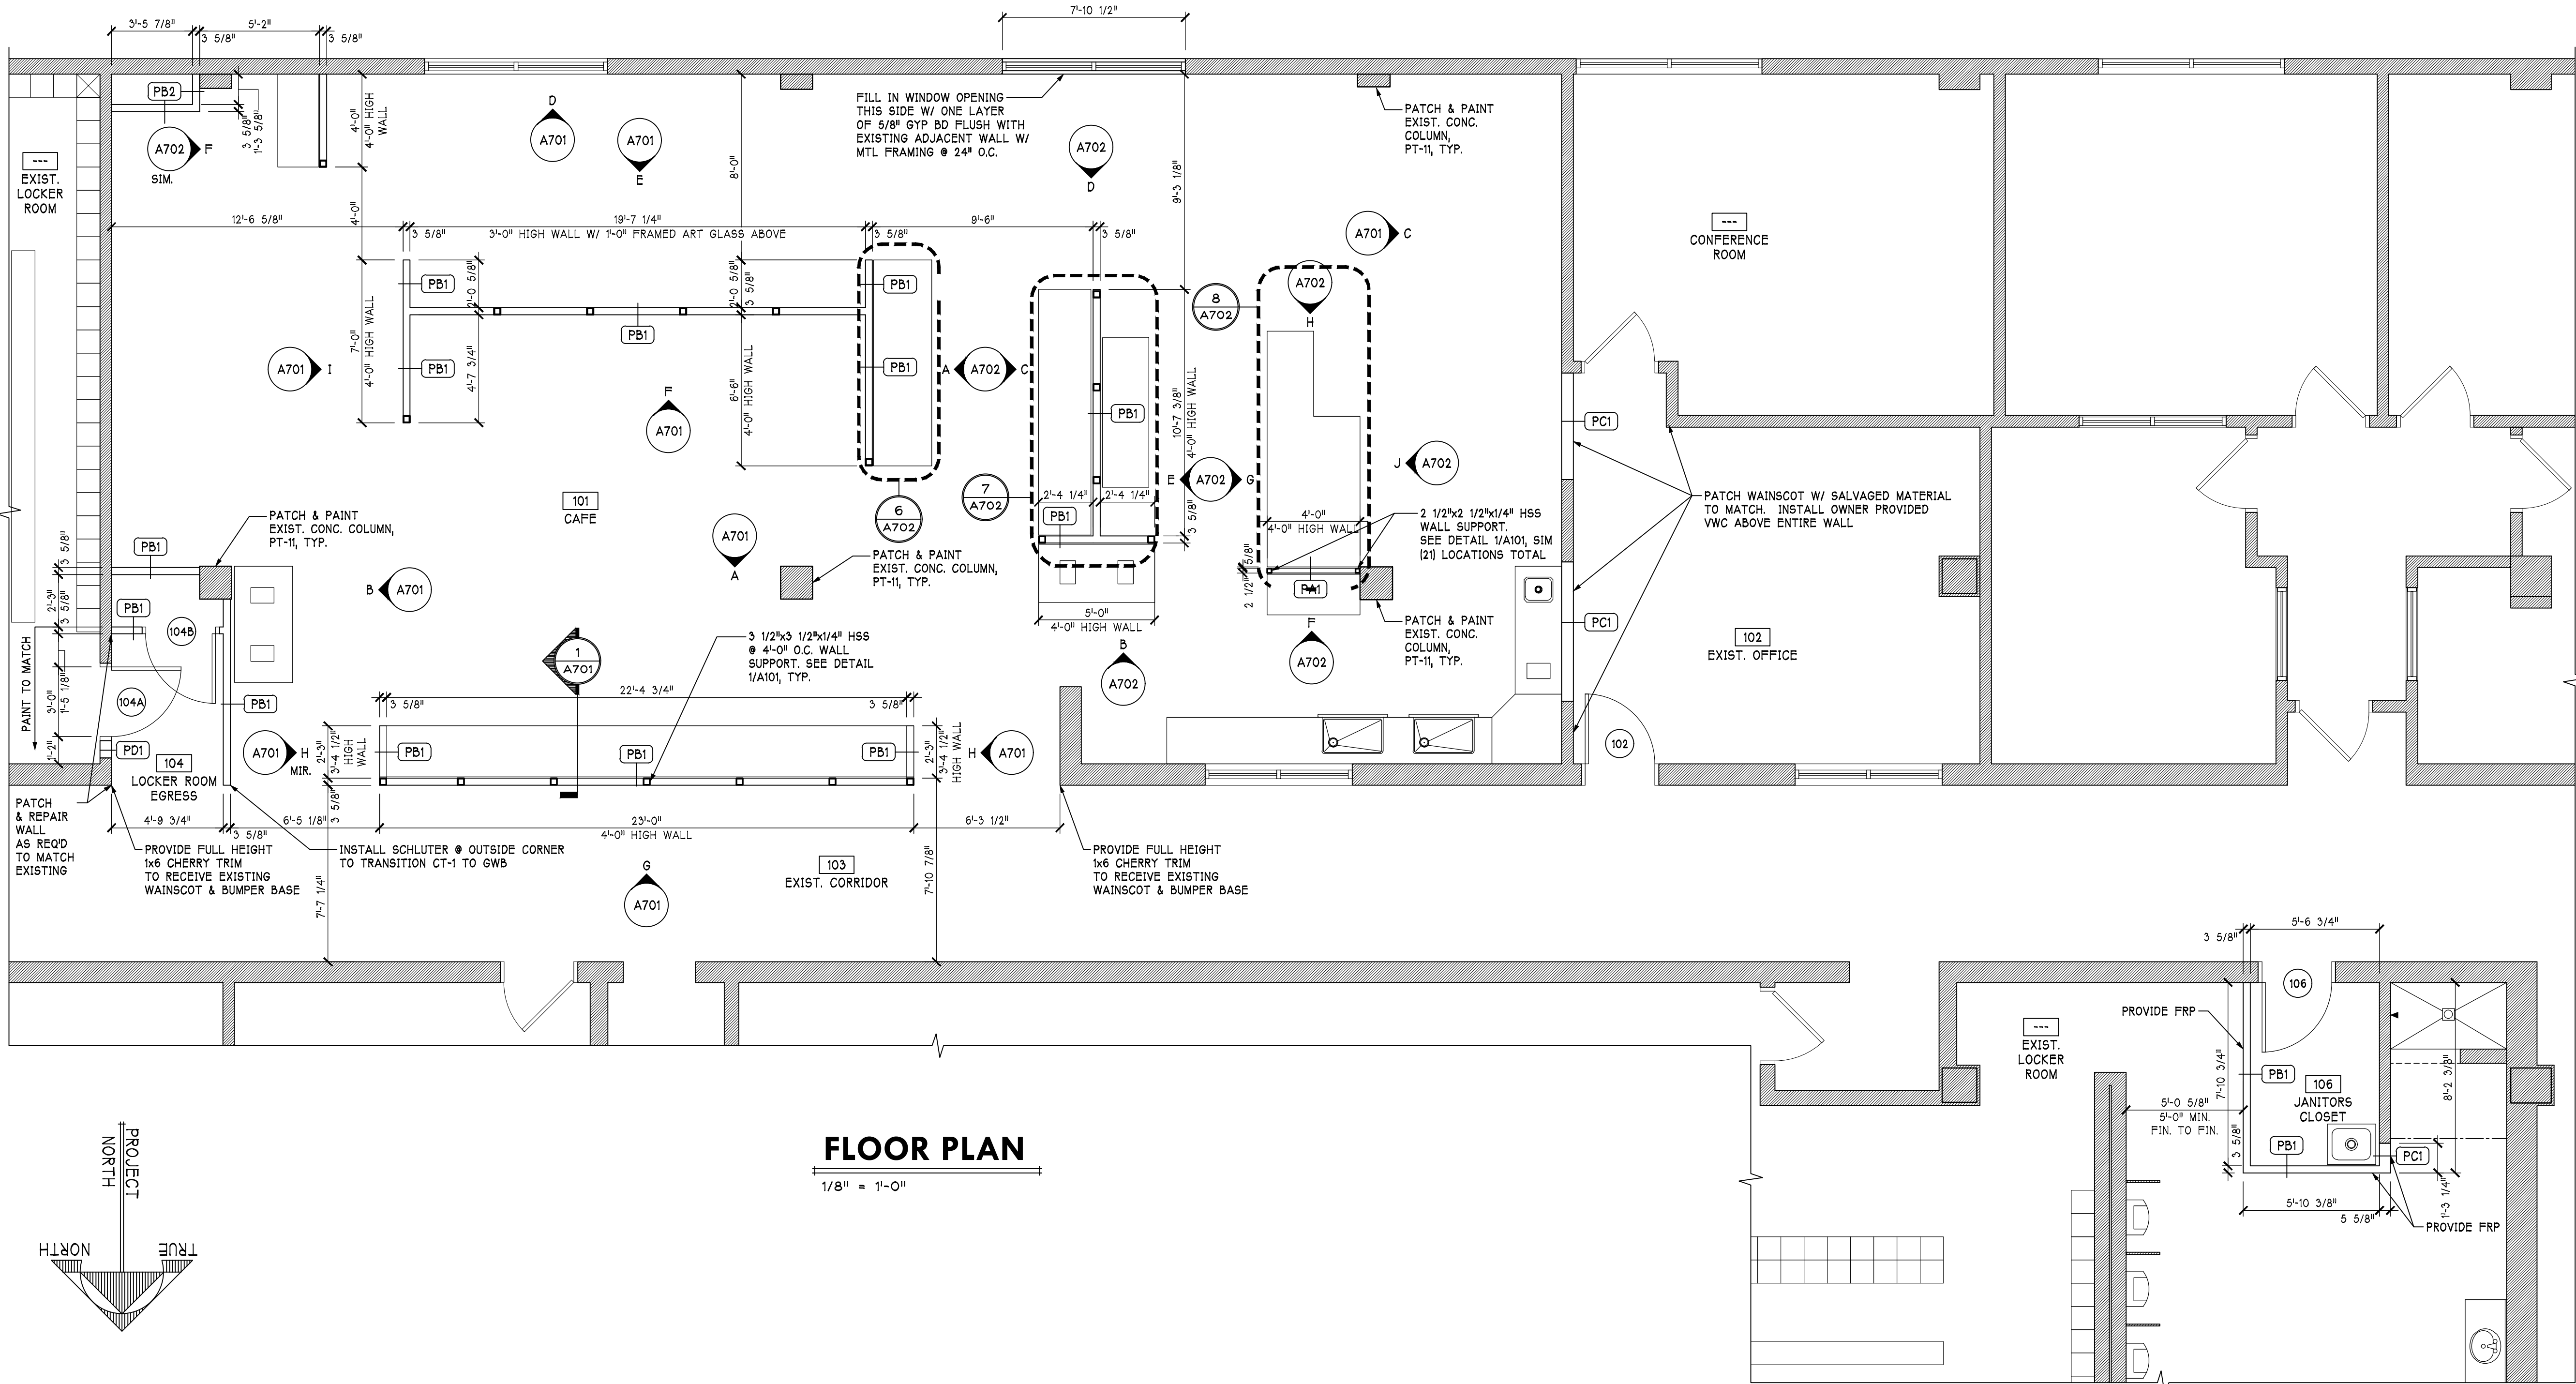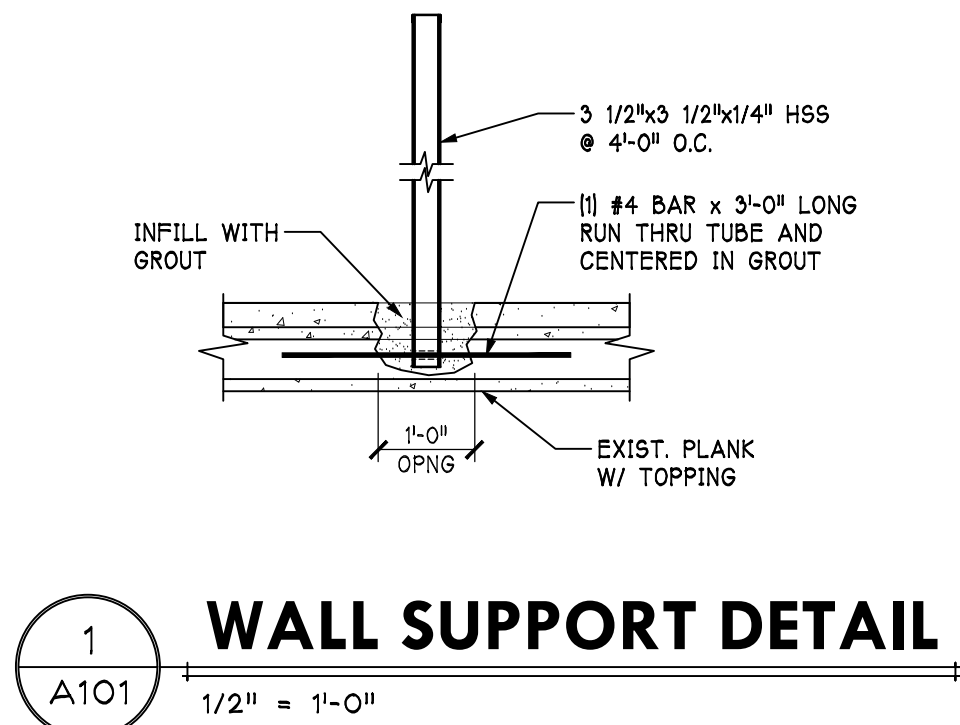

ARCHITECTURAL GENERAL NOTES:

EACH CONTRACTOR SHALL VERIFY AND COORDINATE ALL DIMENSIONS TOLERANCES, CONSTRUCTION CONDITIONS, ETC. AND REPORT ANY DISCREPANCIES TO THE ARCHITECT PRIOR TO THE COMMENCEMENT OF ANY WORK.

ALL DIMENSIONS GIVEN TO FACE OF FRAMING, FACE OF MASONRY, CENTERLINE OF STEEL, CENTERLINE OF DOORS, OR CENTERLINE OF WINDOWS UNLESS NOTED OTHERWISE.

THIS BUILDING AND ALL SITE WORK PERTAINING TO IT IS TO BE CONSTRUCTED IN STRICT ACCORDANCE WITH THE 2009 ANSI A117.1 AND THE 2010 AMERICANS WITH DISABILITIES ACT (ADA).

WITHIN FRAME CONSTRUCTION, ALL NEW DOOR LOCATIONS SHOWN ON DRAWINGS ARE SET 4" FROM FACE OF WALL FRAMING TO BACK OF DOOR JAMB UNLESS OTHERWISE NOTED.

WITHIN MASONRY CONSTRUCTION, ALL NEW DOOR LOCATIONS SHOWN ON DRAWINGS ARE SET 8" FROM FACE OF MASONRY TO BACK OF DOOR JAMB UNLESS OTHERWISE NOTED.

PROVIDE FIRE EXTINGUISHERS AS SHOWN ON THE DRAWINGS. FIRE EXTINGUISHERS TO BE MOUNTED 36" TO THE TOP OF THE EXTINGUISHER.

ALL FIRE RATED WALLS, FLOORS & ROOF TO BE FIRE STOPPED WITH UL APPROVED FIRE STOP ASSEMBLIES. SEE SPECIFICATIONS.

SEE LARGE SCALE UNIT PLANS FOR WINDOW LOCATION DIMENSIONS.

ALL 7 5/8" WALLS ARE 8" CMU.

ALL 11 5/8" WALLS ARE 12" CMU.

VERIFY AND COORDINATE NEW CONSTRUCTION F.F. ELEVATION WITH EXISTING BUILDING F.F. ELEVATION.

MAINTAIN BUILDING IN A WEATHER TIGHT CONDITION AT ALL TIMES DURING CONSTRUCTION.

TAKE ALL PRECAUTIONS NECESSARY TO MAINTAIN SECURITY OF THE OWNERS NORMAL OPERATIONS DURING CONSTRUCTION.

ALL PATCH AND REPAIR WORK SHALL BE PERFORMED IN A WORKMAN-LIKE MANNER BY EXPERIENCED TRADESMEN. SURFACE TEXTURE AND FINISH TO MATCH EXISTING ADJOINING CONDITION.

VERIFY FINAL DIMENSIONS W/ ARCHITECT FOR COORDINATION W/ OWNER SUPPLIED FURNITURE.

PROGRESS PRINT NOT FOR CONSTRUCTION (09/20/18)

Job No: 1730
Drawn: WShoop
Checked:

Revisions:
No: 1 Date: 05/13/19
Revisions per Addendum No. 4

No: Date:

No: Date:

No: Date:

No: Date:

No: Date:

NEWCOMER ASSOCIATES
architecture + engineering

1105 Shiller Avenue Chambersburg, PA 17201 Tel: 717.263.7380 Fax: 717.263.1001 www.newcomerassoc.com

Martin's Famous Pastry Shoppe
Transportation Cafe

Chambersburg, Pennsylvania 17202


© 2018 Newcomer Associates, Inc.

Drawing Title:
FLOOR PLAN









Sheet No.
A101

Date: MM/DD/YY

- GENERAL NOTE:
1. ALL VERTICAL JOINTS WITHIN CERAMIC TILE MUST ALIGN VERTICALLY AS SHOWN PER ELEVATION.
2. ALL TILES TO BE BOND PATTERN, STAGGER 1/3 HORIZONTALLY AS SHOWN PER ELEVATION, TYP.
3. ALL OUTSIDE CT CORNERS/EXPOSED EDGES TO TERMINATE INTO SCHLUTER TRIM (OR EQUAL).
4. SCHLUTER MODEL: FOR OUTSIDE CORNER APPLICATIONS, SCHLUTER - QUADRO C 125 P (STAINLESS STEEL).
5. ALL EXPOSED SHELVEYS/BUILT-IN CUBBIES TO BE RABBETED INTO ADJACENT VERTICAL MATERIAL; ALL EXPOSED SURFACES TO BE CLAD W/ WOOD VENEER AND HARDWOOD EDGE BANDING, TYP.
6. ALL JUNCTION BOXES IN 'SEATING AREA' TO BE MOUNTED HORIZONTALLY AS SHOWN.
7. ALL S.S. COUNTERTOPS TO PROJECT 1 1/2" BEYOND FACE OF CABINET, TYP.
8. ALL S.S. CAPS TO PROJECT 3/4" BEYOND FACE OF FINISHED SURFACE (I.E., PAINTED GYPSUM BOARD, CT, ETC.).
9. ALL OUTSIDE GYPSUM WALL BOARD CORNERS TO BE CLAD W/ 1/2" X 1/2" STAINLESS STEEL CORNER GUARD, TYP. (FULL HEIGHT OF PARTITION).
10. SEE ELEC. DRAWING FOR ADDITIONAL ELECTRICAL OUTLET LOCATIONS, TYP.
11. ALL ABOVE COUNTER RECEPTACLES IN CT-5 TO BE VERTICAL & CENTERED ON EQUIPMENT PER ABOI W/ BOTTOM OF BOX @ 40" AFF., TYP.

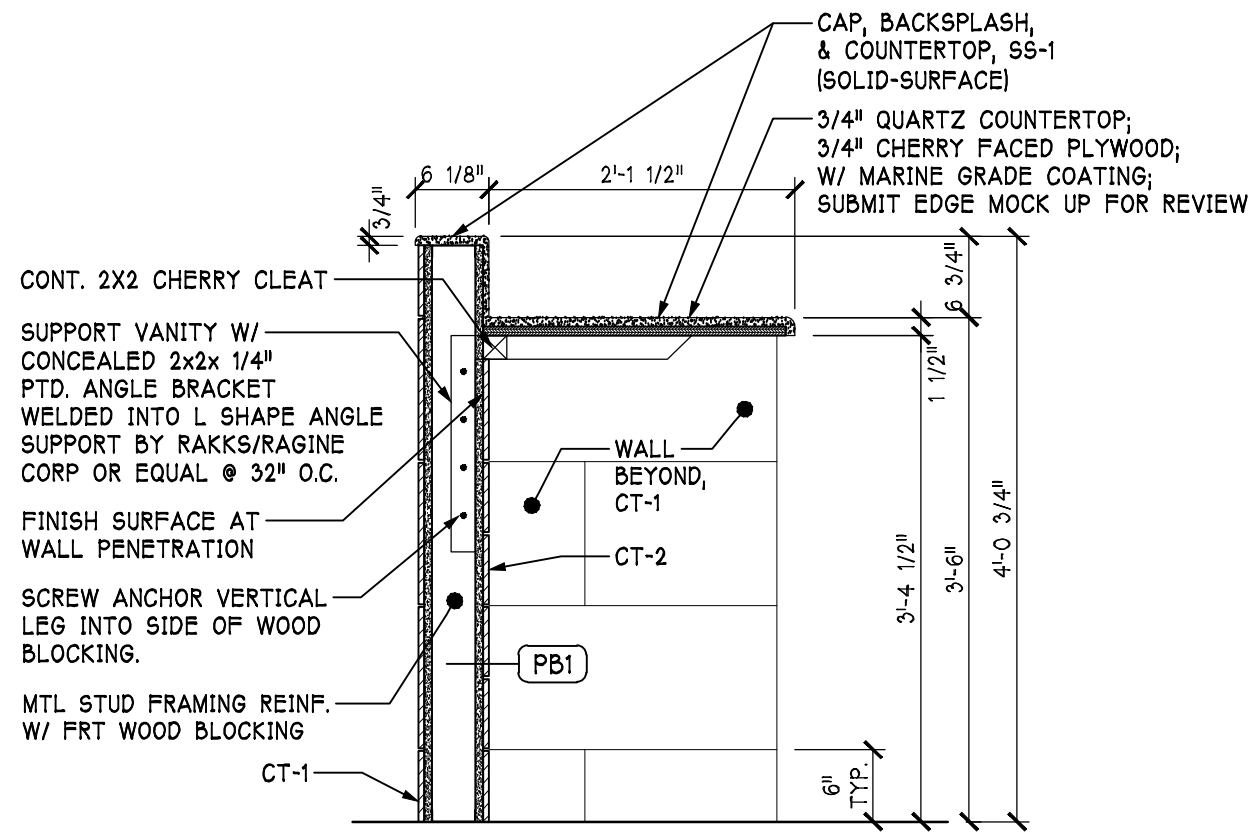

1 PERCH COUNTER DETAIL
A701
3/4" = 1'-0"

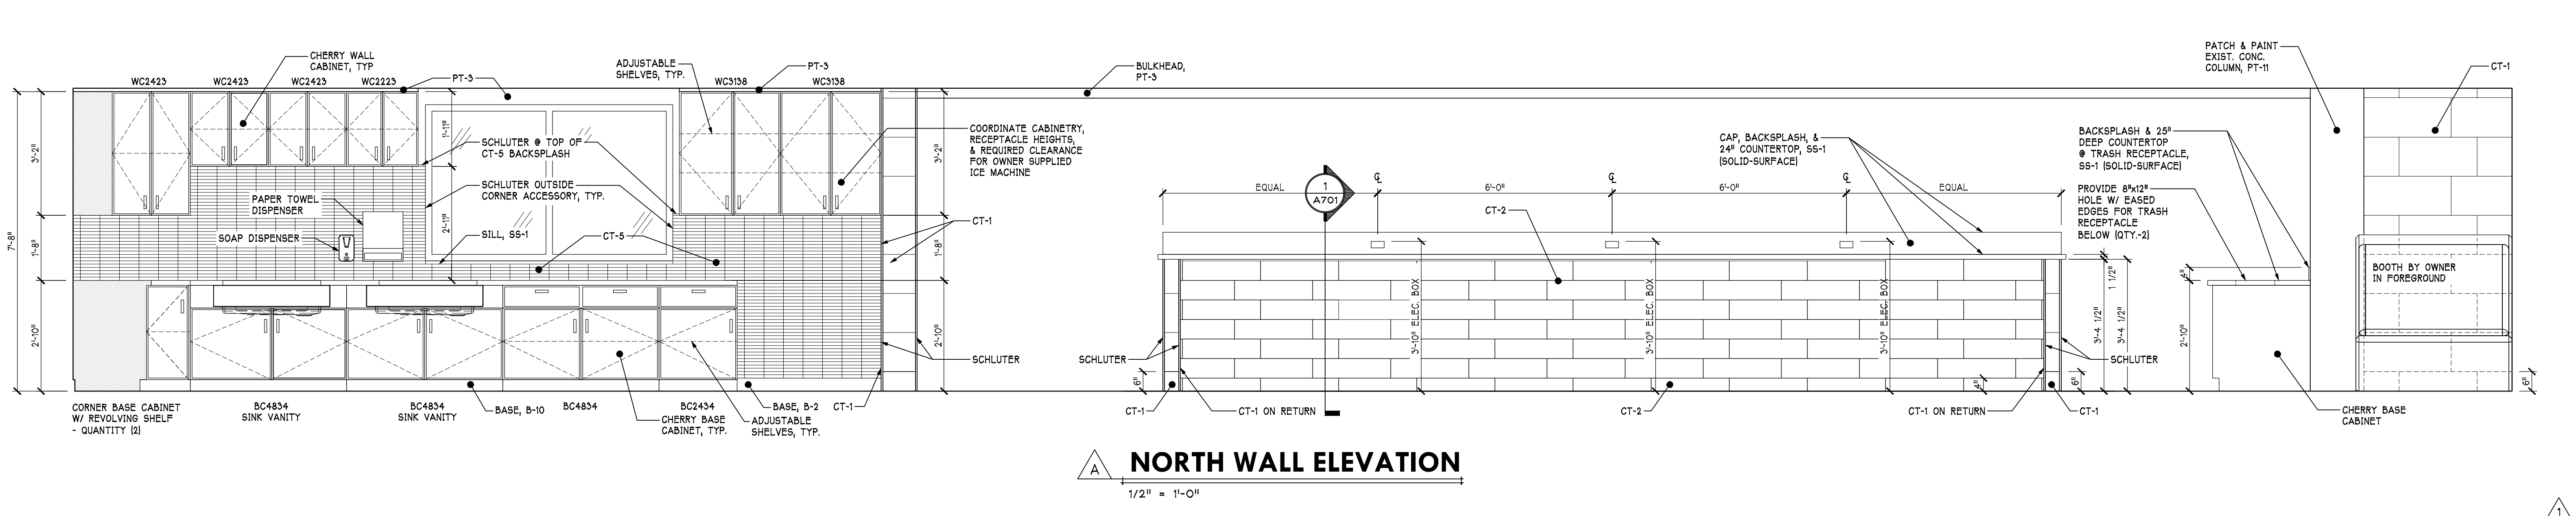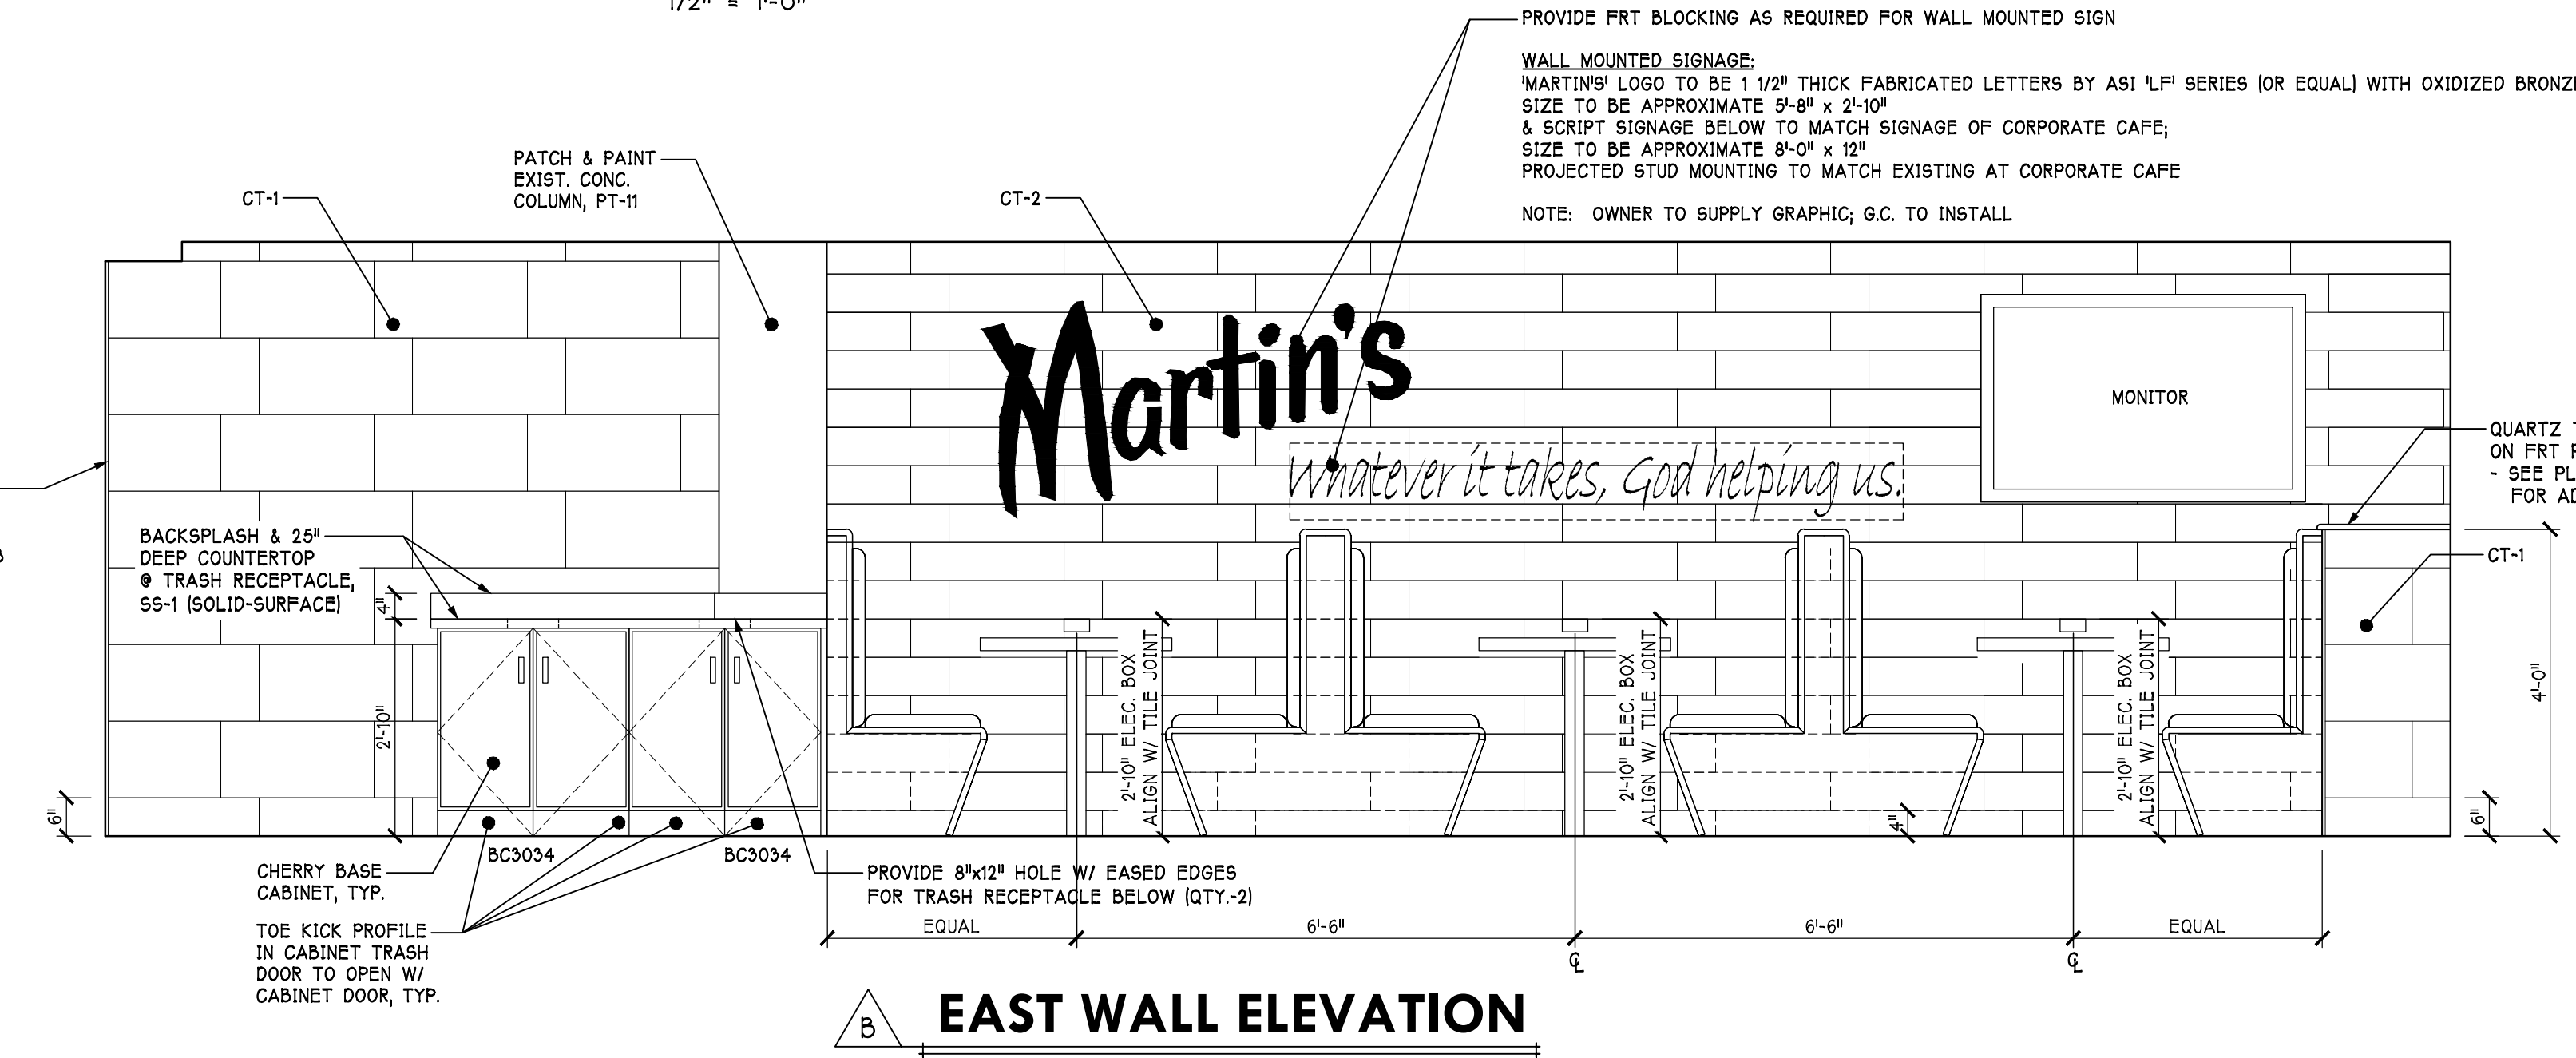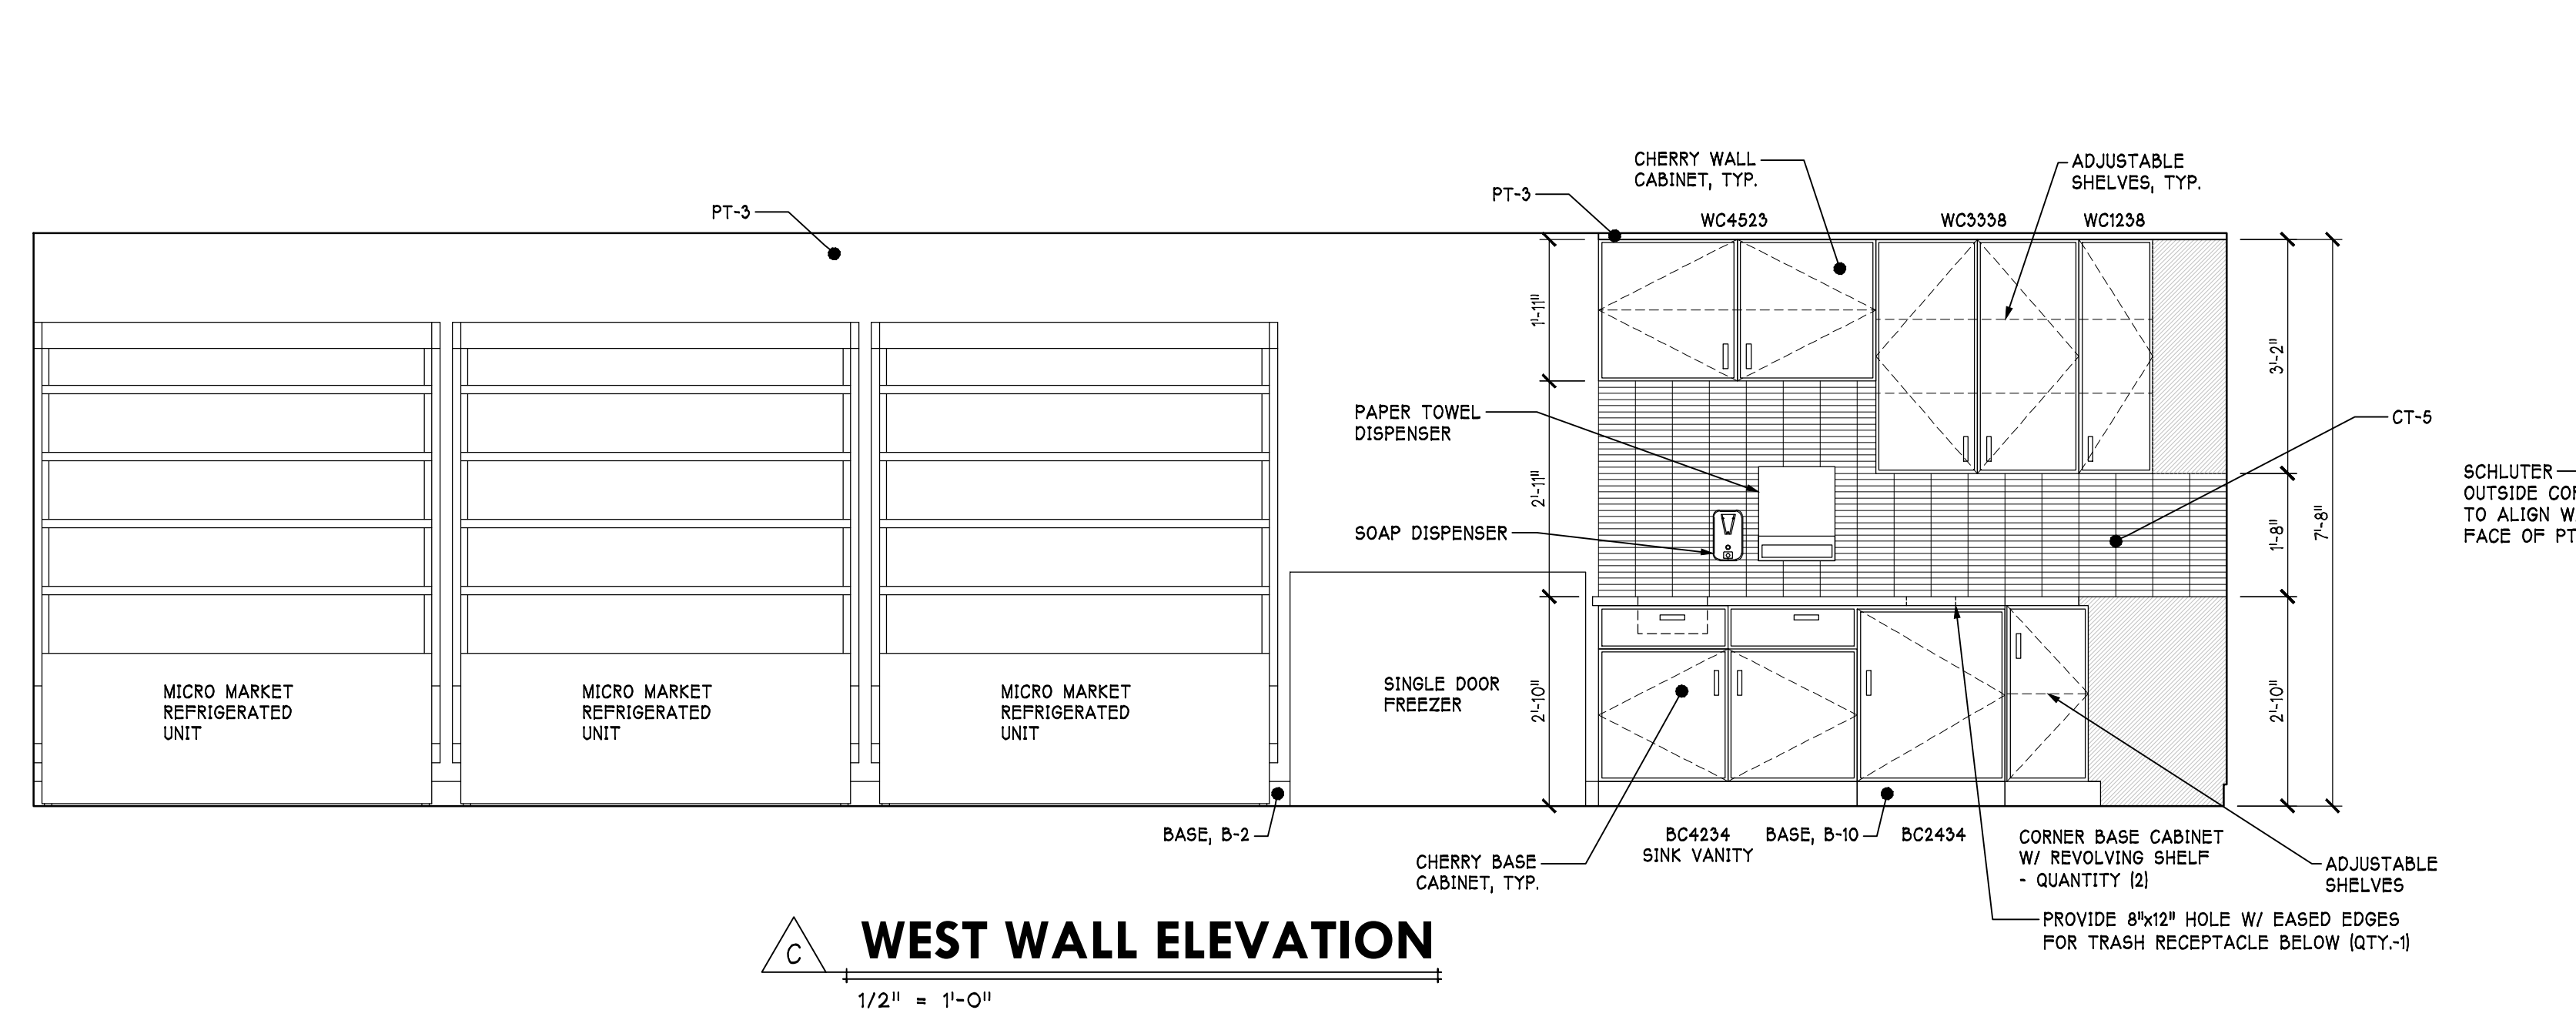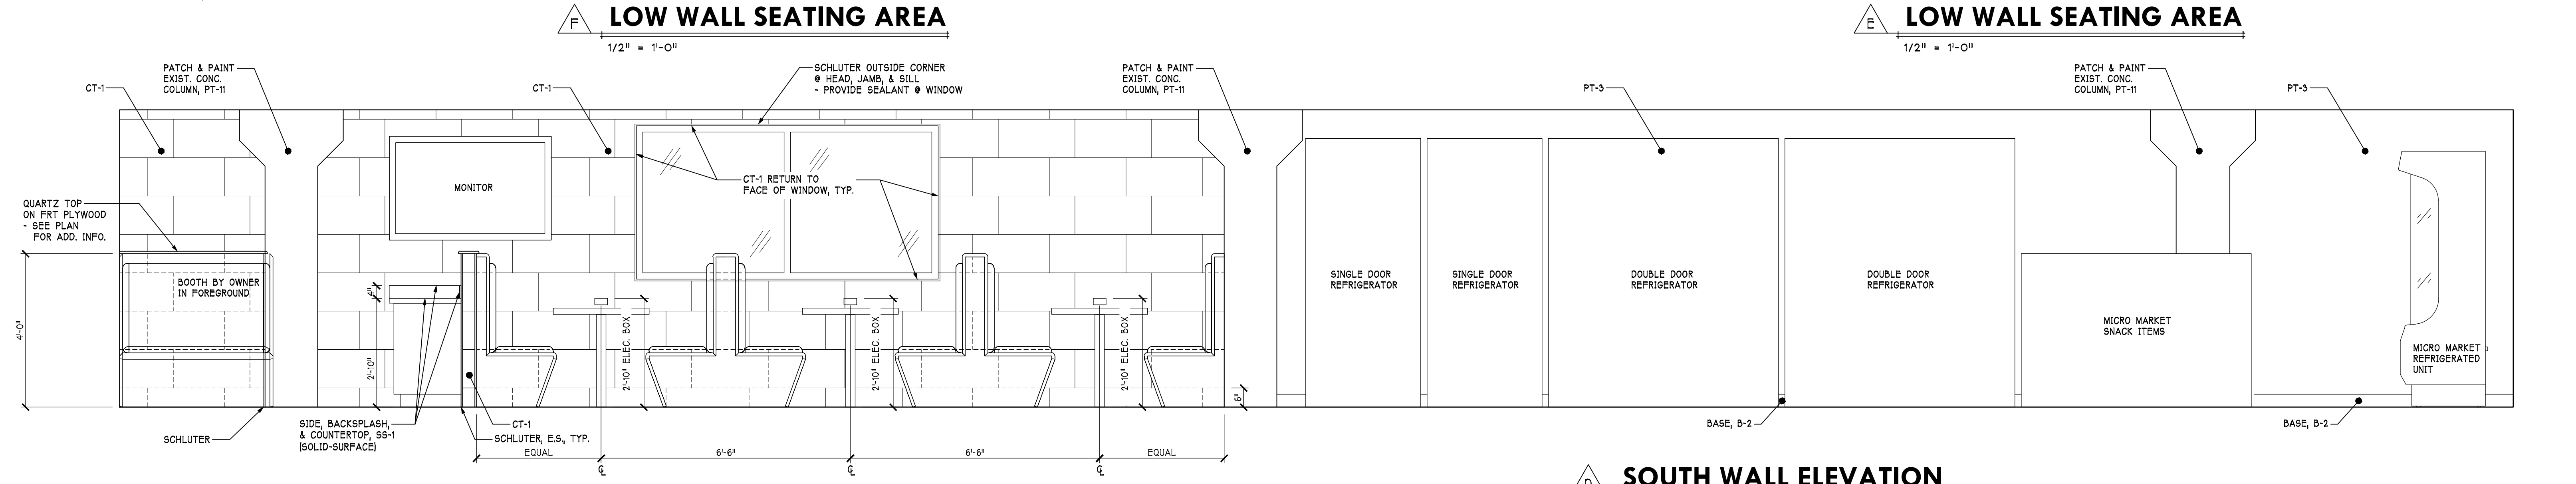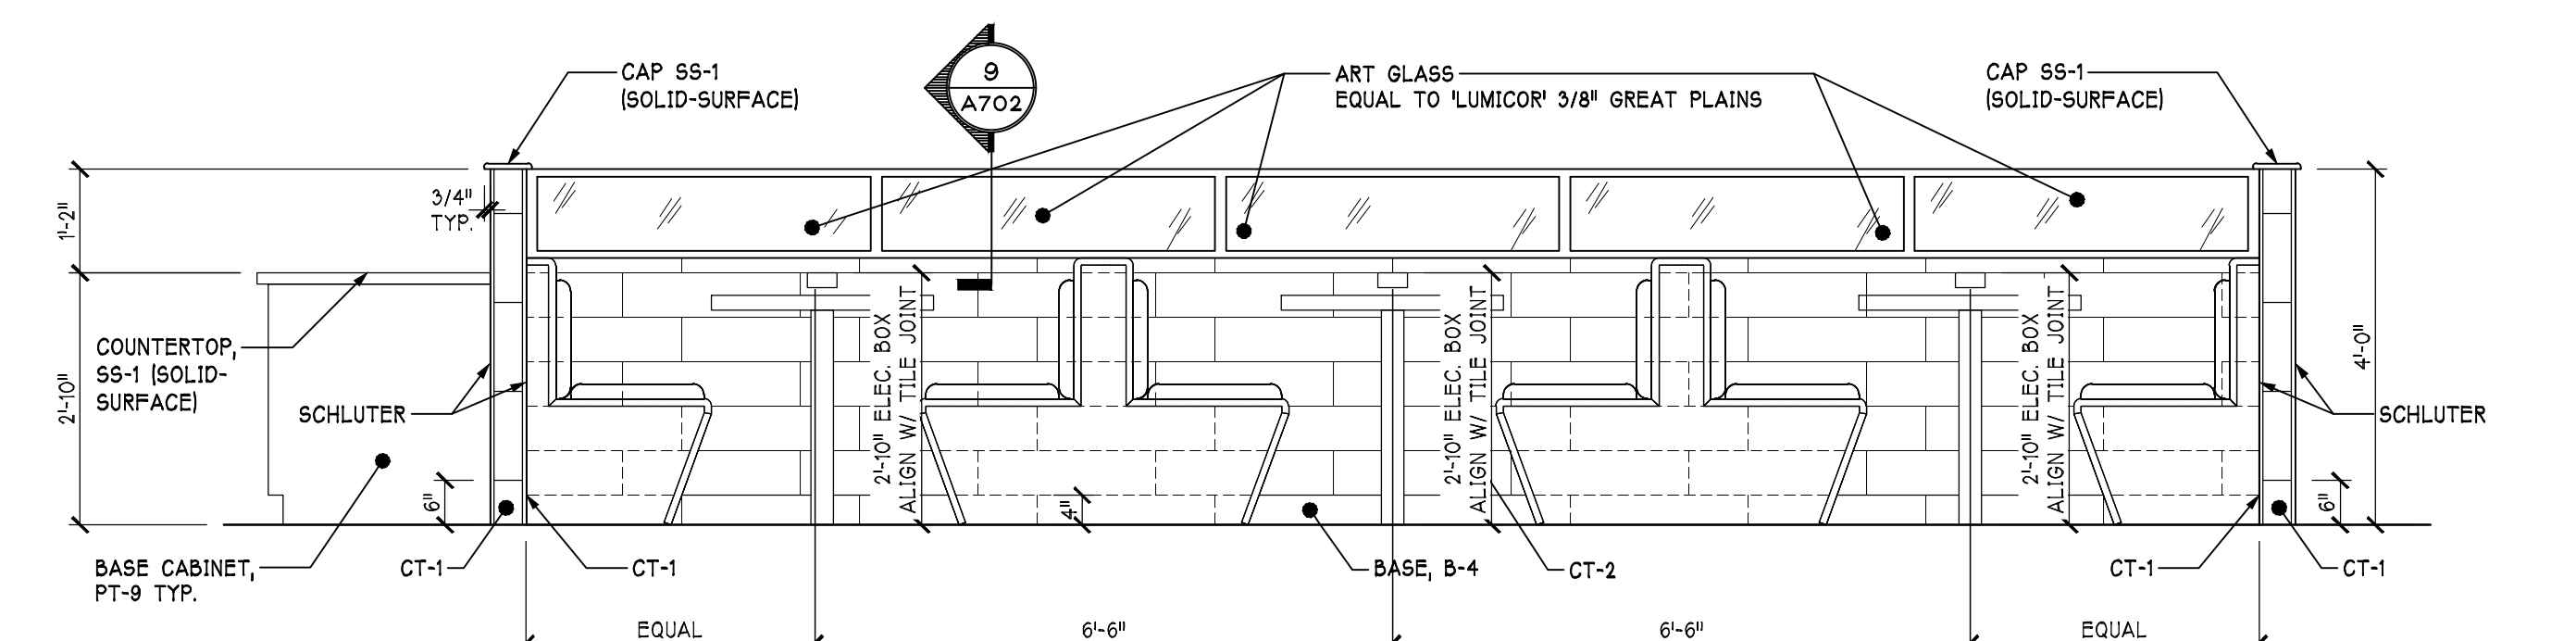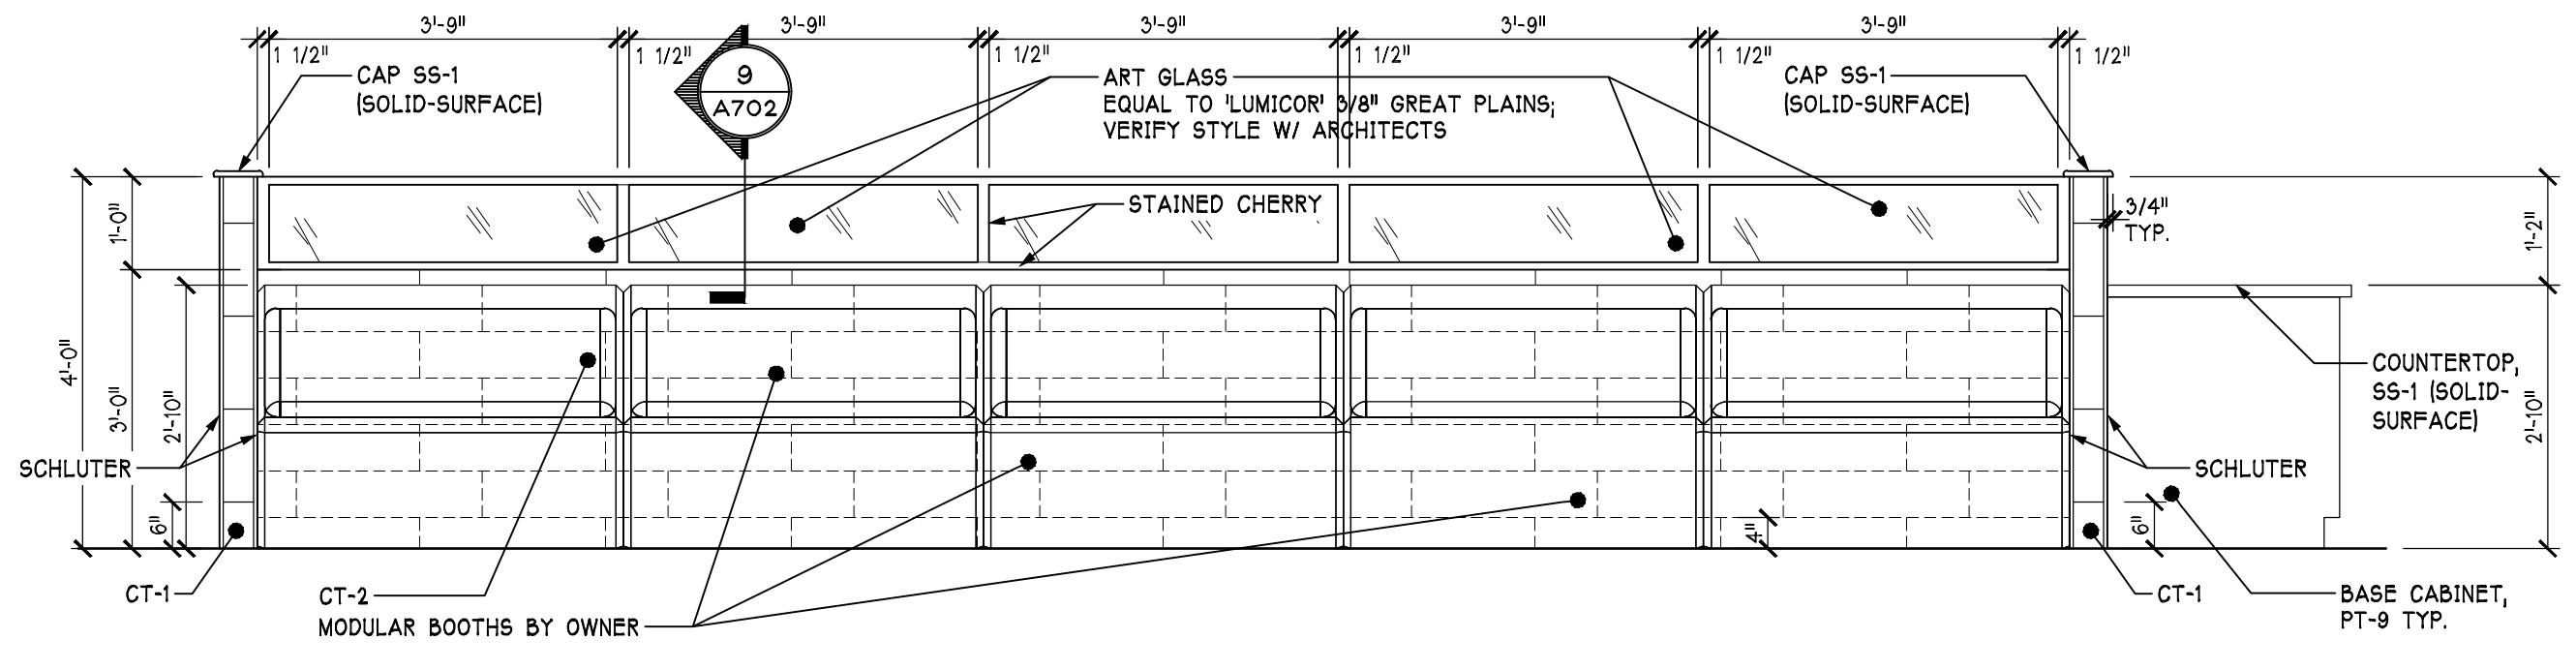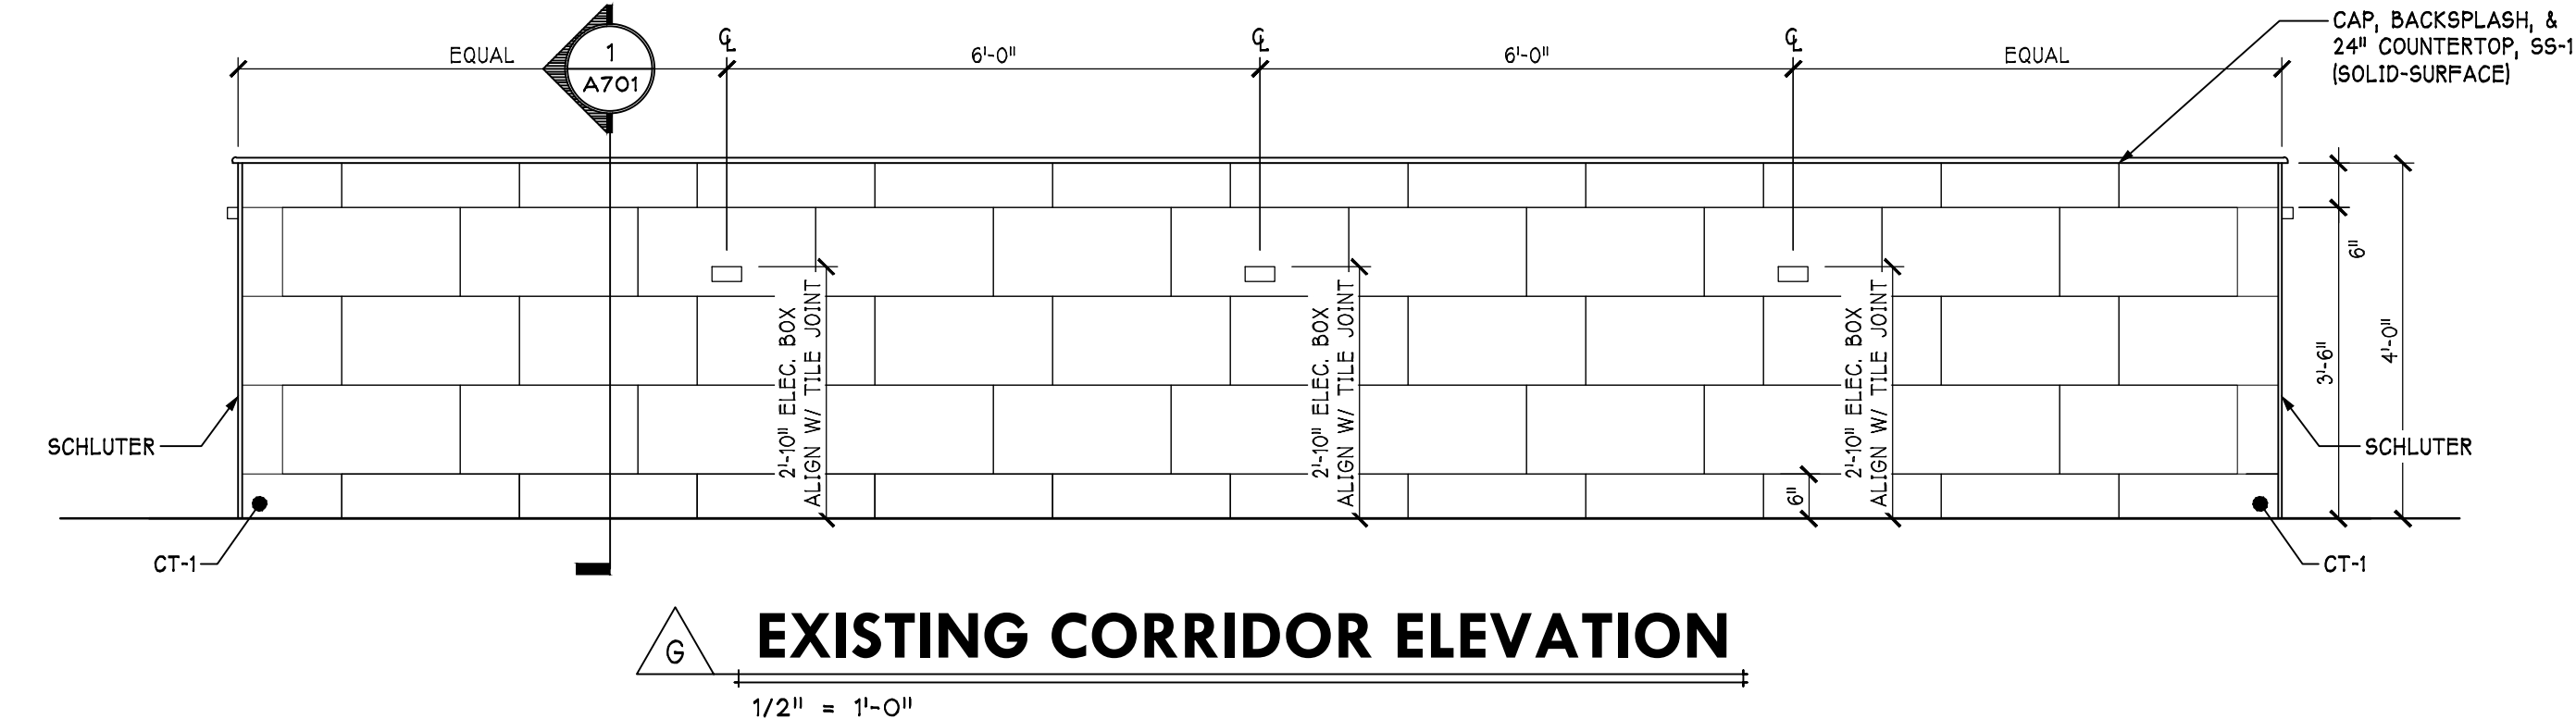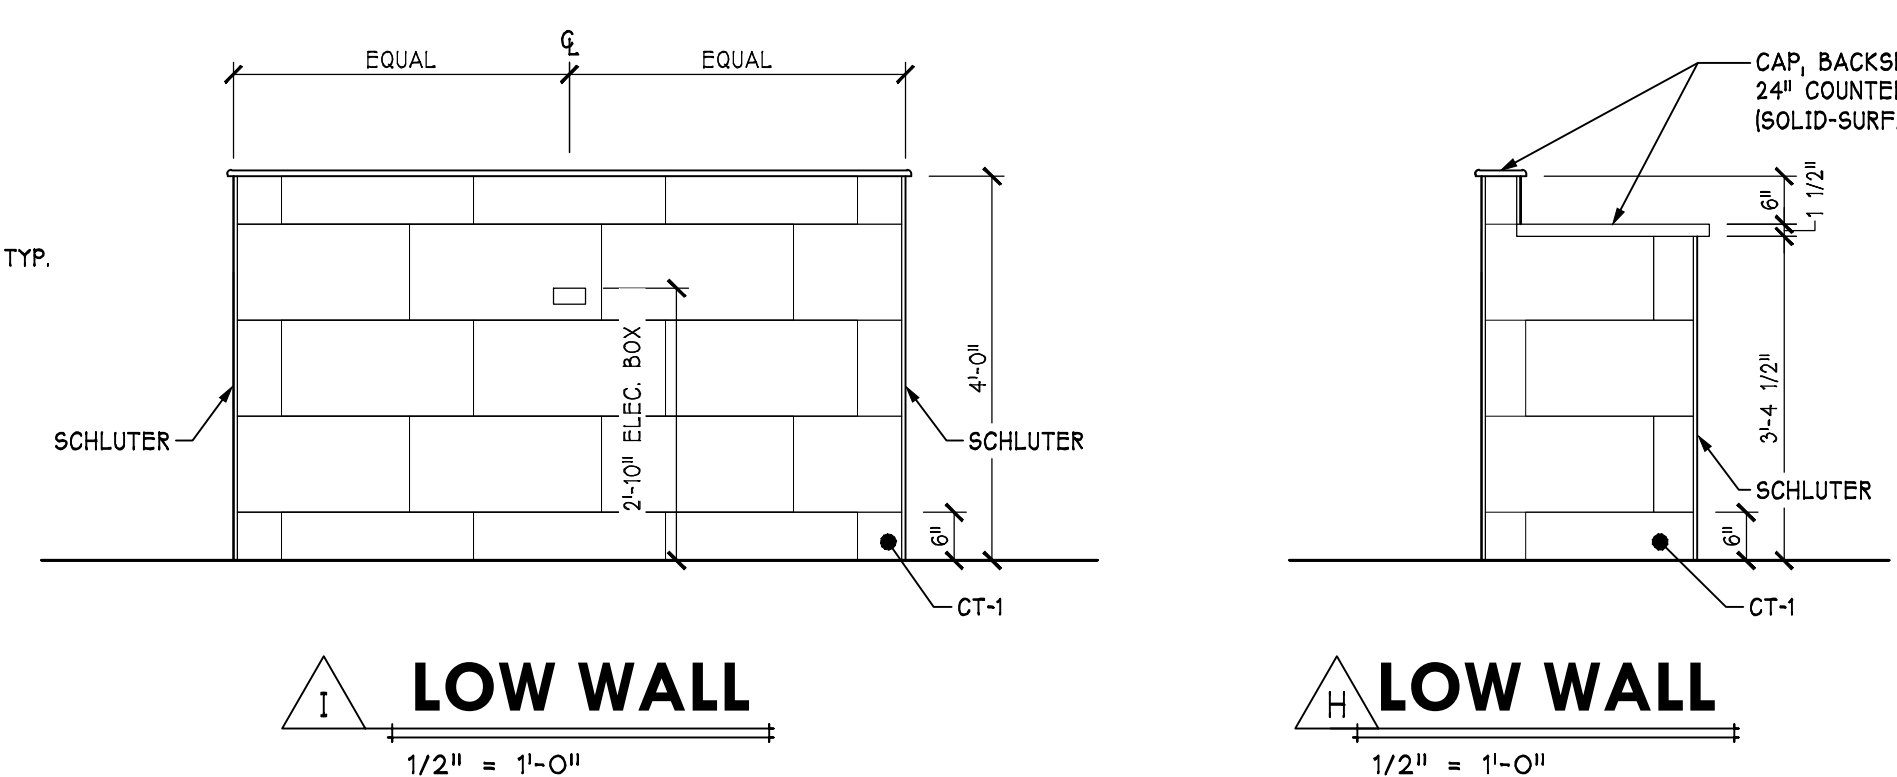

Job No: 1730
Drawn: WShoop
Checked:

Revisions:

No:	1	Date:	05/13/19
Revisions per Addendum No. 4			
No:		Date:	
No:		Date:	
No:		Date:	
No:		Date:	
No:		Date:	
No:		Date:	

NEWCOMER ASSOCIATES
architecture + engineering

1105 Shiller Avenue Chambersburg, PA 17201 Tel: 717 263 1001 Fax: 717 263 7388 www.newcomerassociates.com


Martin's Famous Pastry Shoppe
Transportation Cafe

Drawing Title:
INTERIOR
ELEVATIONS


Sheet No.
A701
Date: MM/DD/YY

PROGRESS PRINT NOT FOR CONSTRUCTION (09/20/18)


Revisions:	
No: 1	Date: 05/13/19
Revisions per Addendum No. 4	
No:	Date:
No:	Date:
No:	Date:
No:	Date:
No:	Date:
No:	Date:

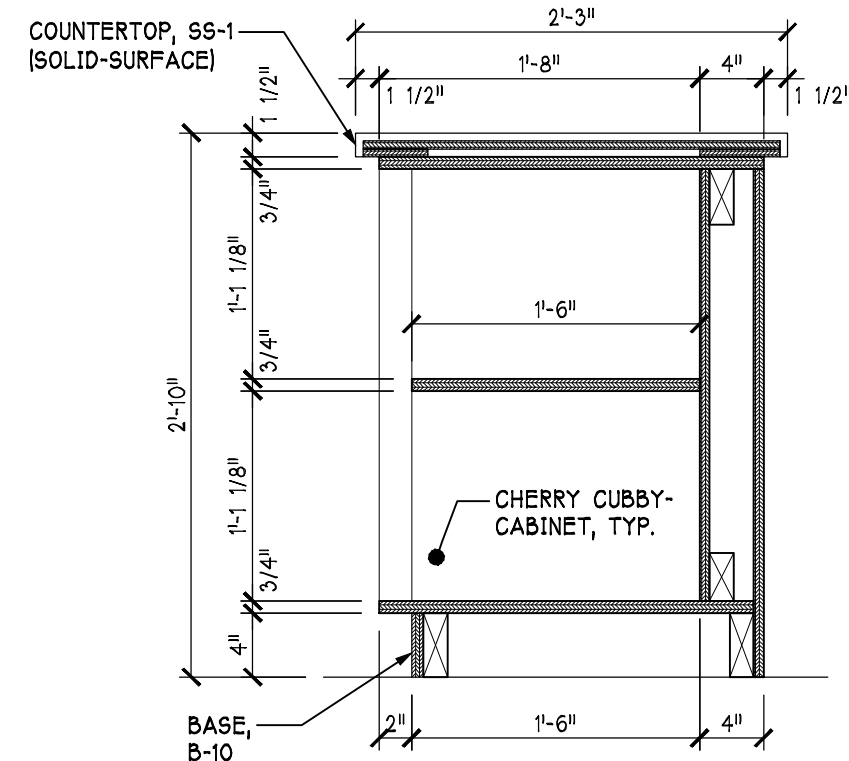


5 CUBBY-CABINET SECTION
1" = 1'-0"

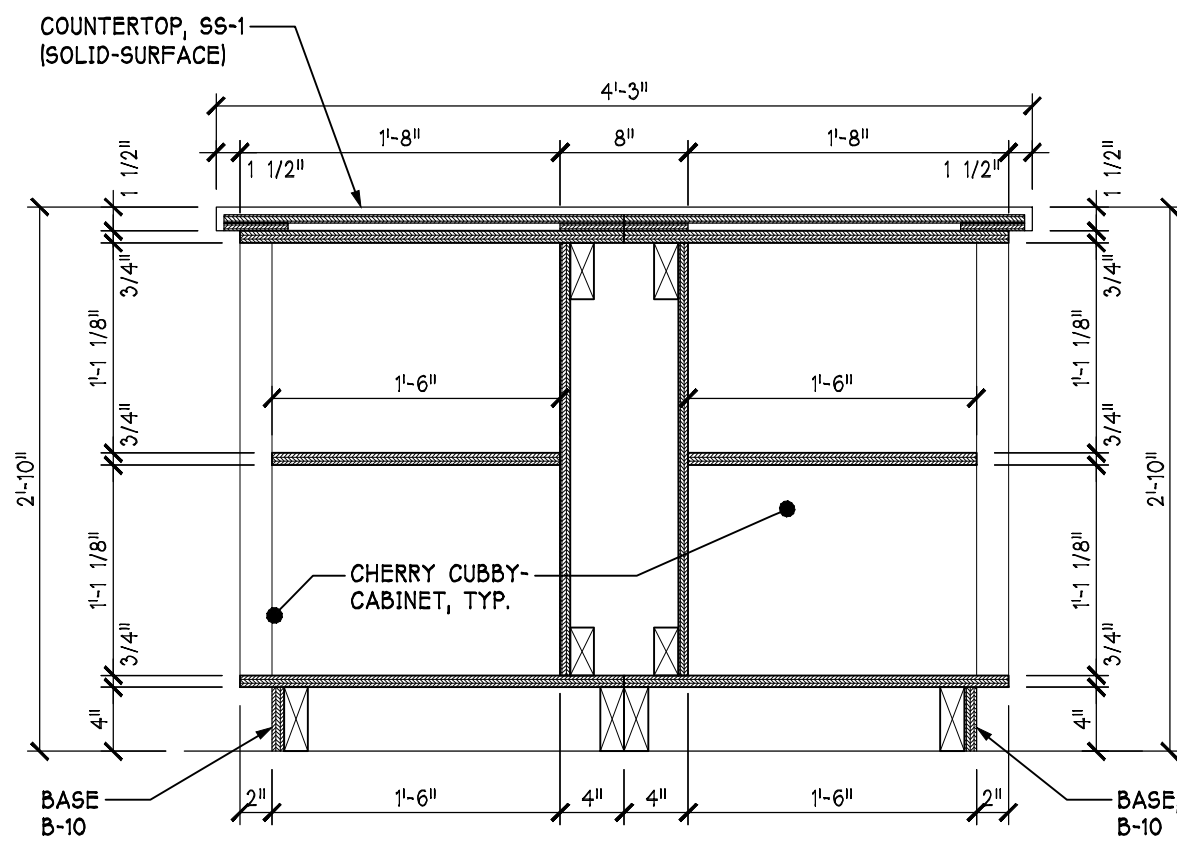


4 CUBBY-CABINET SECTION
1" = 1'-0"

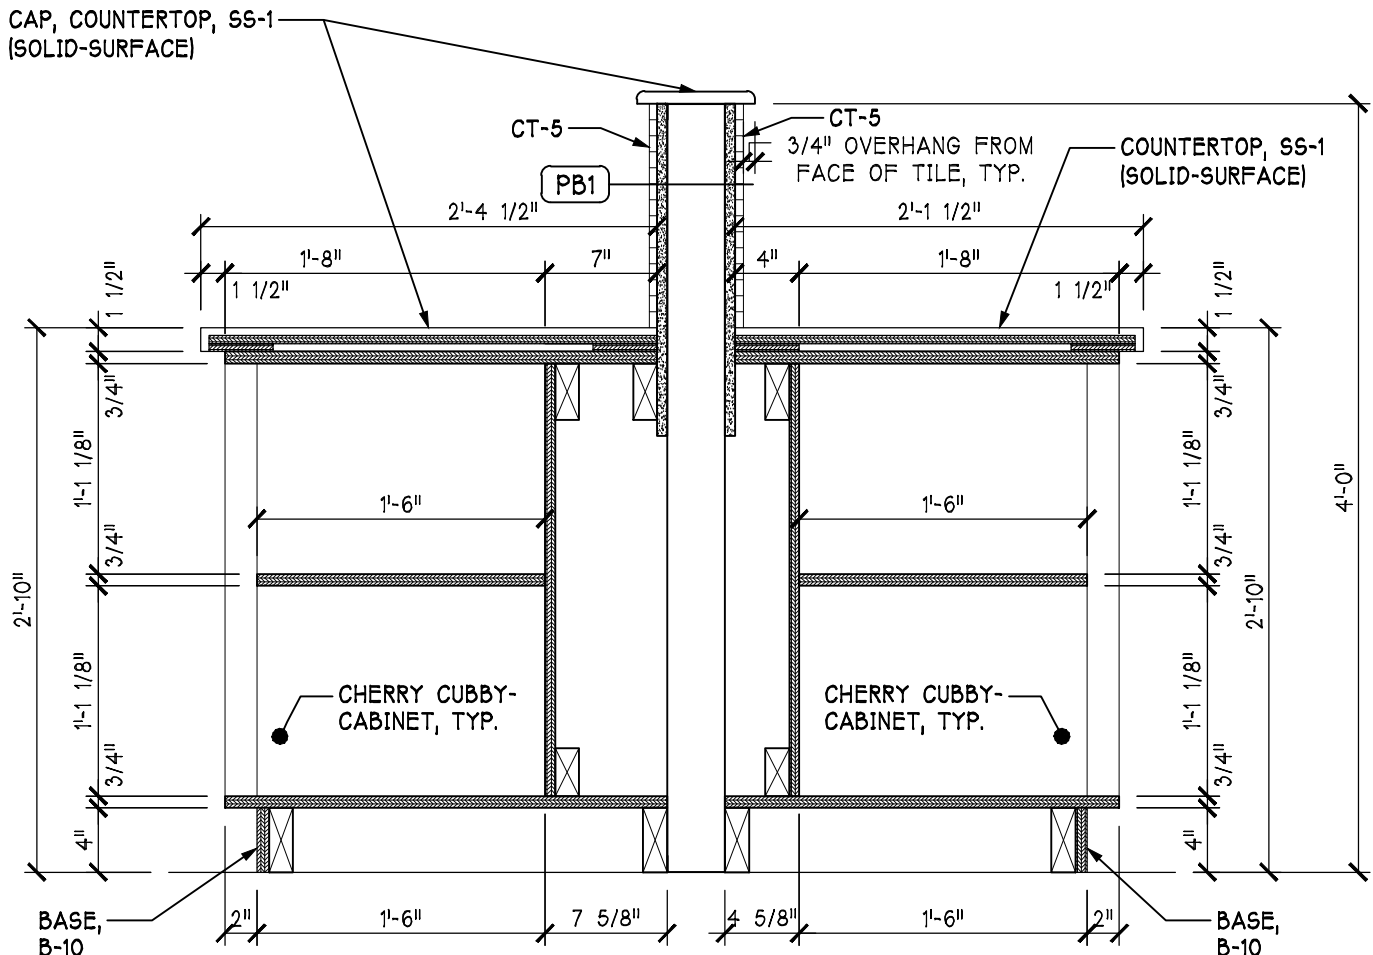


3 CUBBY-CABINET SECTION
1" = 1'-0"

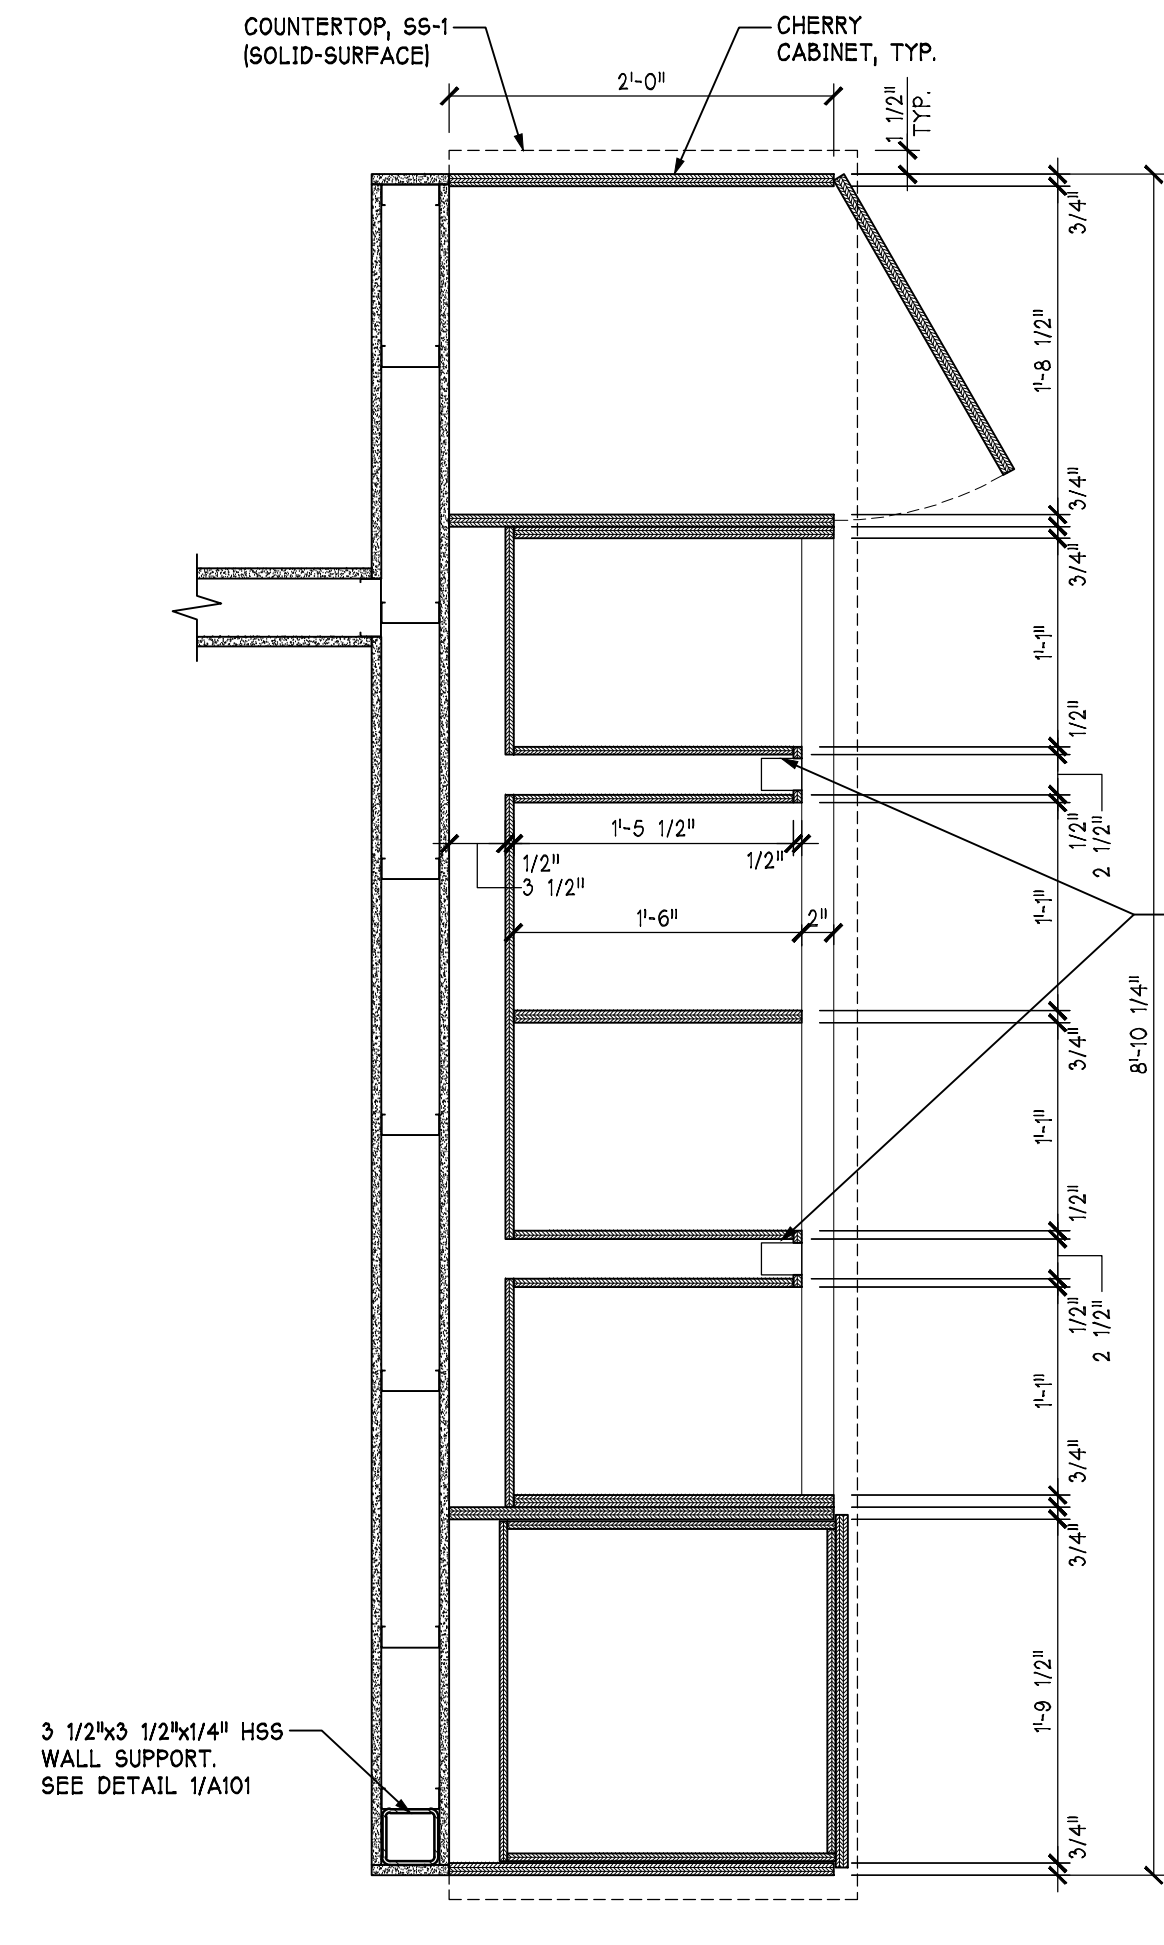


6 CUBBY-CABINET ENLARGED PL.
1" = 1'-0"

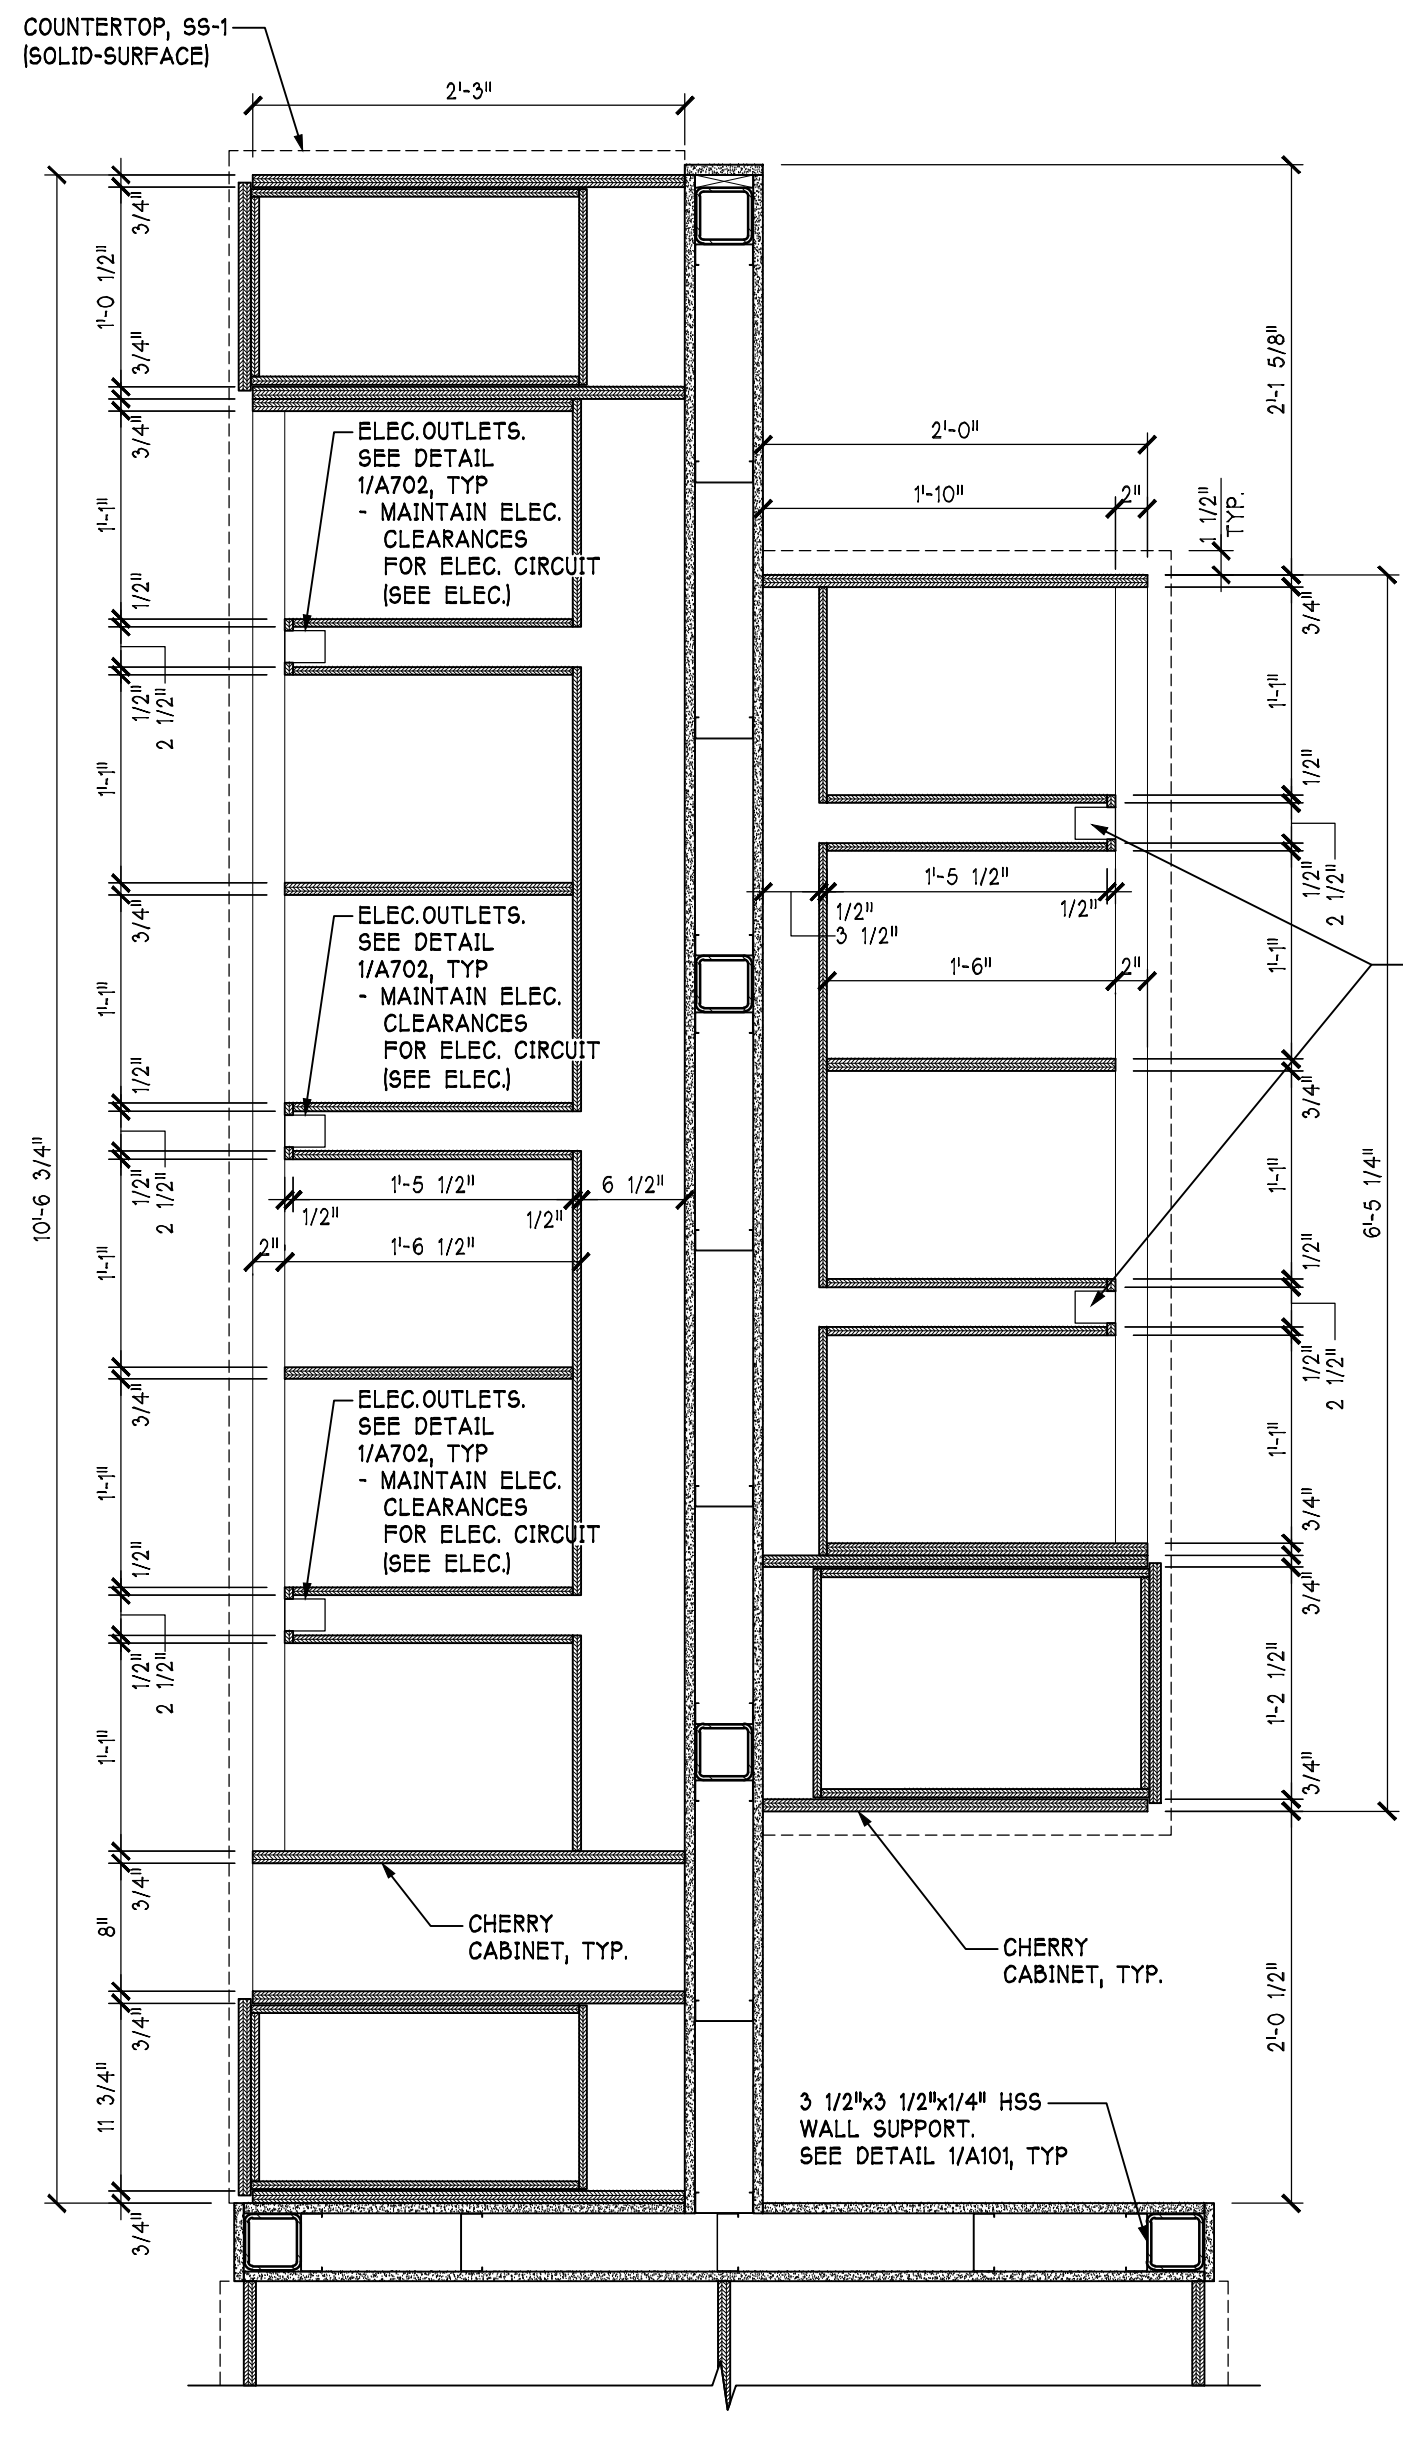


7 CUBBY-CABINET ENLARGED PLAN
1" = 1'-0"

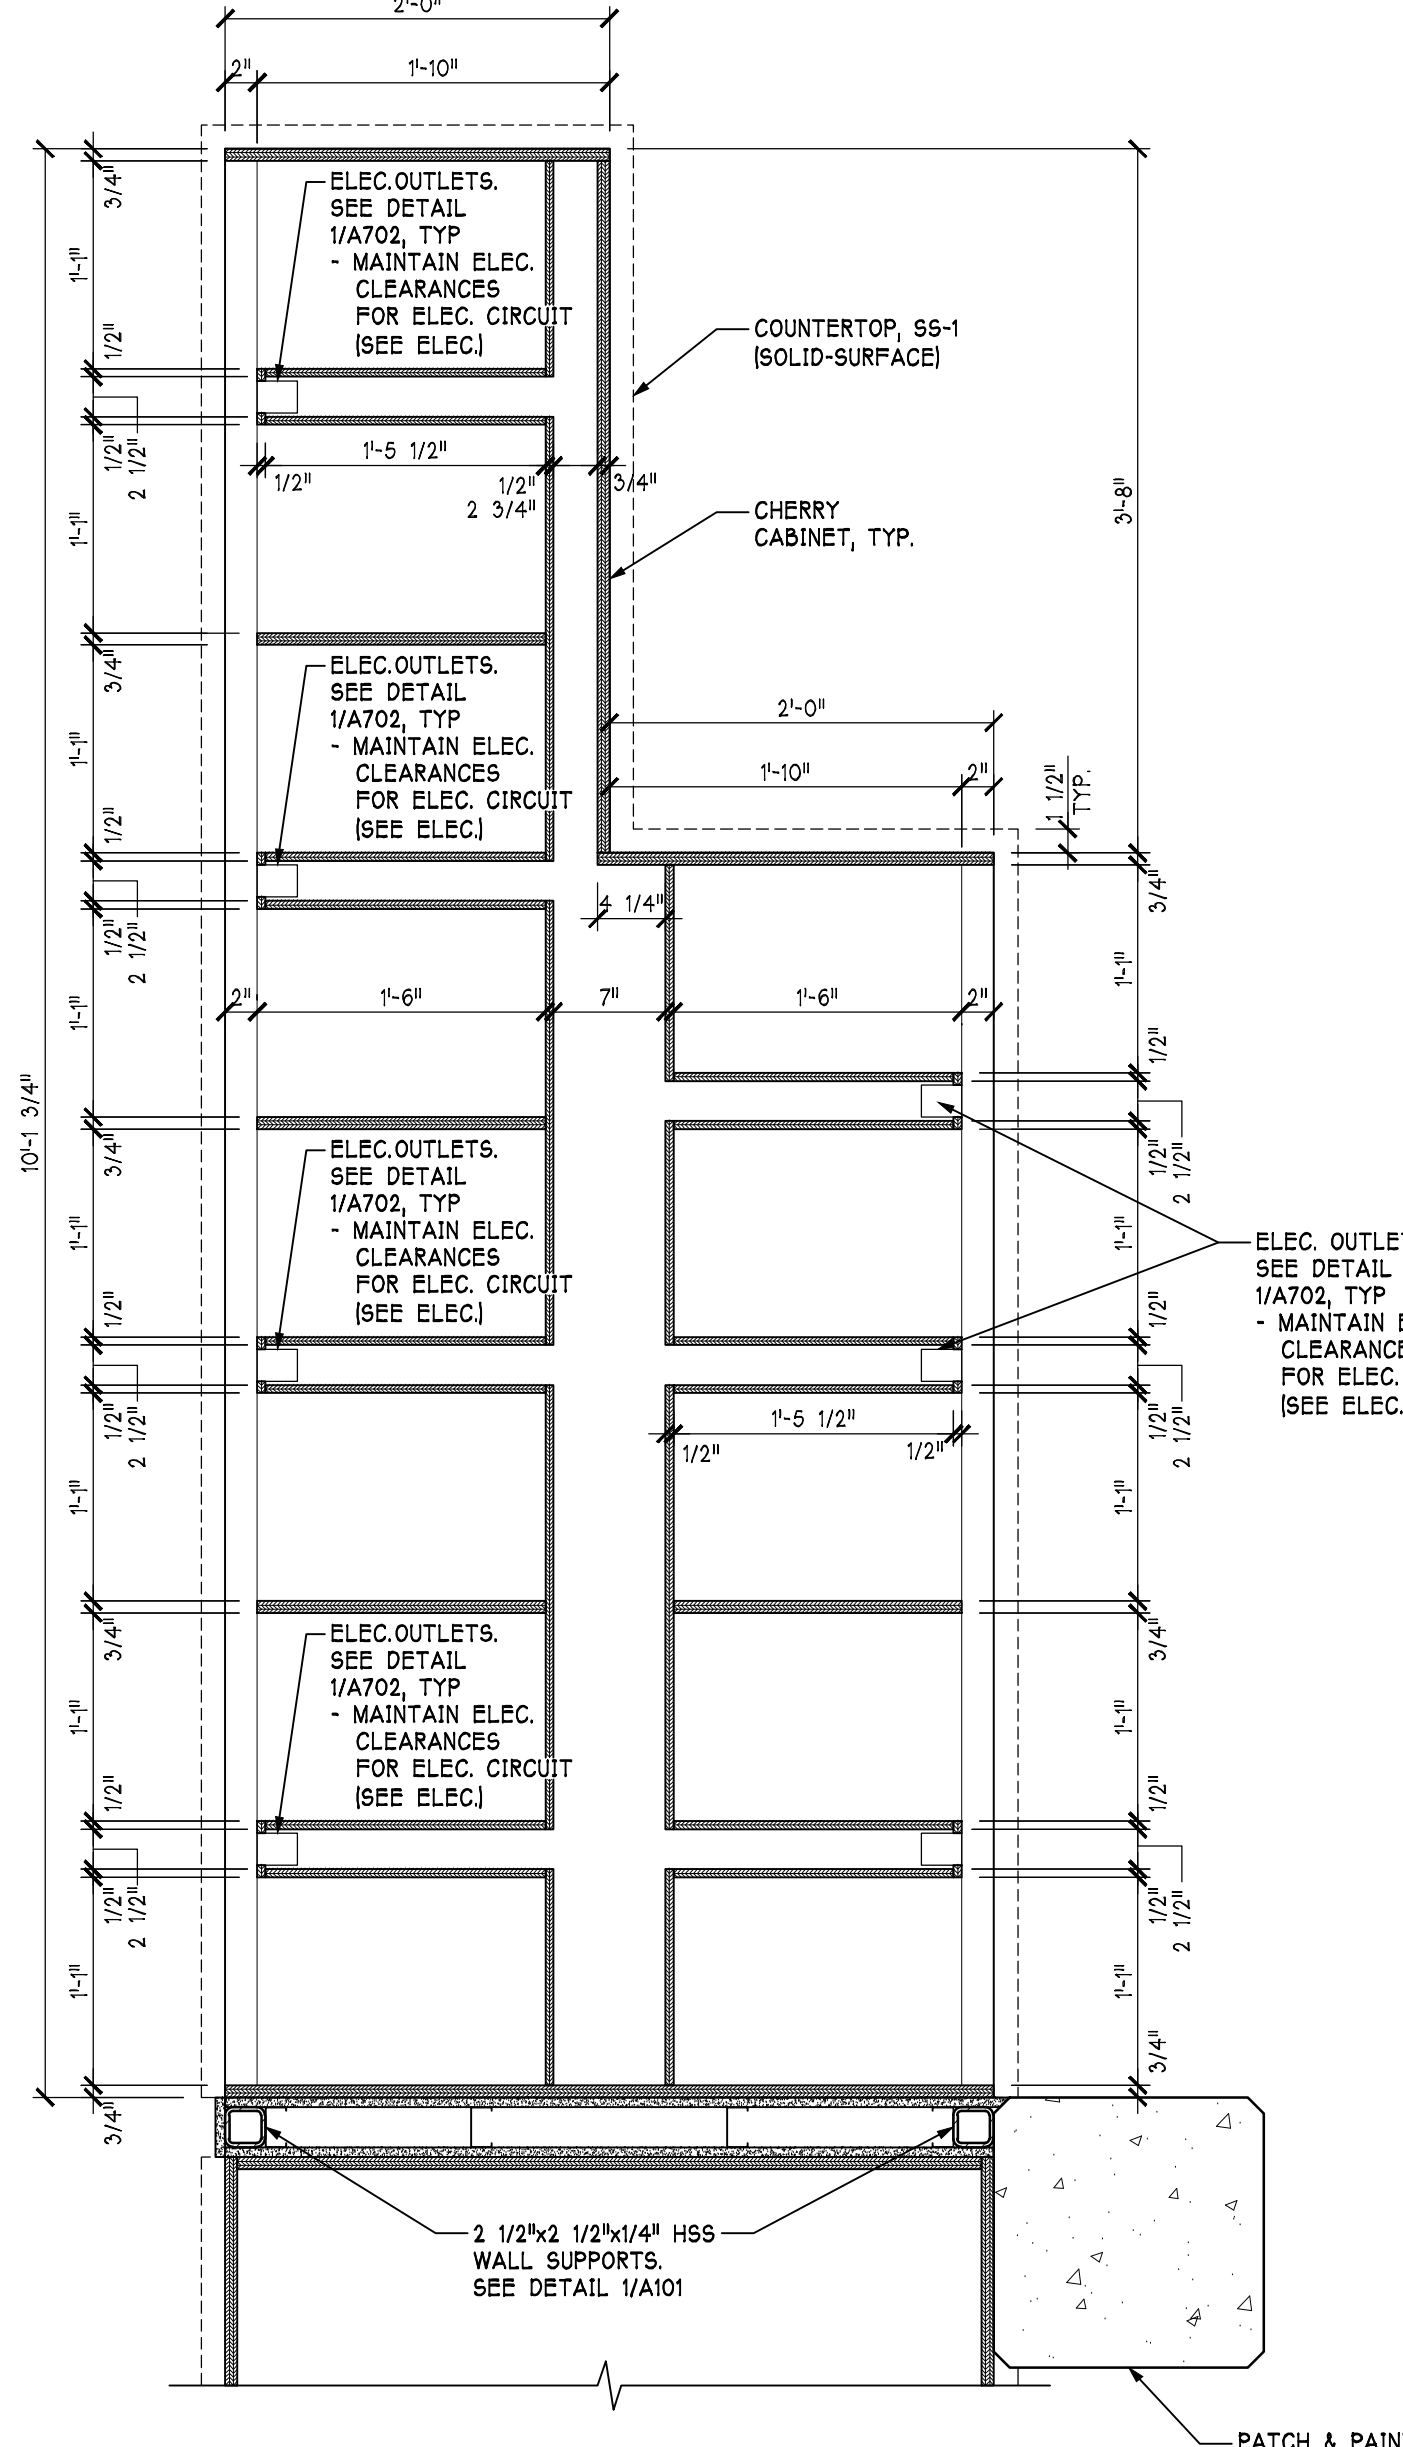


8 CUBBY-CABINET ENLARGED PLAN
1" = 1'-0"

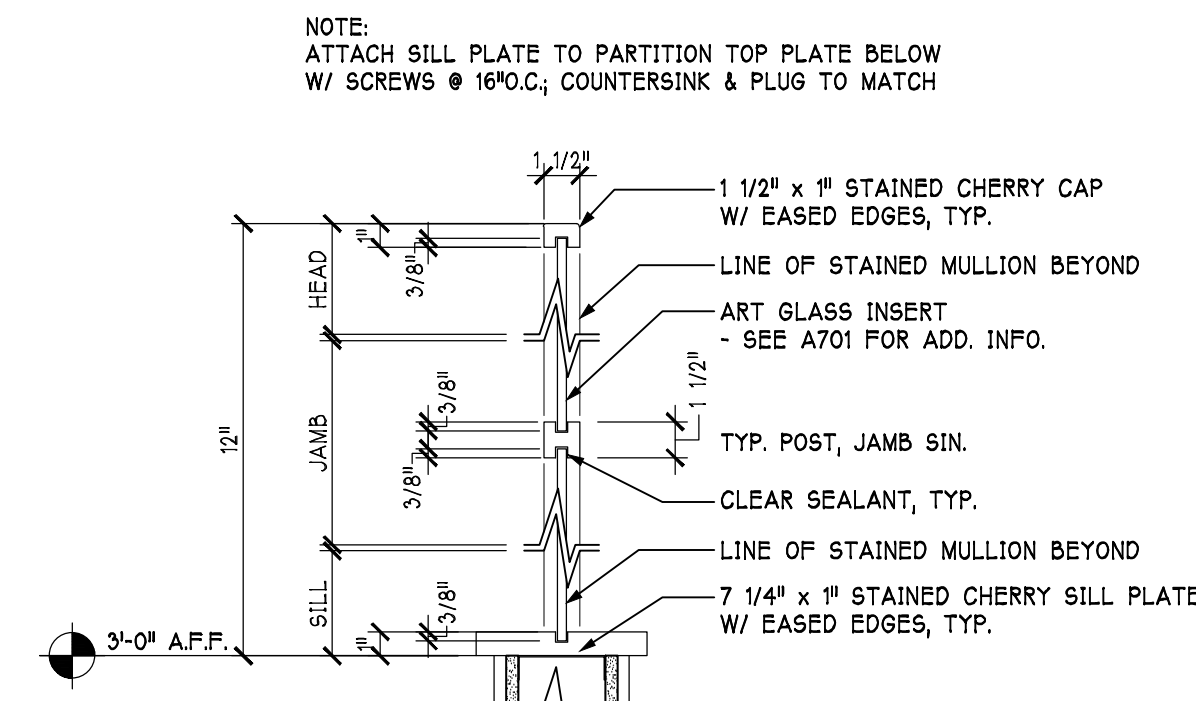


9 FRAME DETAIL
1" = 1'-0"

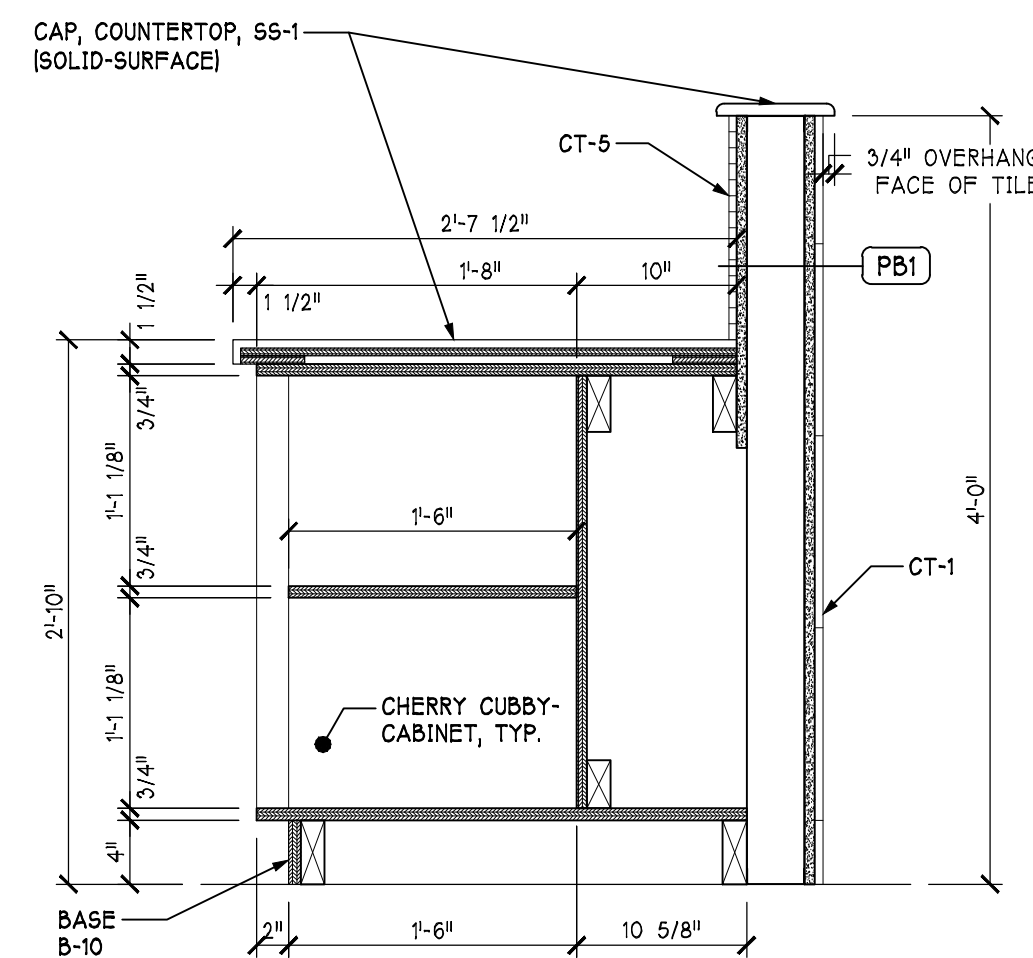


2 CUBBY-CABINET SECTION
1" = 1'-0"

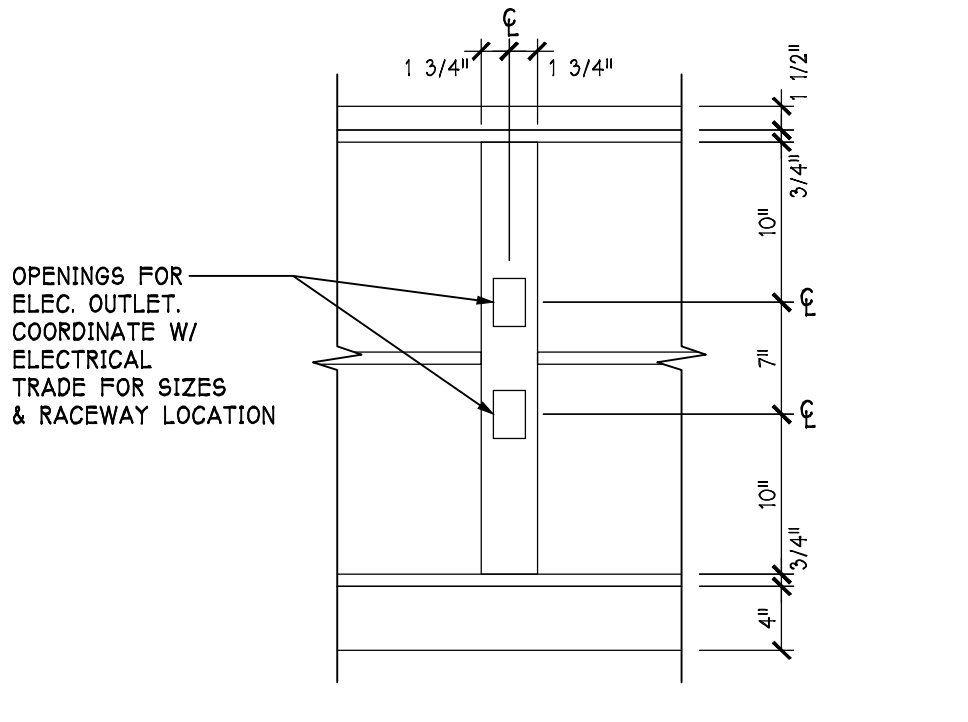


1 CUBBY TYPICAL DETAIL
1" = 1'-0"

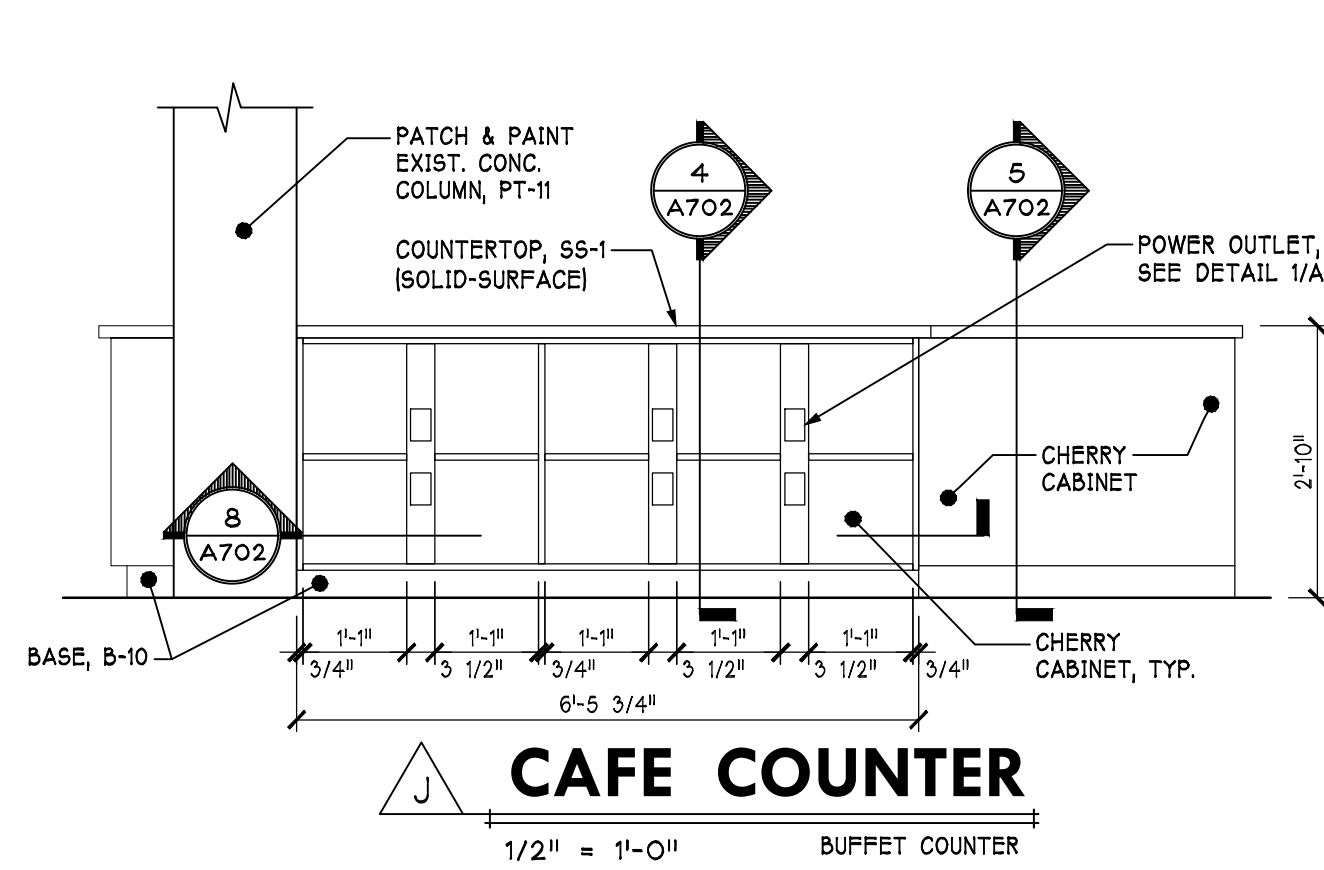


J CAFE COUNTER
1/2" = 1'-0"

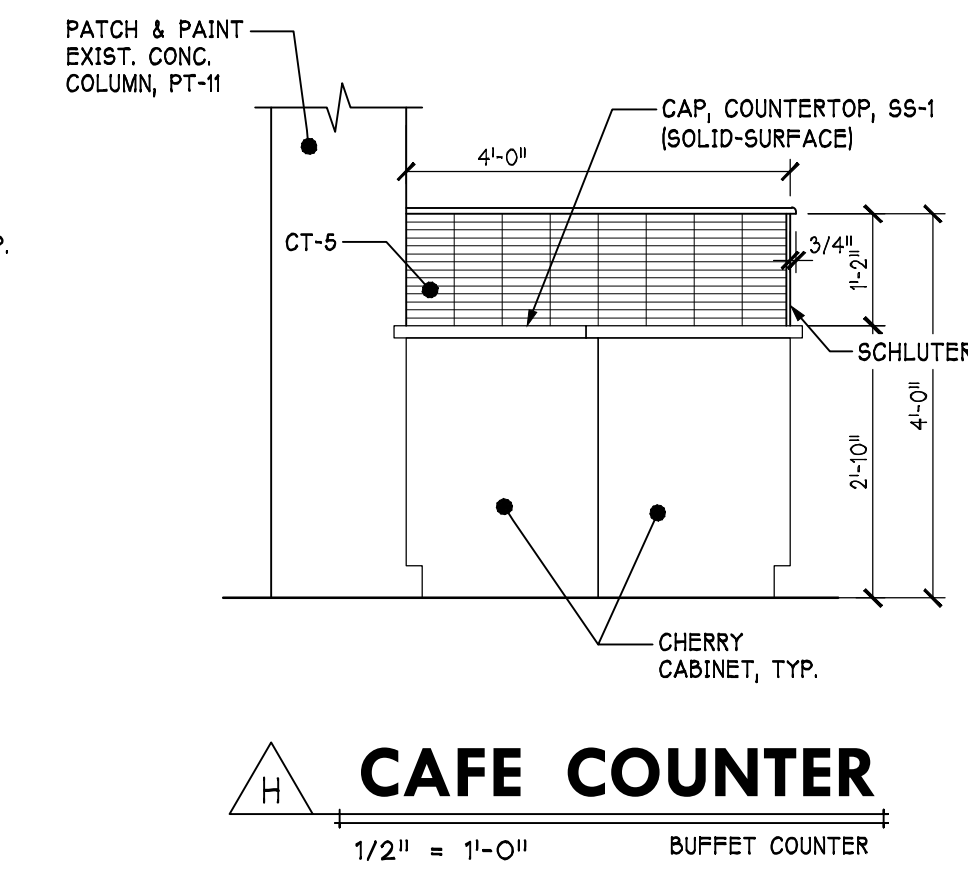


H CAFE COUNTER
1/2" = 1'-0"

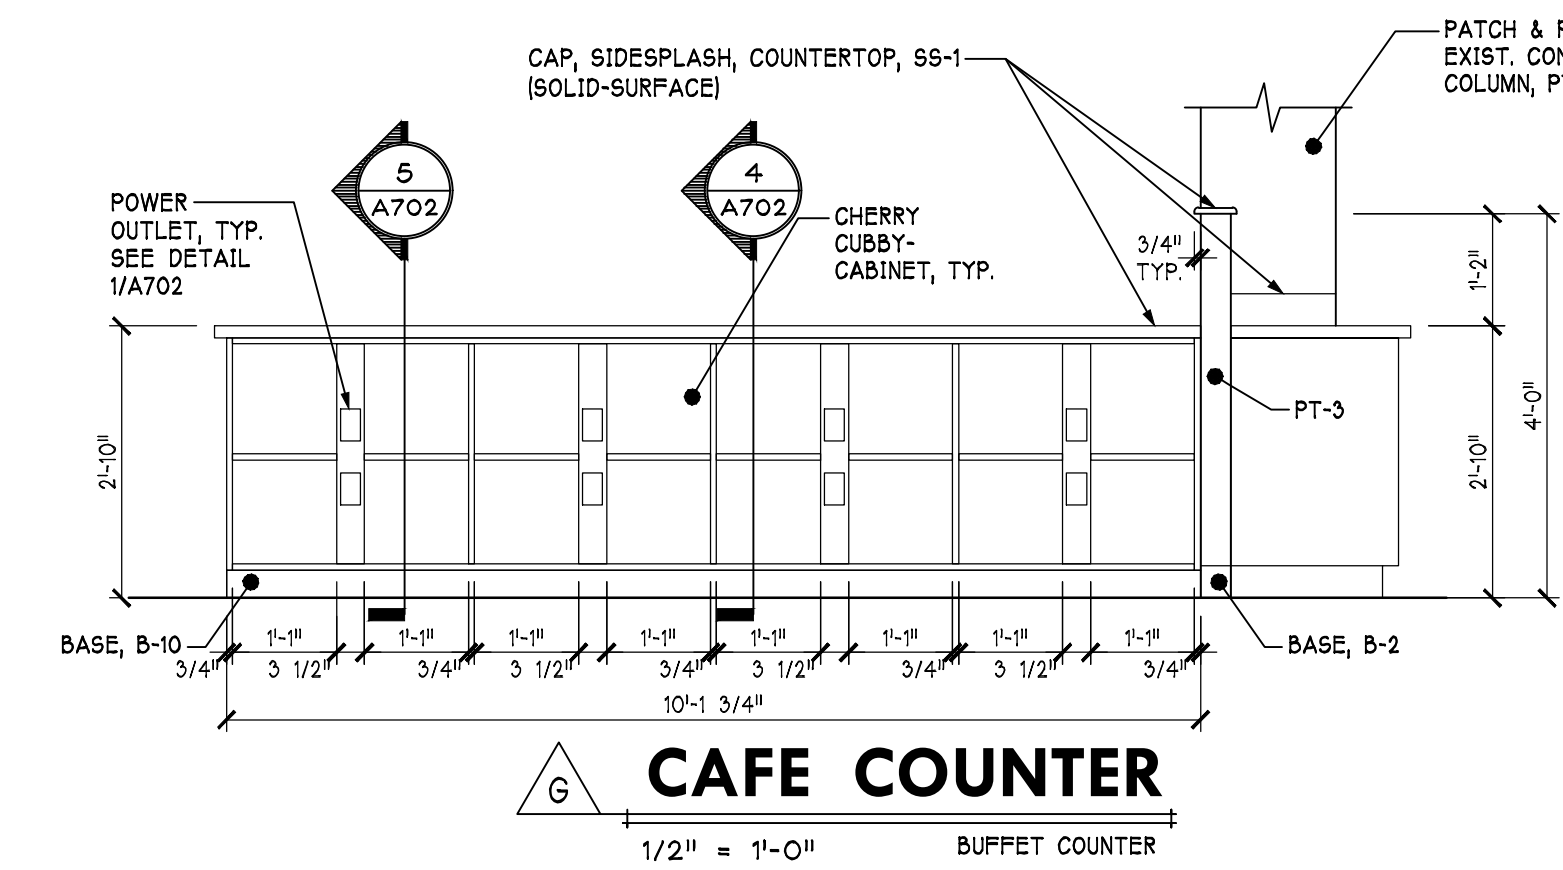


G CAFE COUNTER
1/2" = 1'-0"

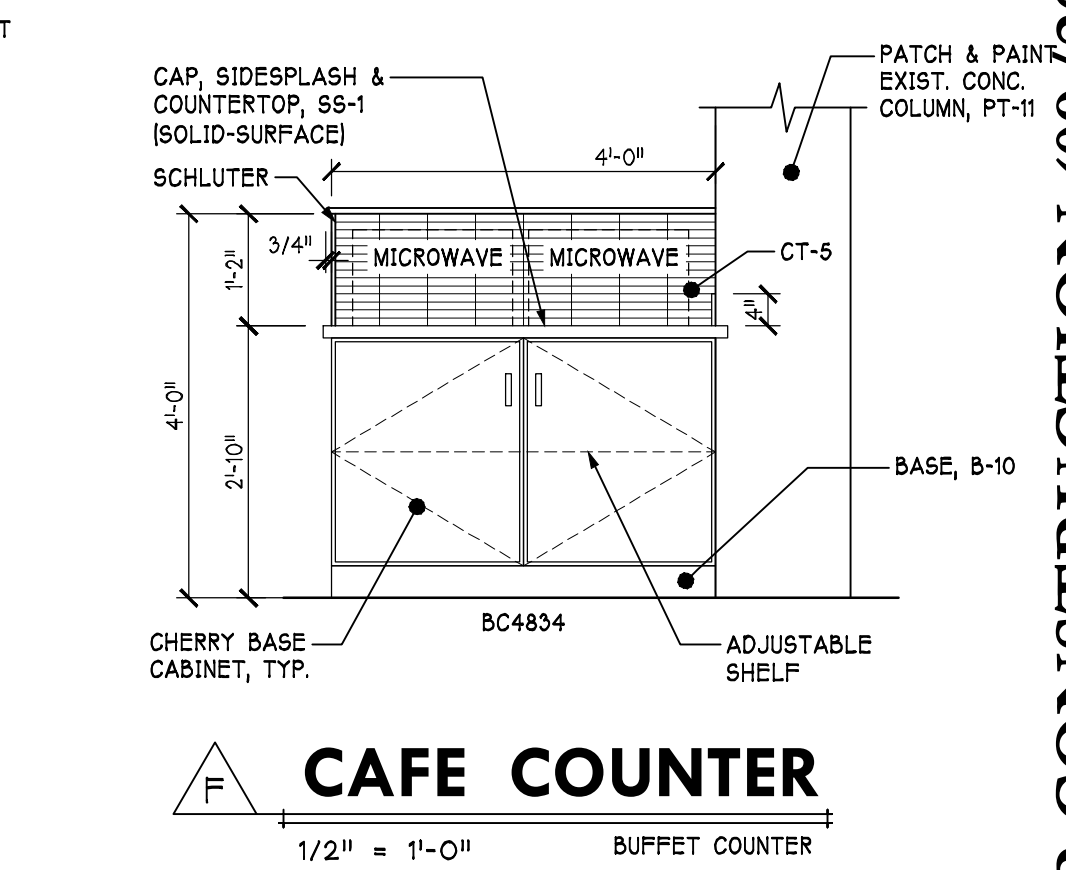


F CAFE COUNTER
1/2" = 1'-0"

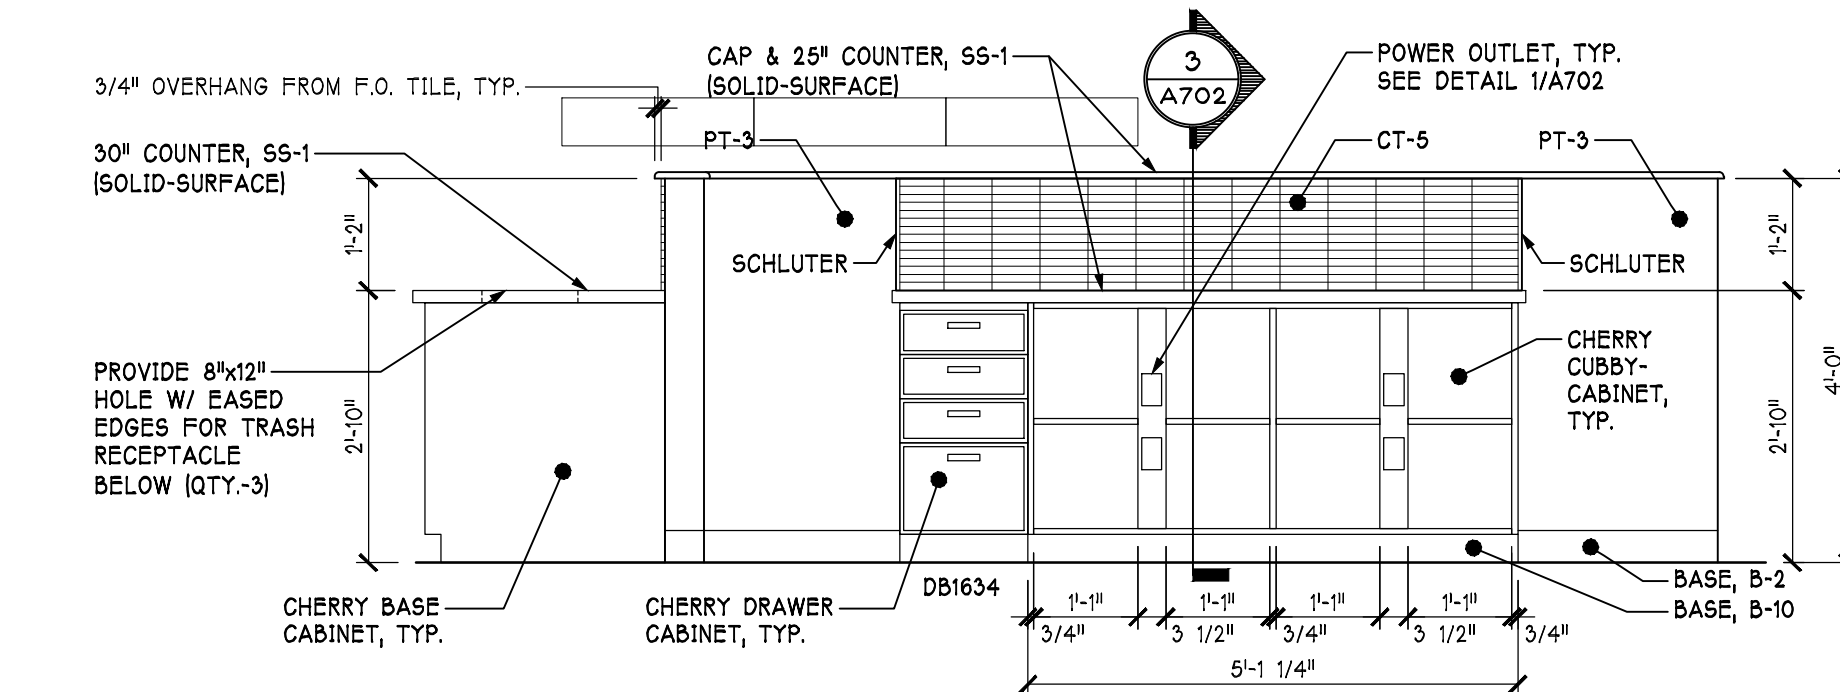


E CAFE COUNTER
1/2" = 1'-0"

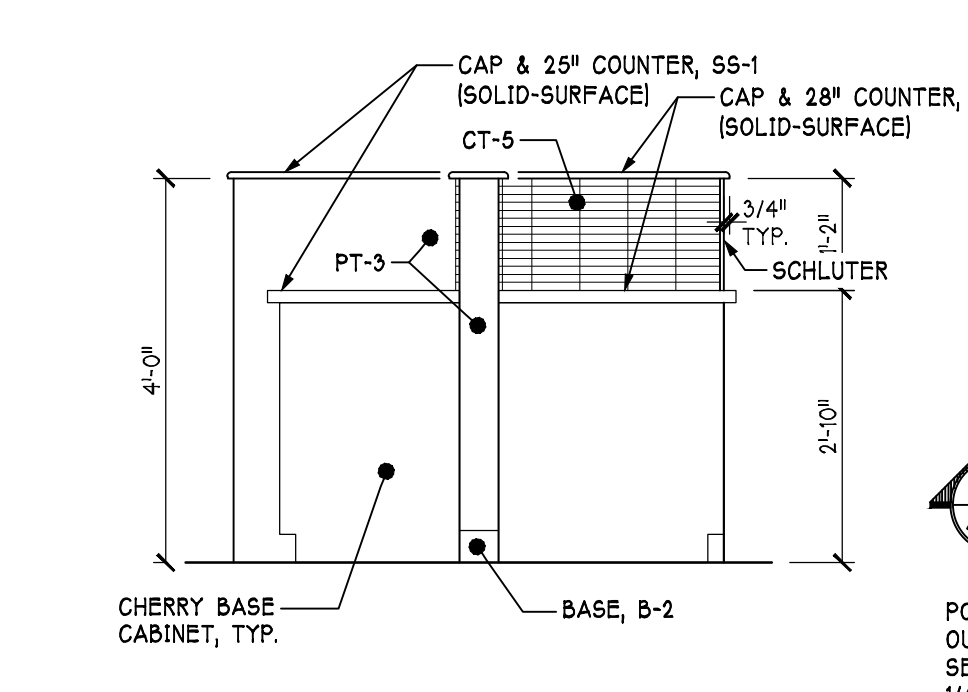


D CAFE COUNTER
1/2" = 1'-0"

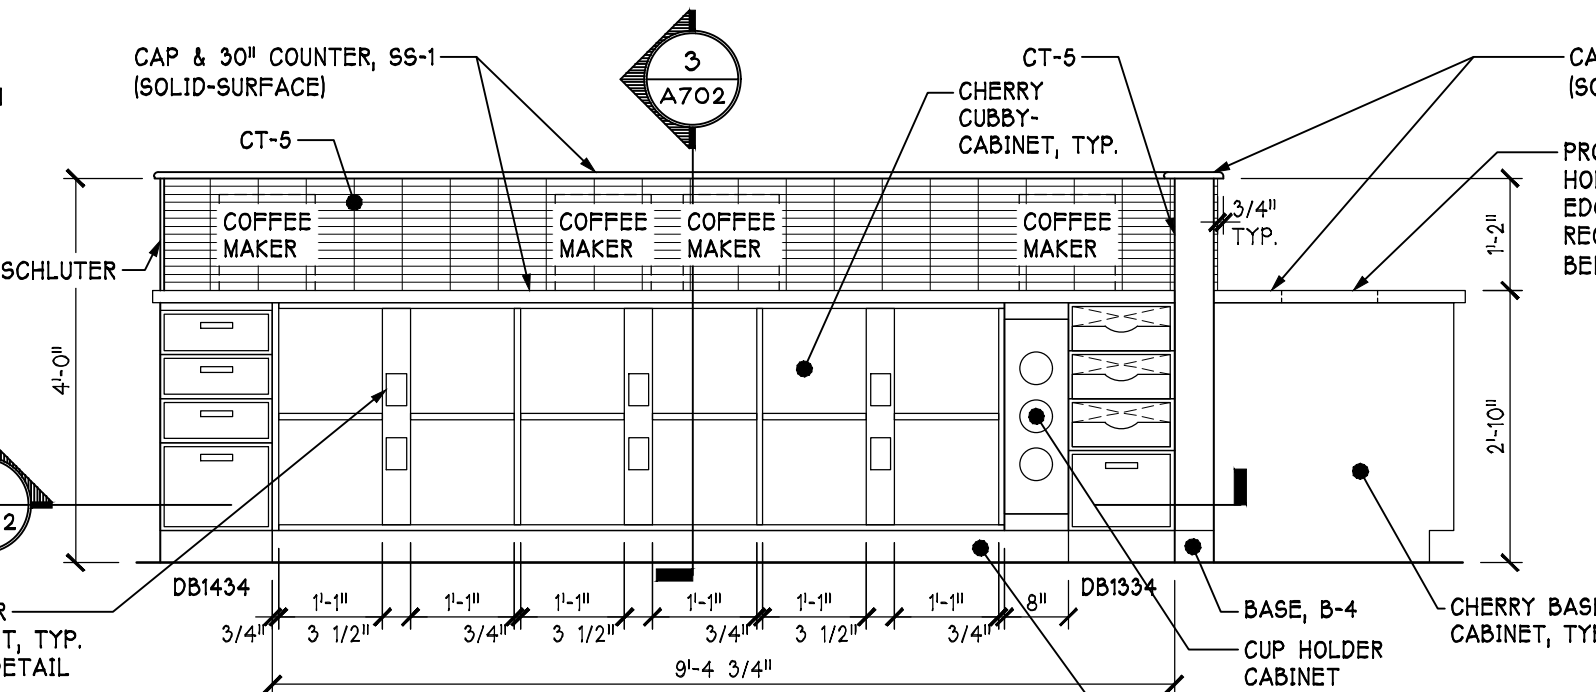

C CAFE COUNTER
1/2" = 1'-0"

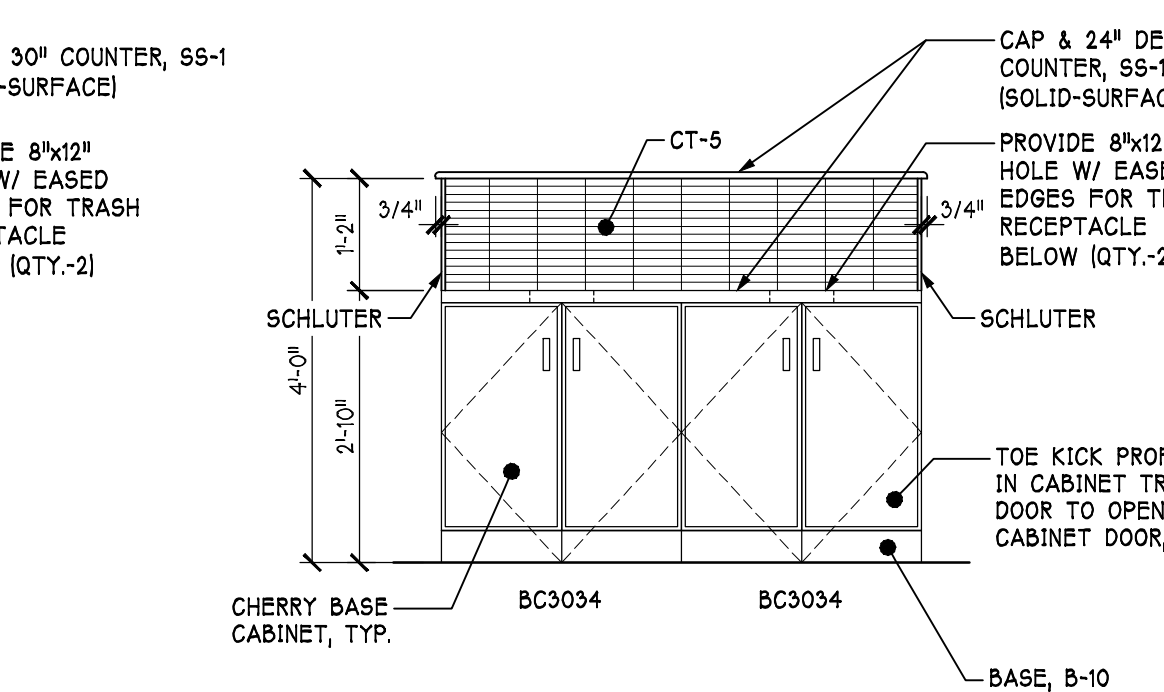

B TRASH RECEPTACLE & RECYCLING
1/2" = 1'-0"

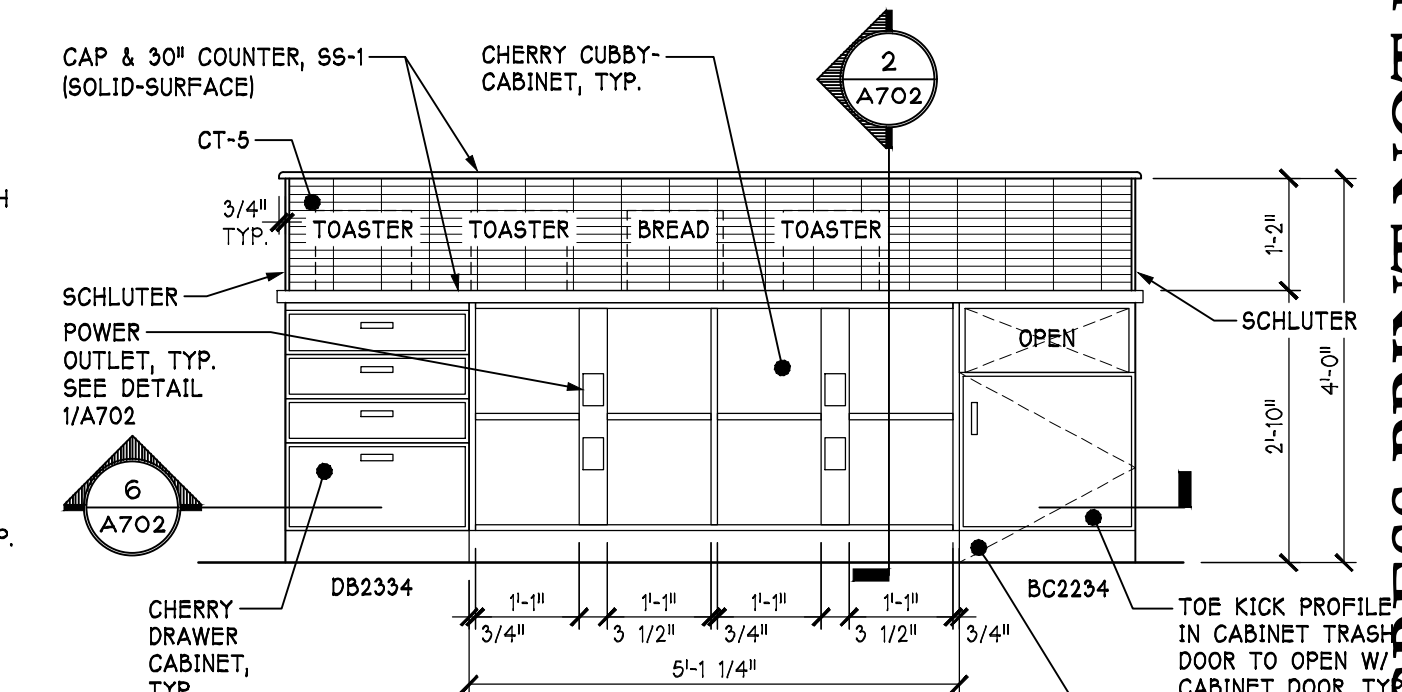

A CAFE COUNTER
1/2" = 1'-0"

PROGRESS PRINT NOT FOR CONSTRUCTION (09/20/18)

Revisions:	
No: 1	Date: 05/13/19
Revisions per Addendum No. 4	
No:	Date:
No:	Date:
No:	Date:
No:	Date:
No:	Date:
No:	Date:
No:	Date:



NEWCOMER ASSOCIATES
architecture + engineering

1105 Shiller Avenue Chambersburg, PA 17201 Tel: 717 263 1001 Fax: 717 263 7380 www.newcomerassoc.com

Martin's Famous Pastry Shoppe
Transportation Cafe





Chambersburg, Pennsylvania 17202

© 2018
Newcomer Associates, Inc.

Drawing Title:
ENLARGED
FLOOR
FURNITURE &
WALL FINISH
PLANS

Sheet No.
A801
Date: MM/DD/YY

PROGRESS PRINT NOT FOR CONSTRUCTION (09/20/18)

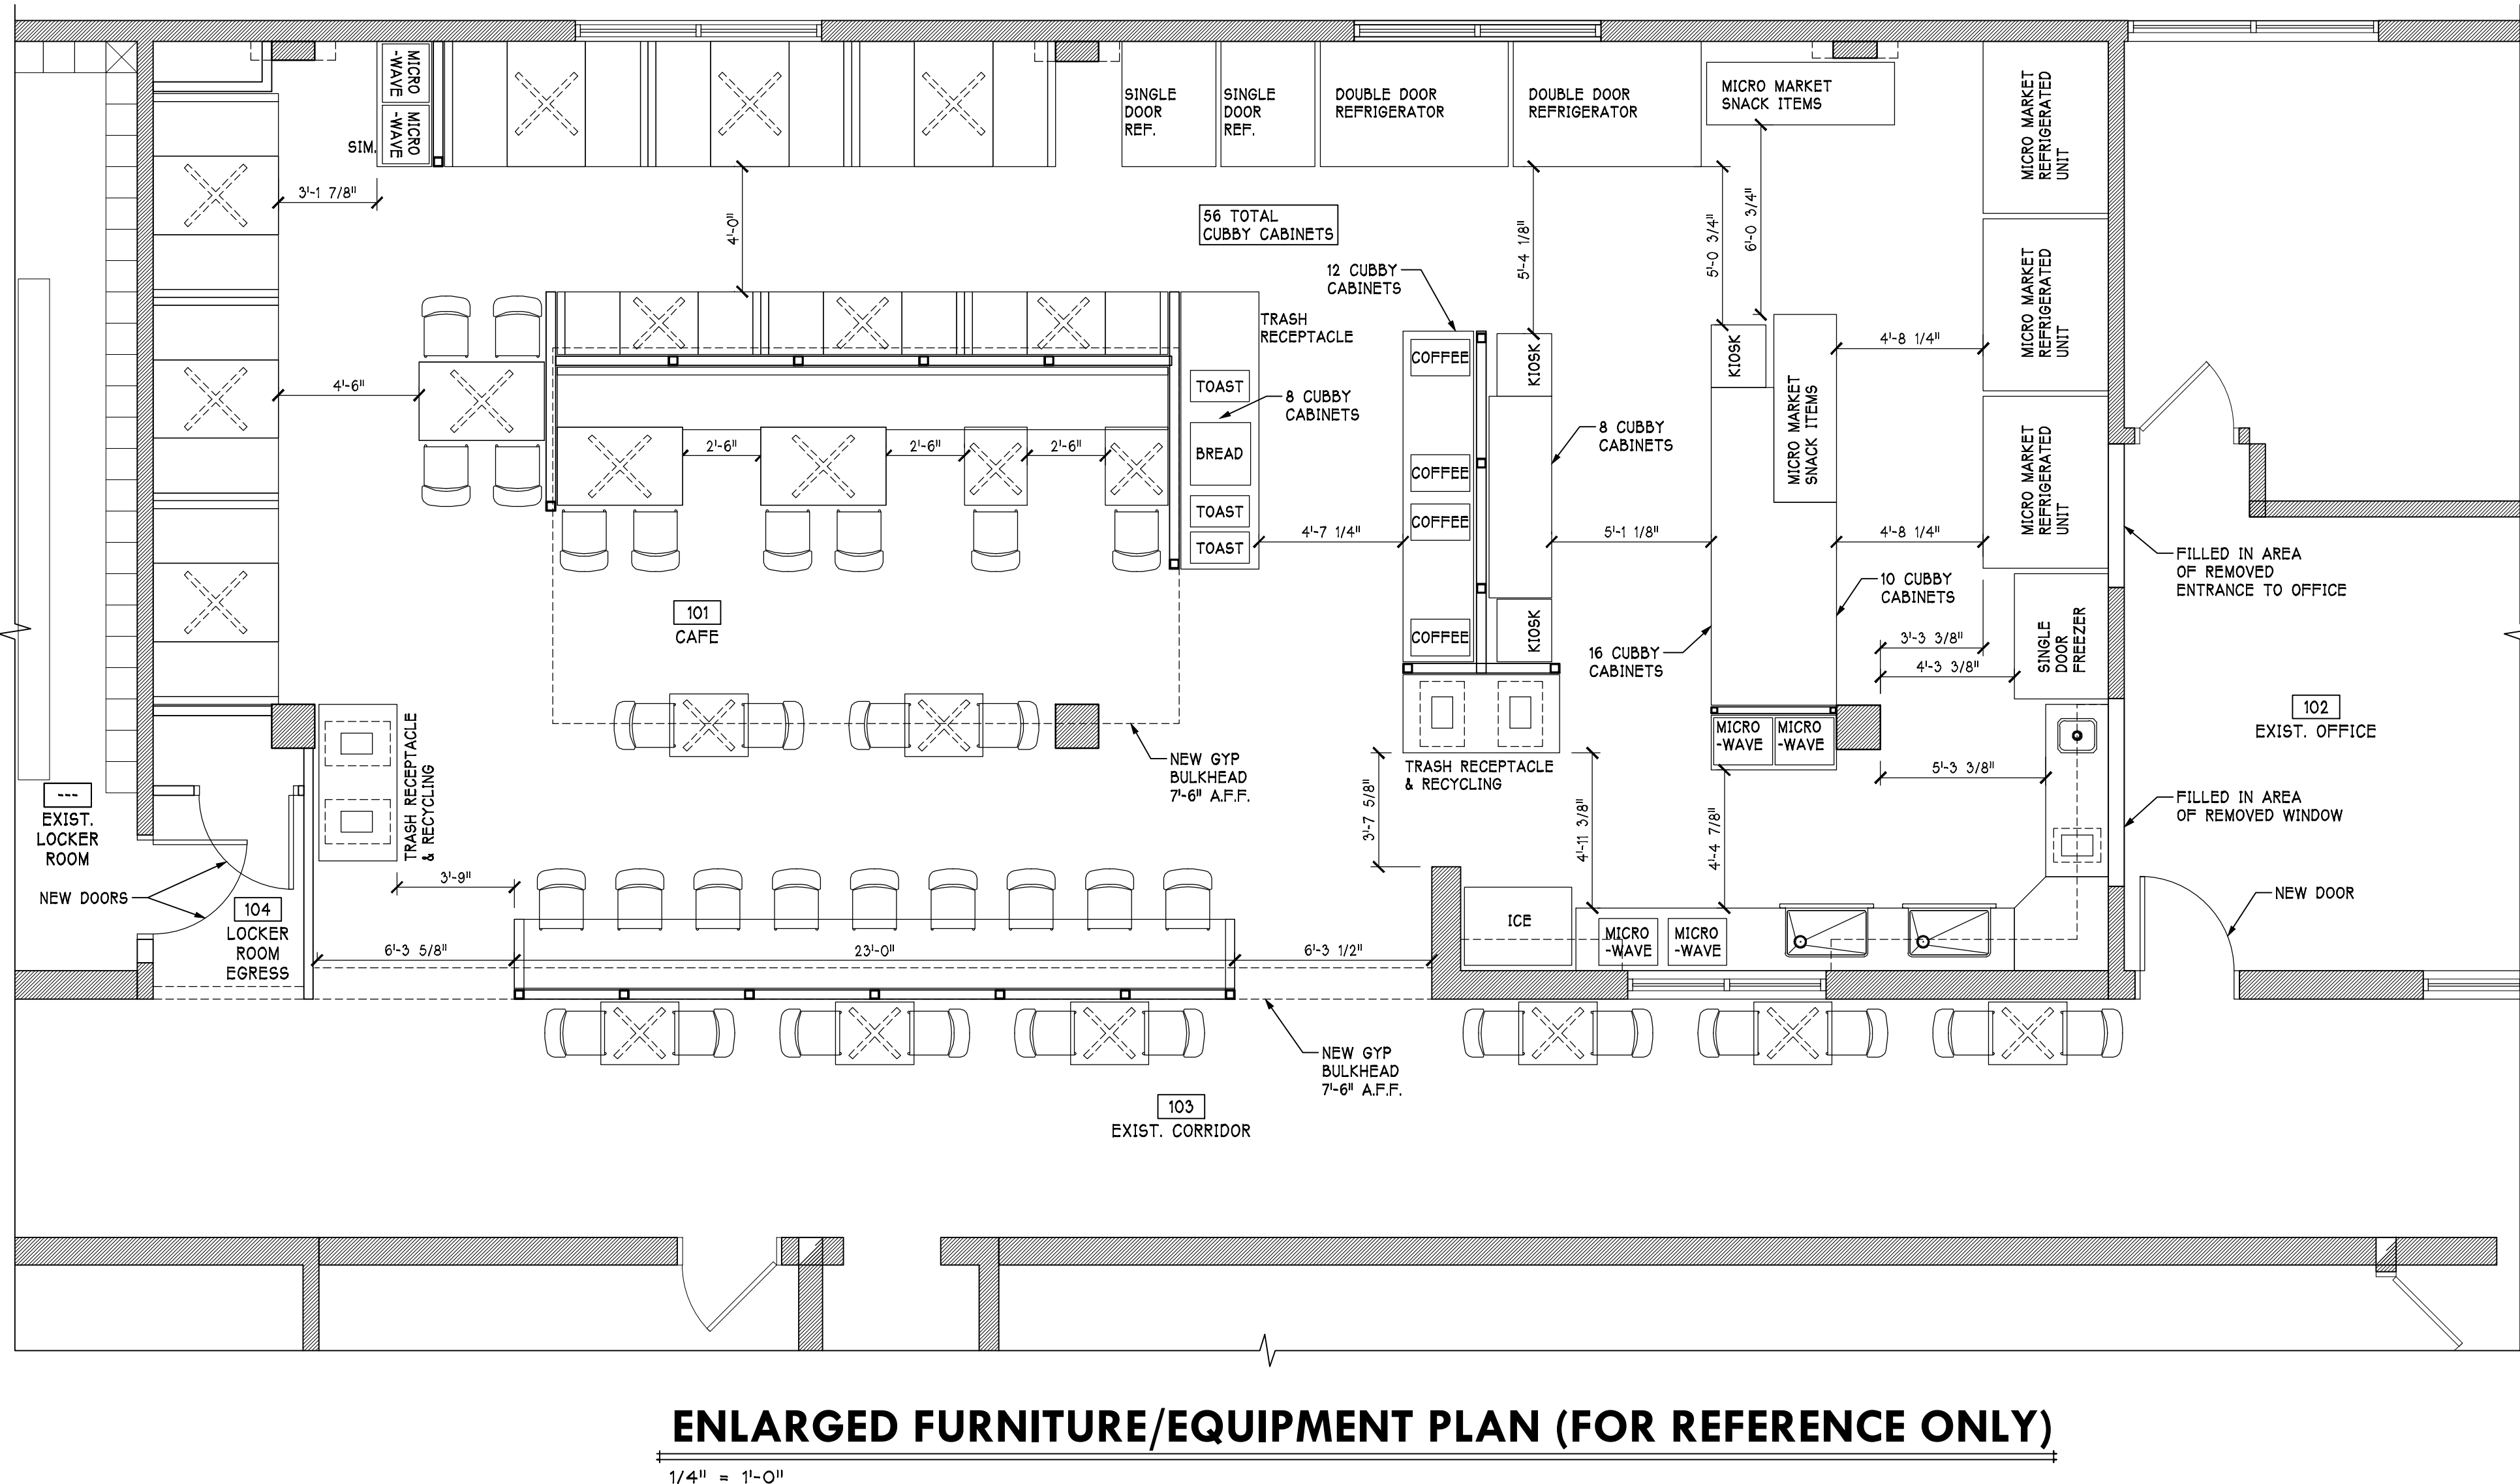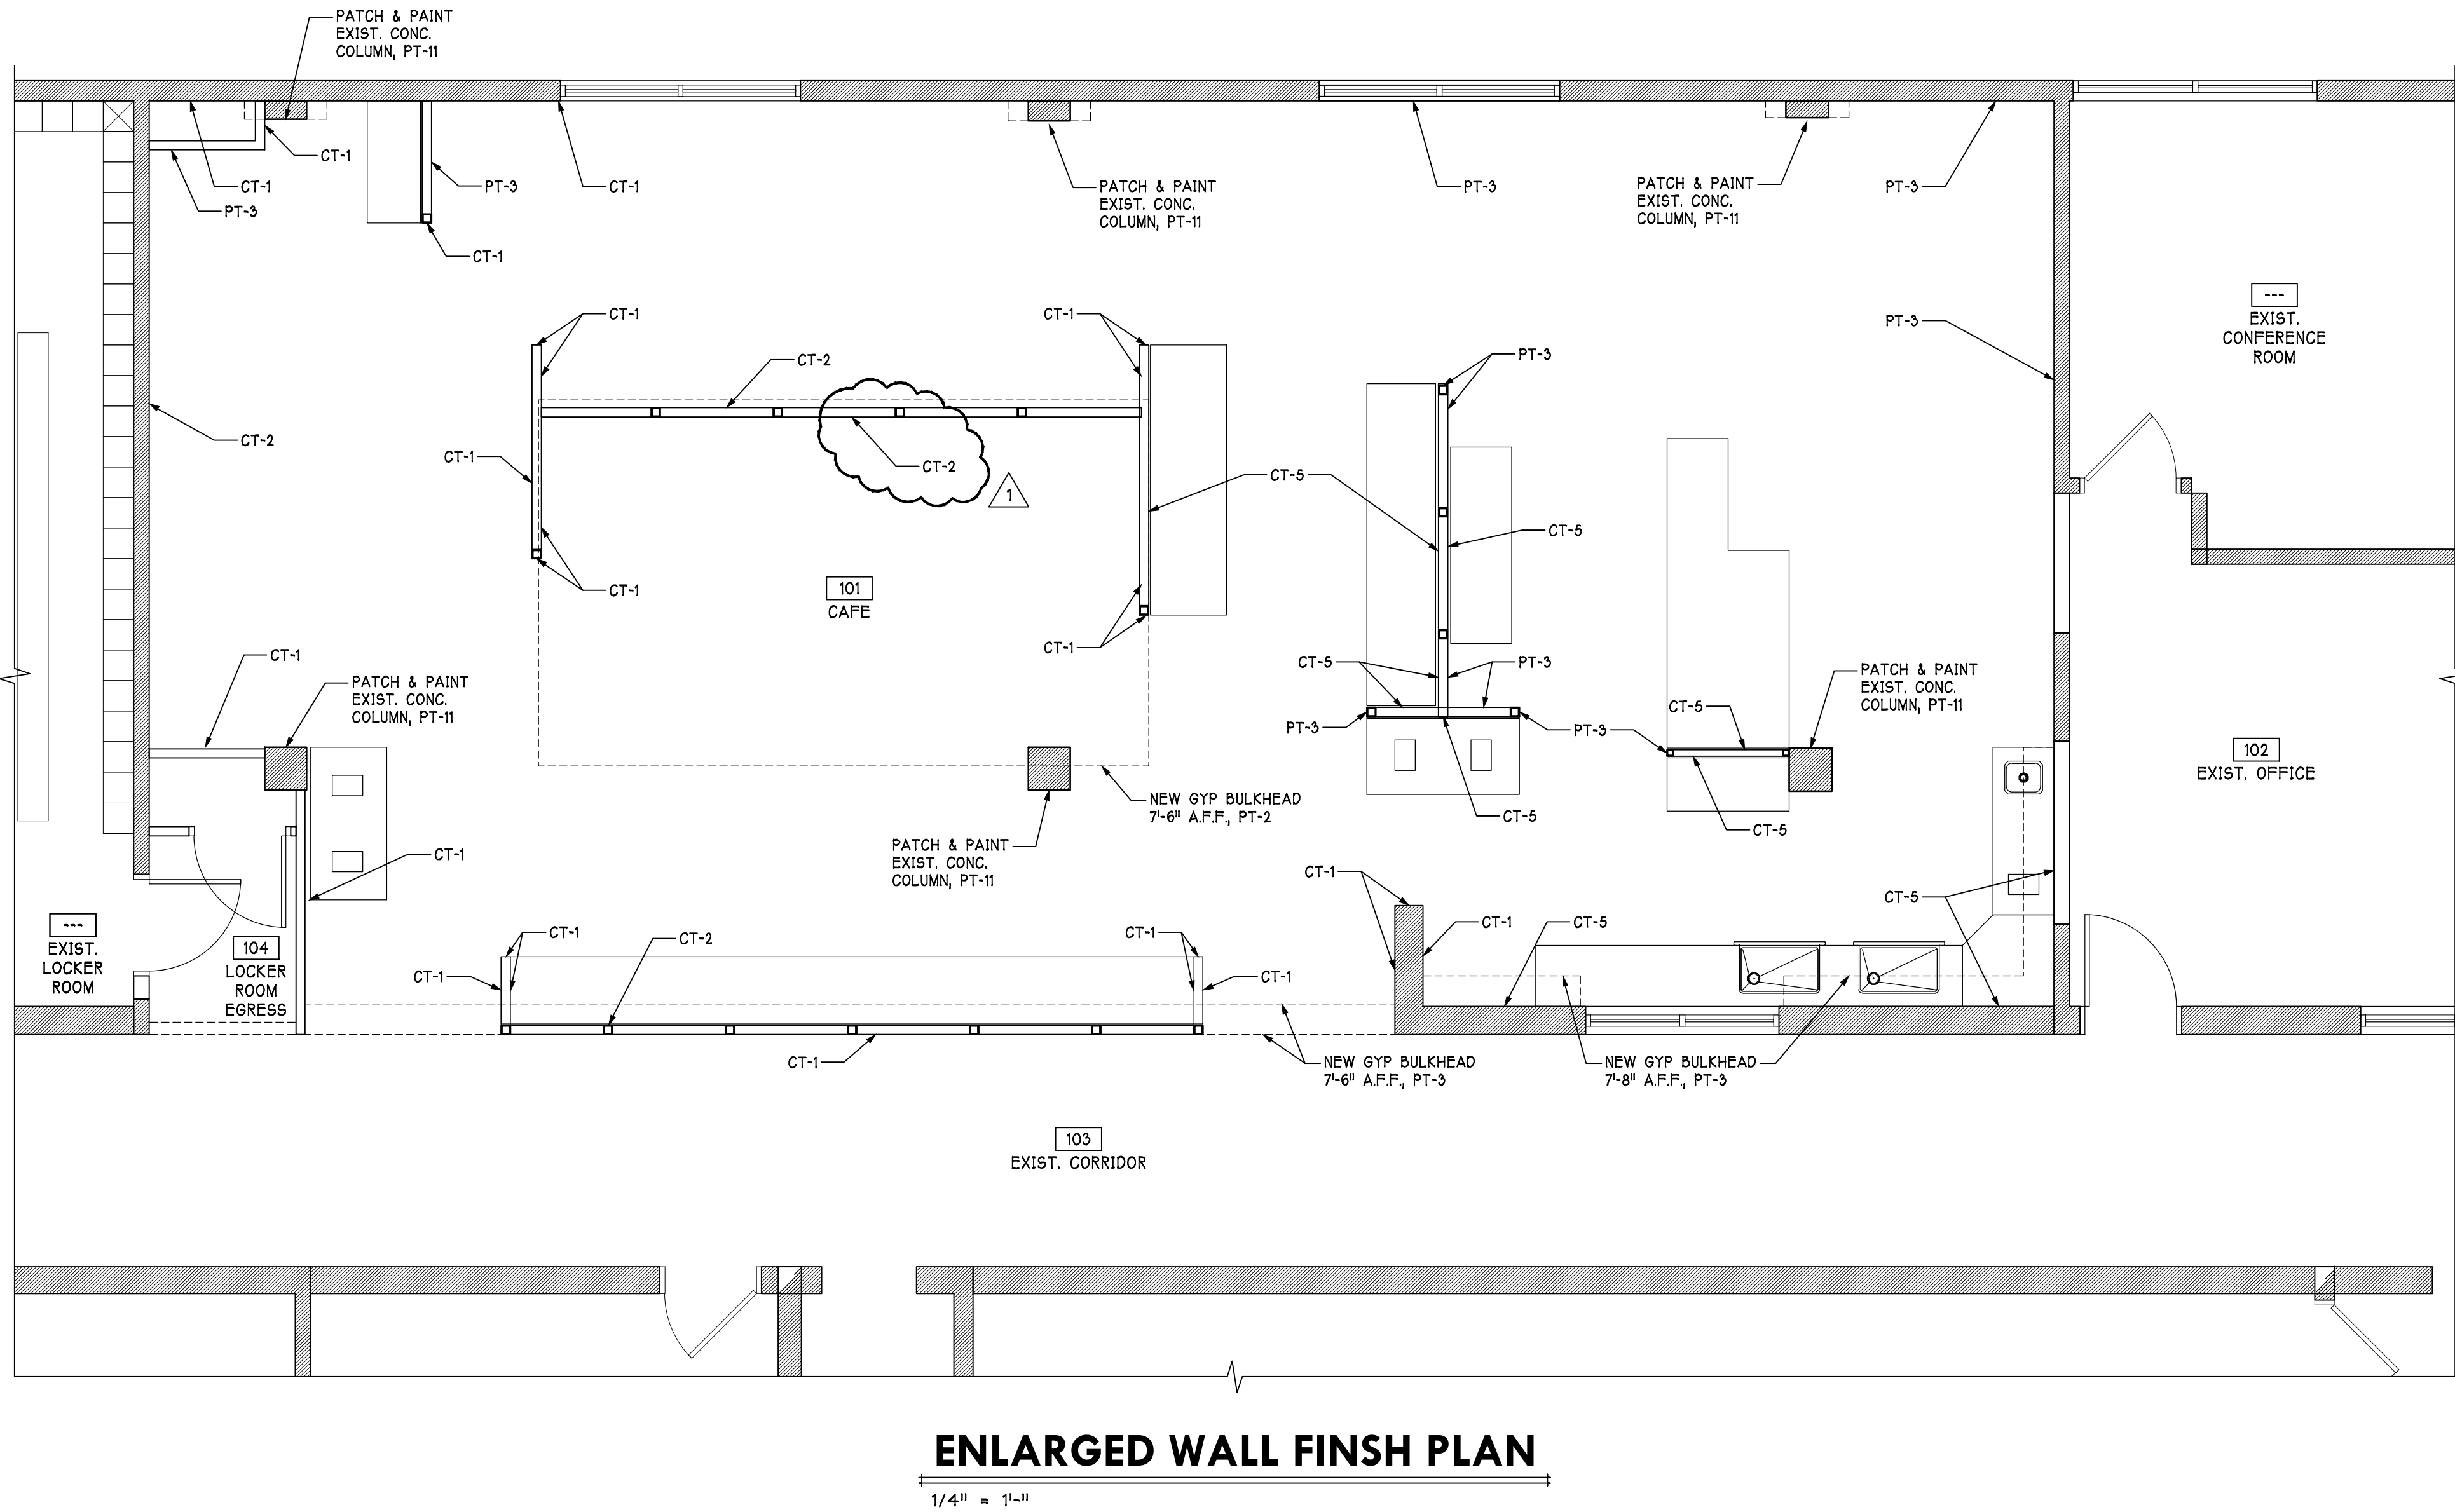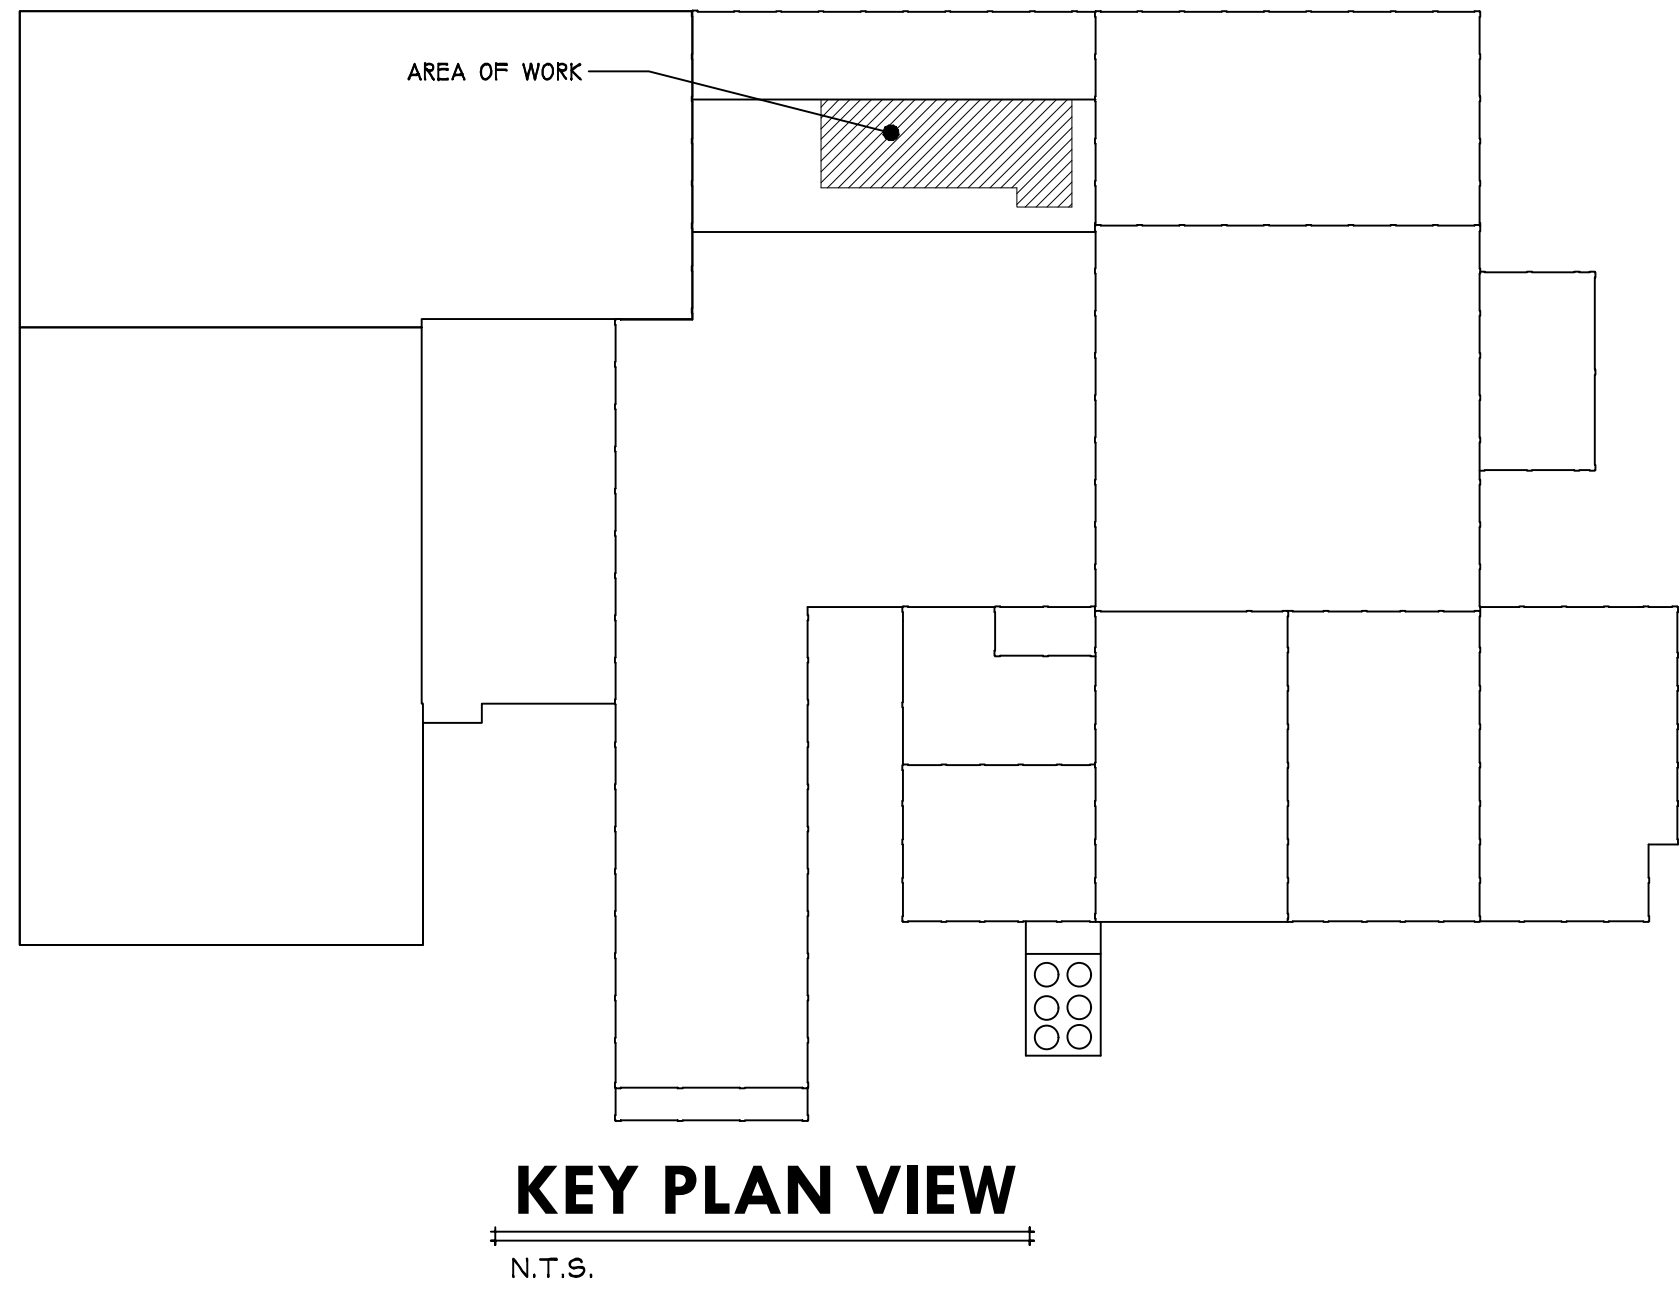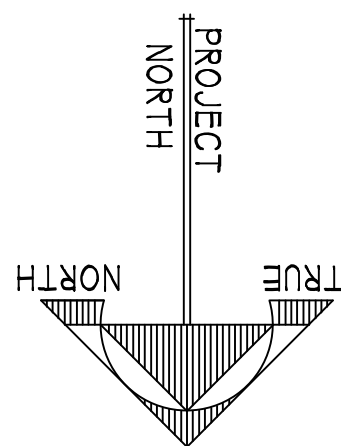

Revisions:	
No:	Date: 05/13/19
Revisions per Addendum No. 4	
No:	Date:
No:	Date:
No:	Date:
No:	Date:
No:	Date:
No:	Date:







REFLECTED CEILING PLAN NOTES

- SEE ROOM FINISH SCHEDULES FOR CEILING HEIGHT INFORMATION.
- SEE ENLARGED GUEST ROOM PLANS FOR GUEST ROOM BULKHEAD INFORMATION
- SEE ENLARGED GUEST ROOM LIGHTING PLANS FOR GUEST ROOM LIGHTING INFORMATION


REFLECTED CEILING LEGEND

SYMBOL	DESCRIPTION
	2x4 LAY-IN LIGHT
	2x2 LAY-IN LIGHT
	CIRCULAR SURFACE MOUNTED LIGHT
	CIRCULAR PENDENT LIGHT
	LINEAR PENDENT LIGHT
	LINEAR SURFACE MOUNTED LIGHT
	DOWN LIGHT
	EXIT SIGN
	COMBINATION EXIT/EGRESS LIGHT
	EGRESS LIGHT
	SMOKE DETECTOR
	HEAT DETECTOR
	FIRE ALARM STROBE
	FIRE ALARM HORN STROBE
	SUPPLY DIFFUSER
	RETURN GRILLE
	CONCEALED FIRE SPRINKLER
	PENDENT FIRE SPRINKLER
	SEMI-RECESSED FIRE SPRINKLER
	SIDEWALL FIRE SPRINKLER
	UP-RIGHT PENDENT SPRINKLER

NOTE: THIS IS A GENERAL LEGEND AND MAY NOT INCLUDE ALL SPECIFIC SYMBOLS IN THIS PROJECT. REFER TO INDIVIDUAL DISCIPLINE DRAWINGS FOR SPECIFIC DETAILS.

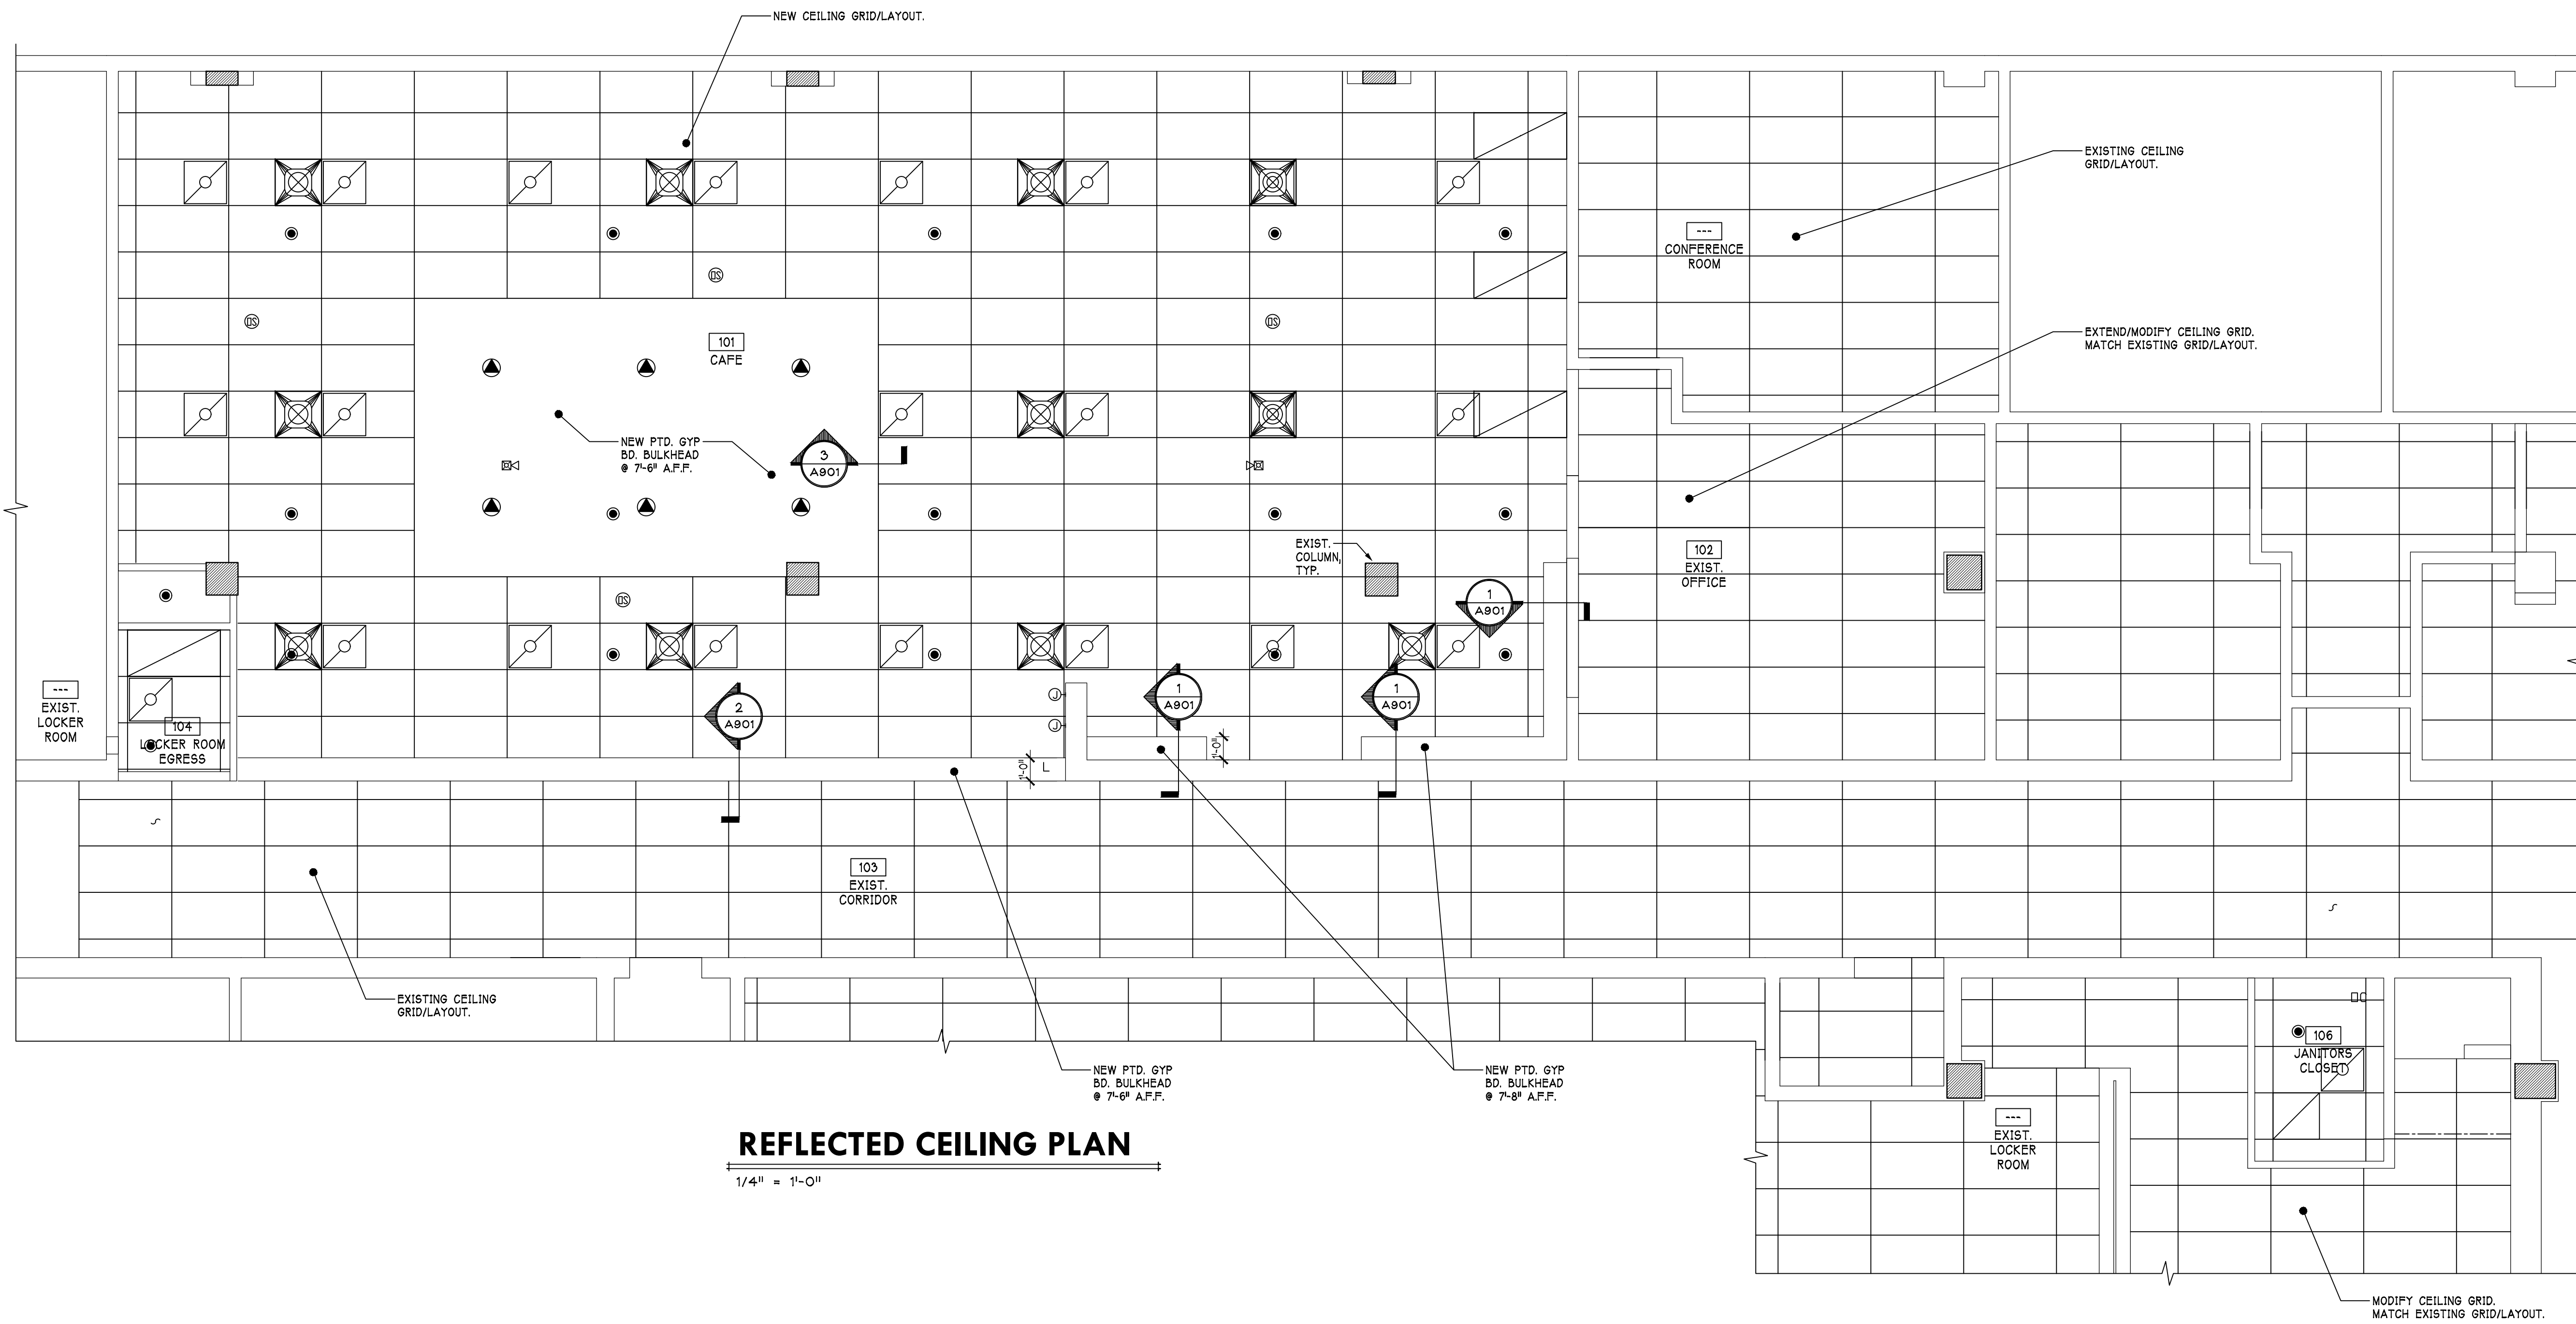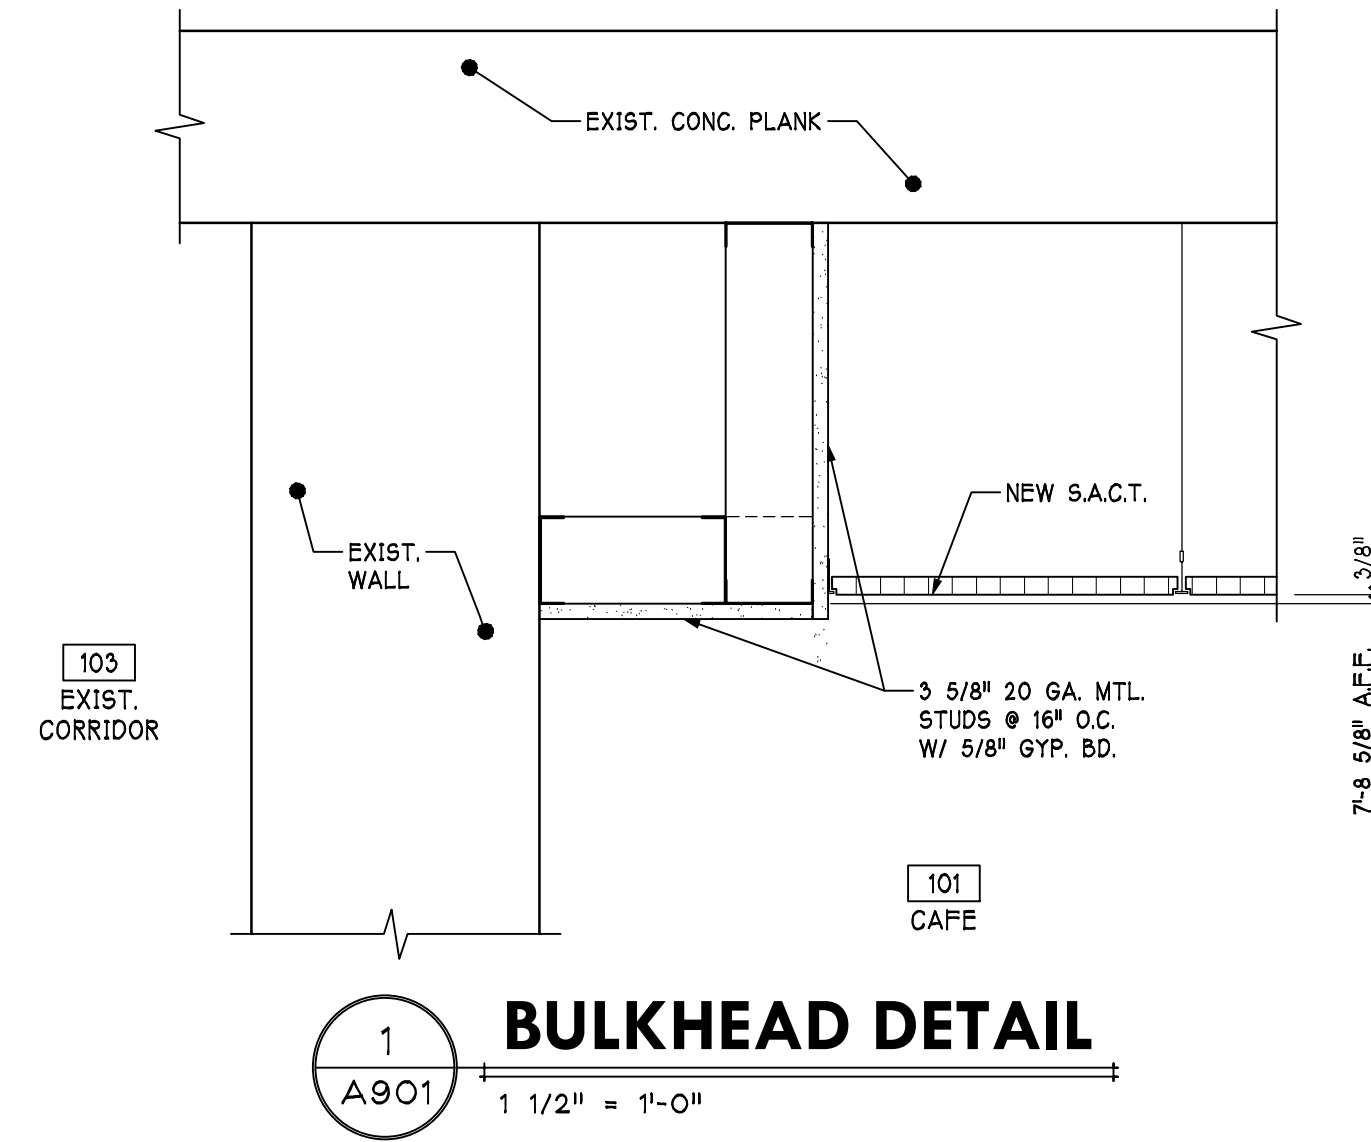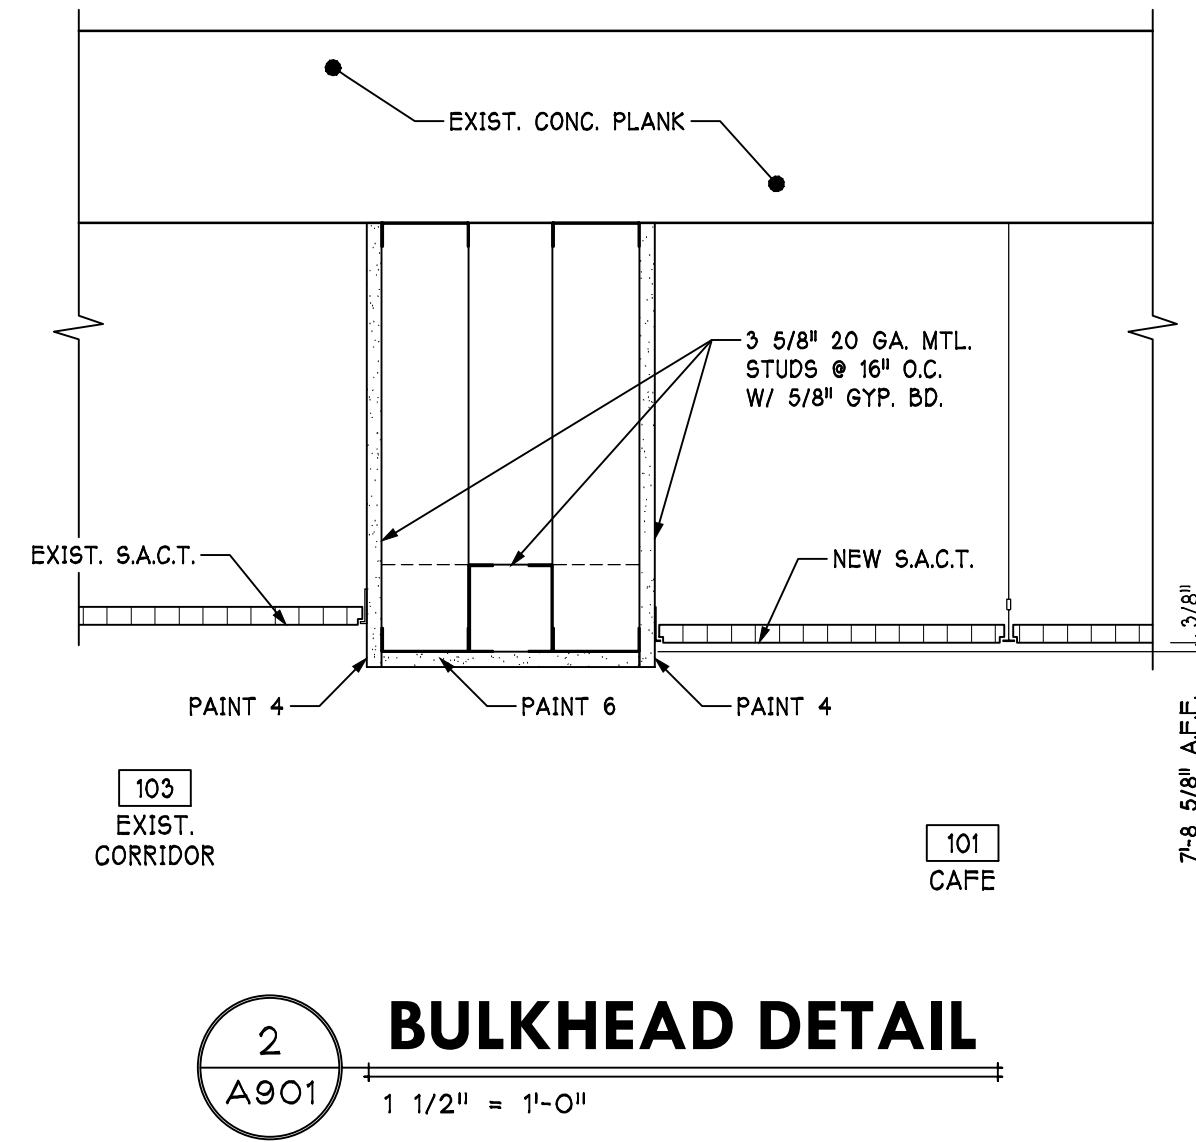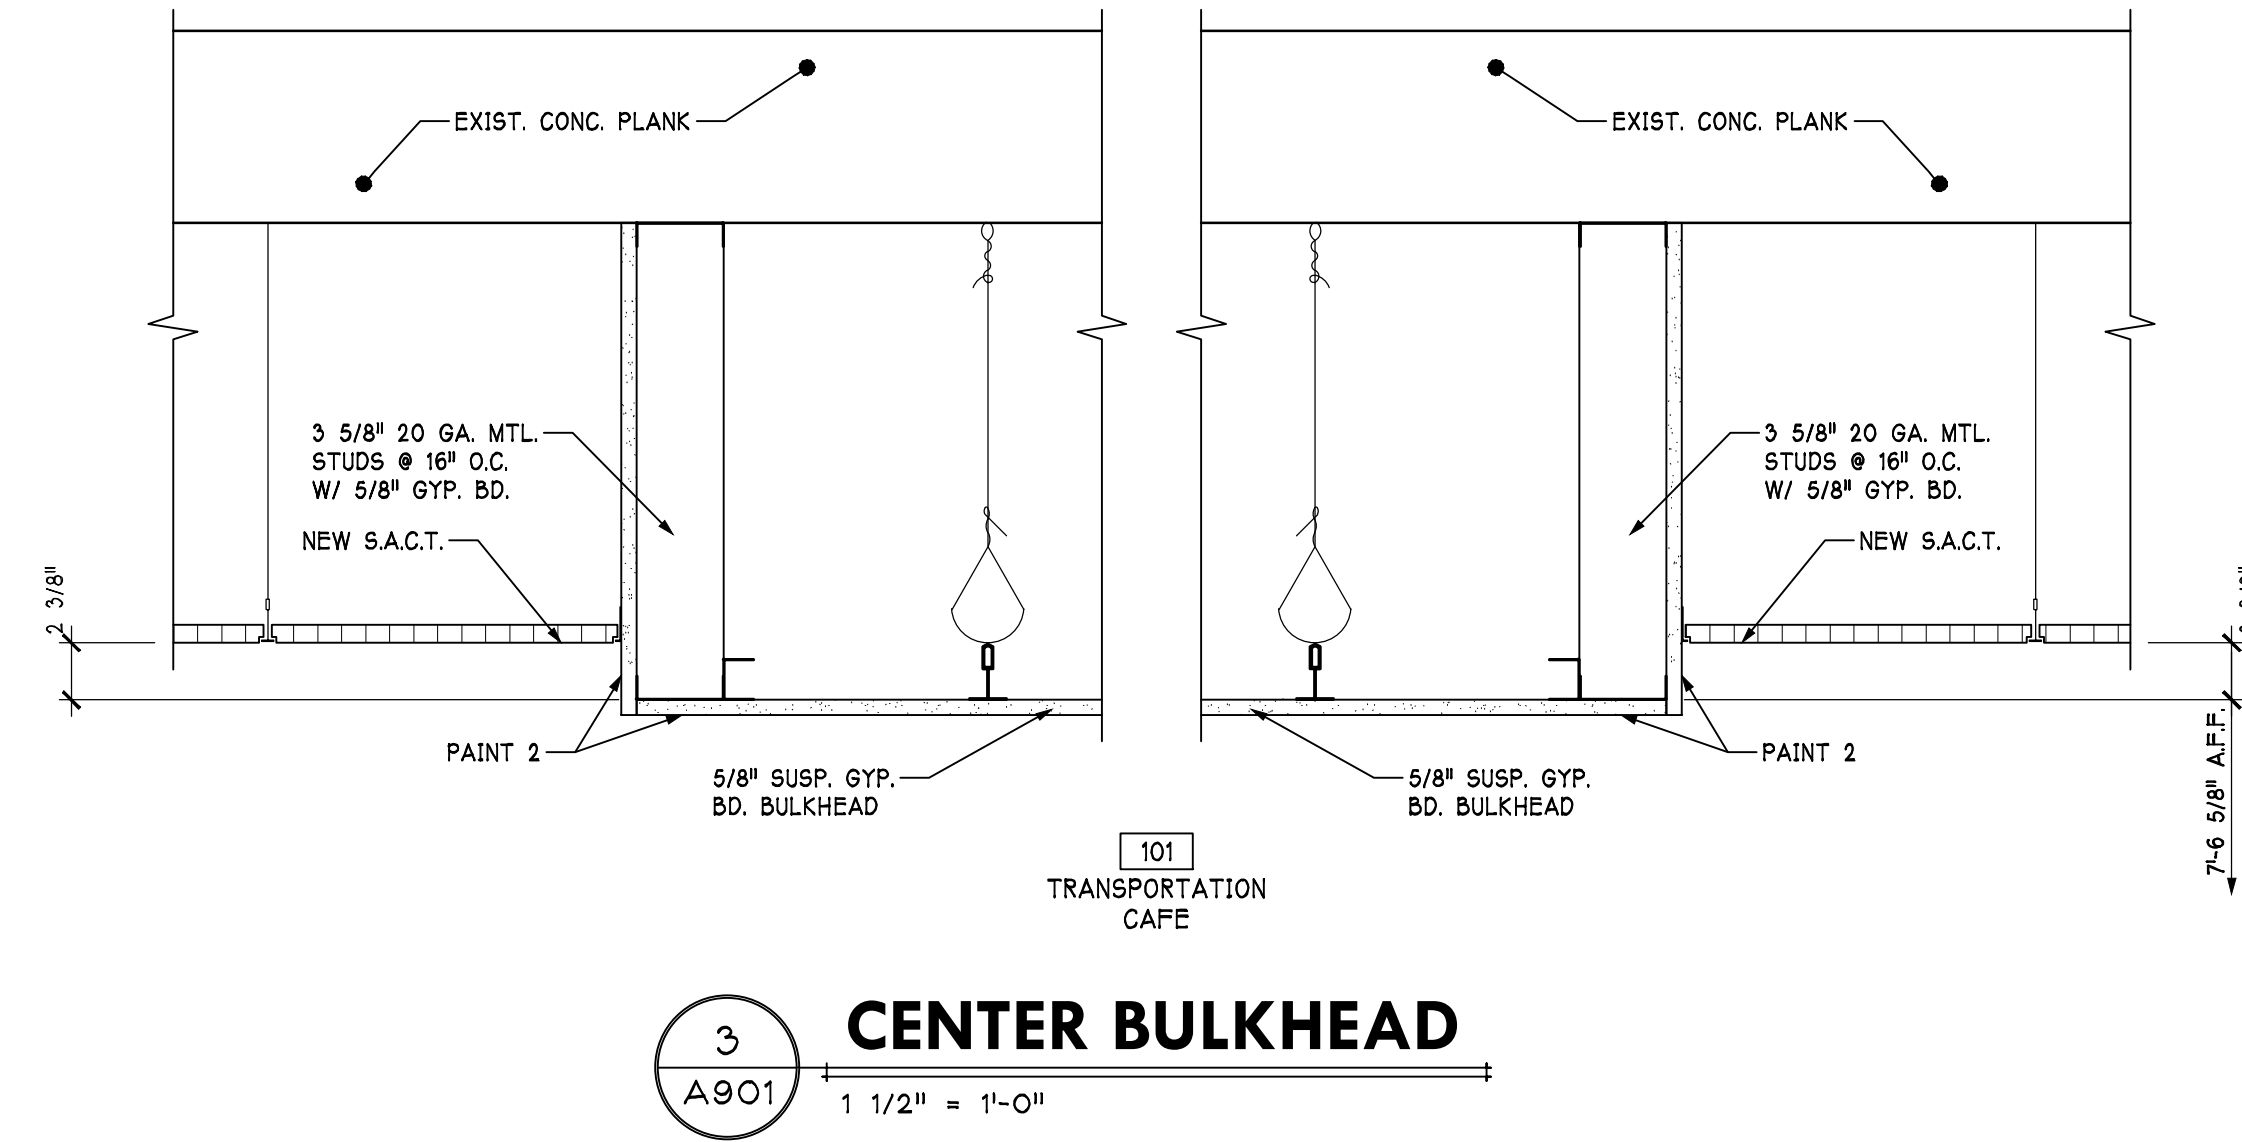


PROGRESS PRINT NOT FOR CONSTRUCTION (09/20/18)

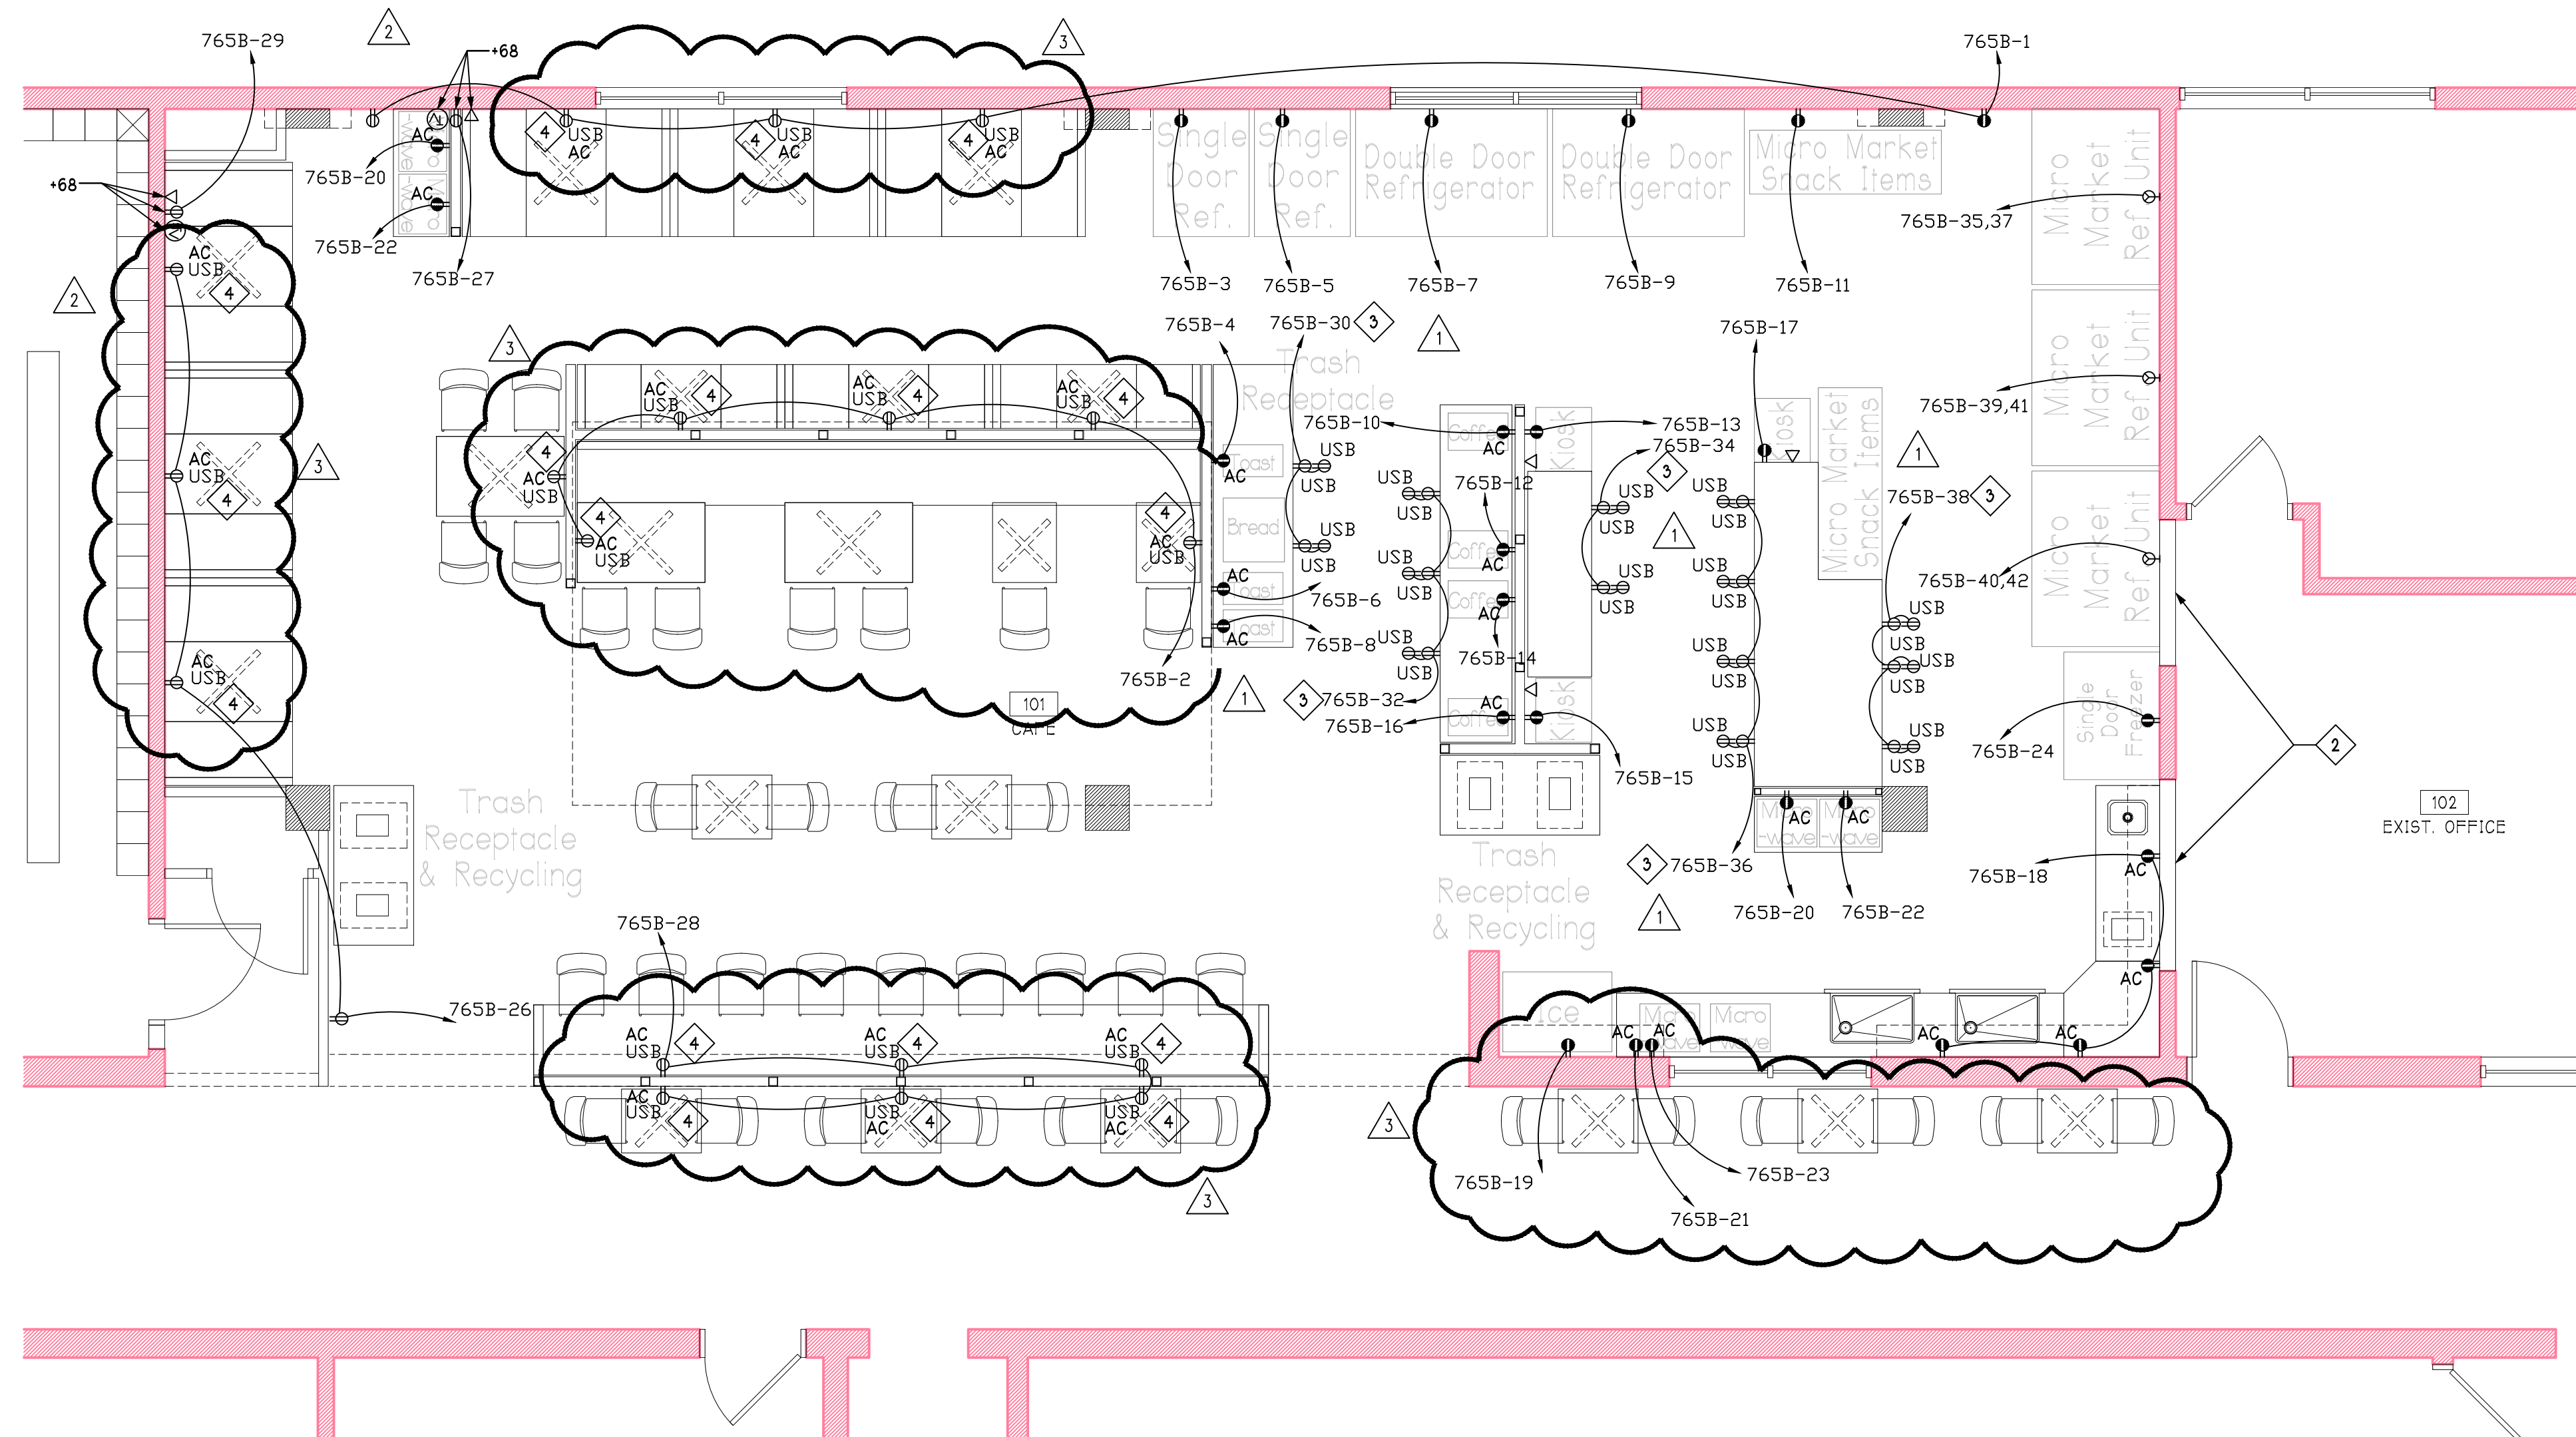

POWER RENOVATION PLAN

1/4" = 1'-0"

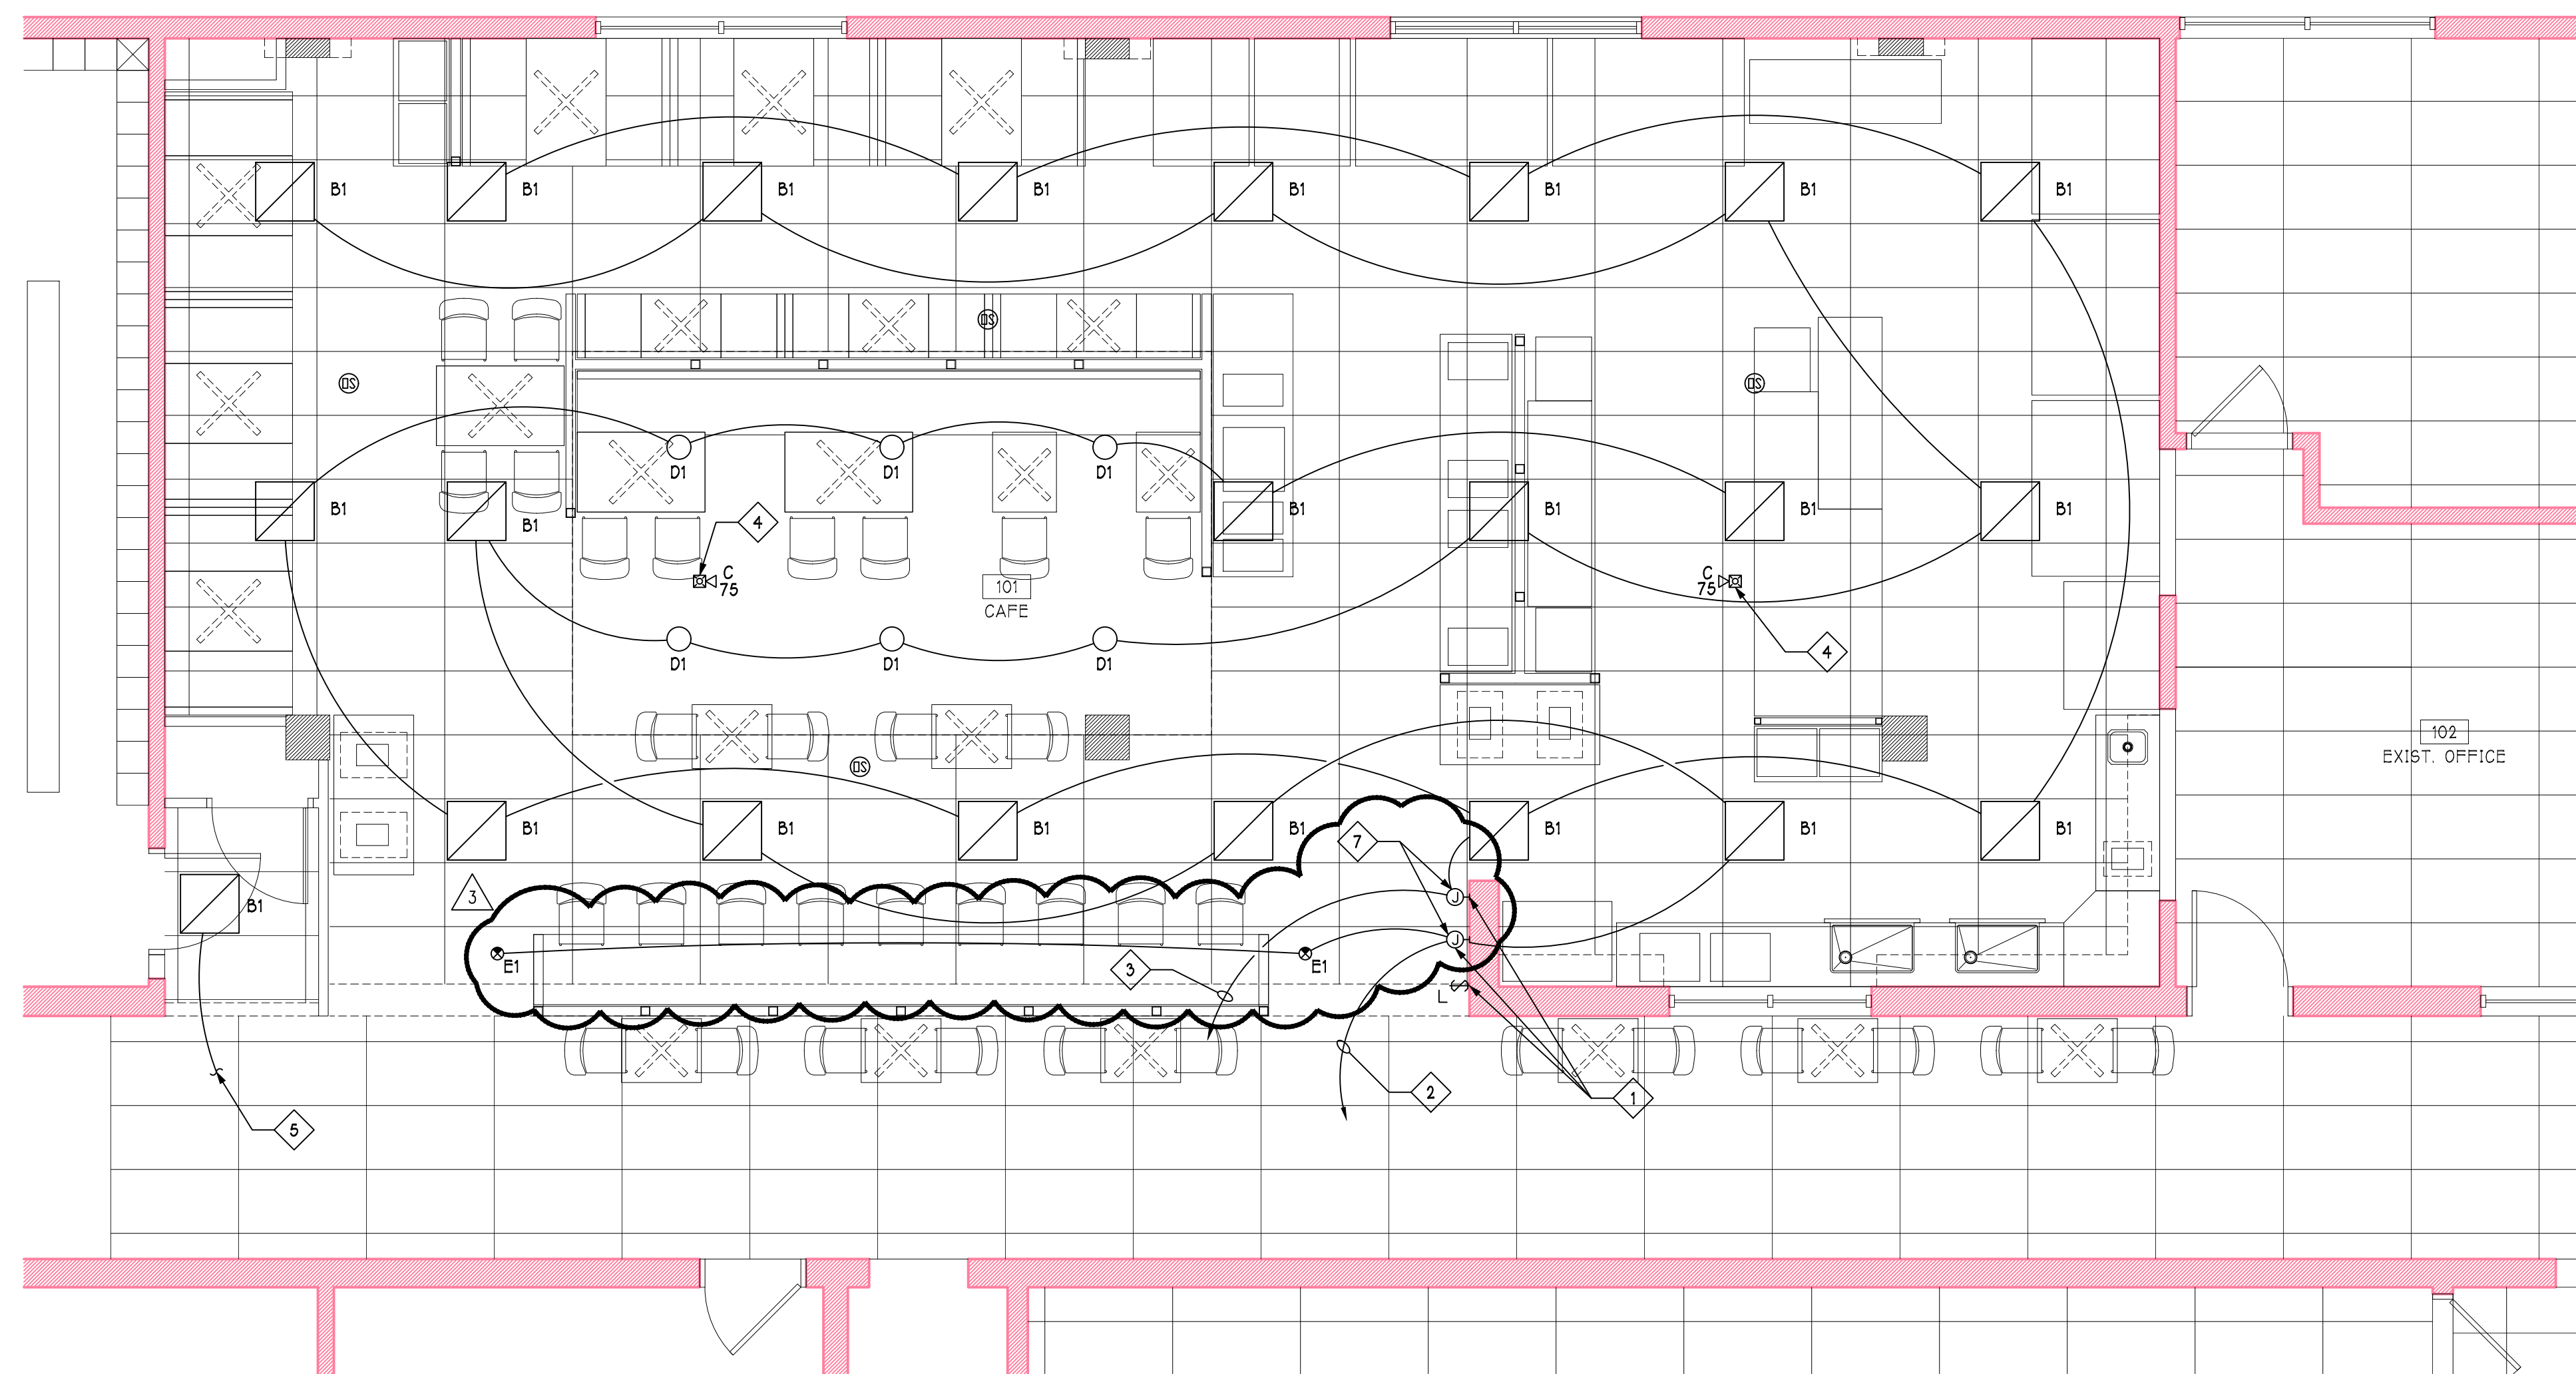

LIGHTING RENOVATION PLAN

1/4" = 1'-0"

POWER KEYED NOTES	
1	CONNECT TO NEAREST AVAILABLE RECEPTACLE CIRCUIT. FIELD VERIFY EXISTING CONDITIONS PRIOR TO STARTING WORK.
2	ROUTE POWER CIRCUITS DOWN IN NEW WALL TO FLOOR BELOW CEILING SPACE. RACEWAYS TO BE RIGID ALUMINUM IN SPACE BELOW. COORDINATE INSTALLATION WITH OWNER FOR SPECIAL FOOD REQUIREMENTS. REFER TO DETAILS.
3	FOR DEVICES ON NOTED CIRCUIT REFER TO ARCHITECTURAL ELEVATION FOR DEVICE PLACEMENT.
4	INSTALL RECEPTACLE HORIZONTALLY AND COORDINATE FINAL LOCATION AND ELEVATION WITH ARCHITECTURAL ELEVATIONS.

LIGHTING KEYED NOTES	
1	REFER TO DETAILS FOR LIGHTING CONTROL WIRING DIAGRAM.
2	CONNECT TO NORMAL LIGHTING CIRCUIT SALVAGED FROM PREVIOUS DEMOLITION WORK. REFER TO DEMOLITION PLANS.
3	CONNECT TO EMERGENCY LIGHTING CIRCUIT SALVAGED FROM PREVIOUS DEMOLITION WORK. REFER TO DEMOLITION PLANS.
4	CONNECT NEW FIRE ALARM DEVICE INTO EXISTING ANNUNCIATION CIRCUIT. FIELD VERIFY EXISTING CONDITIONS AND EQUIPMENT PRIOR TO STARTING WORK.
5	CONNECT NEW LIGHT TO EXISTING CORRIDOR LIGHTING CIRCUIT. FIELD VERIFY PRIOR TO STARTING WORK.
6	CONNECT TO EXISTING LIGHTING CIRCUIT VACATED BY PREVIOUS DEMOLITION WORK. FIELD VERIFY EXISTING CONDITIONS PRIOR TO STARTING WORK. REFER TO DEMOLITION PLANS.
7	LOCATE DIMMER MODULES ABOVE CEILING.

Job No: 1730
Drawn: MAB
Checked: SCP

Revisions:	
No: 1	Date: 10/23/2018
Revised Per Addendum #1	
No: 2	Date: 02/20/19
Revisions Per Addendum #2	
No: 3	Date: 05/13/2019
Revised Per Addendum #4	
No:	Date:
No:	Date:
No:	Date:

NEWCOMER ASSOCIATES
architecture + engineering
1105 Shiller Avenue Chambersburg, PA 17201 Tel: 717 263 1001 Fax: 717 263 7380 www.newcomerassociates.com

Martin's Famous Pastry Shoppe
Transportation Cafe
Chambersburg, Pennsylvania 17202

© 2017
Newcomer Associates, Inc.
Drawing Title:
ELECTRICAL
RENOVATION
PLANS

Sheet No.
E101
Date: MM/DD/YY

PROGRESS PRINT NOT FOR CONSTRUCTION (09/20/18)

Revisions:	
No: 1	Date: 02/20/2019
Revised Per Addendum #2	
No: 2	Date: 05/13/2019
Revised Per Addendum #4	
No:	Date:
No:	Date:
No:	Date:
No:	Date:



NEWCOMER ASSOCIATES

architecture + engineering

1105 Shiller Avenue Chambersburg, PA 17201 Tel: 717 263 0001 Fax: 717 263 7380 www.newcomerassociates.com

Martin's Famous Pastry Shoppe
Transportation Cafe


Chambersburg, Pennsylvania 17202

© 2018
Newcomer Associates, Inc.

Drawing Title:
ENLARGED
MEZZANINE
POWER PLAN

Sheet No.
E102
Date: MM/DD/YY

SHEET KEYED NOTES	
1	ADD FEED THOUGHT LUGS TO EXISTING ELECTRICAL PANEL AND CONNECT TO NEW PANEL SECTION. CONNECT USING 3-3/0 AWG WITH #6 GROUND IN A 2-1/2" CONDUIT. FIELD VERIFY EXISTING EQUIPMENT AND CONDITIONS PRIOR TO STARTING WORK.
2	INSTALL NEW PANEL SECTION ADJACENT TO EXISTING PANEL. FIELD VERIFY EXISTING EQUIPMENT AND CONDITIONS PRIOR TO STARTING WORK.
3	NOT USED
4	NOT USED
5	NOT USED

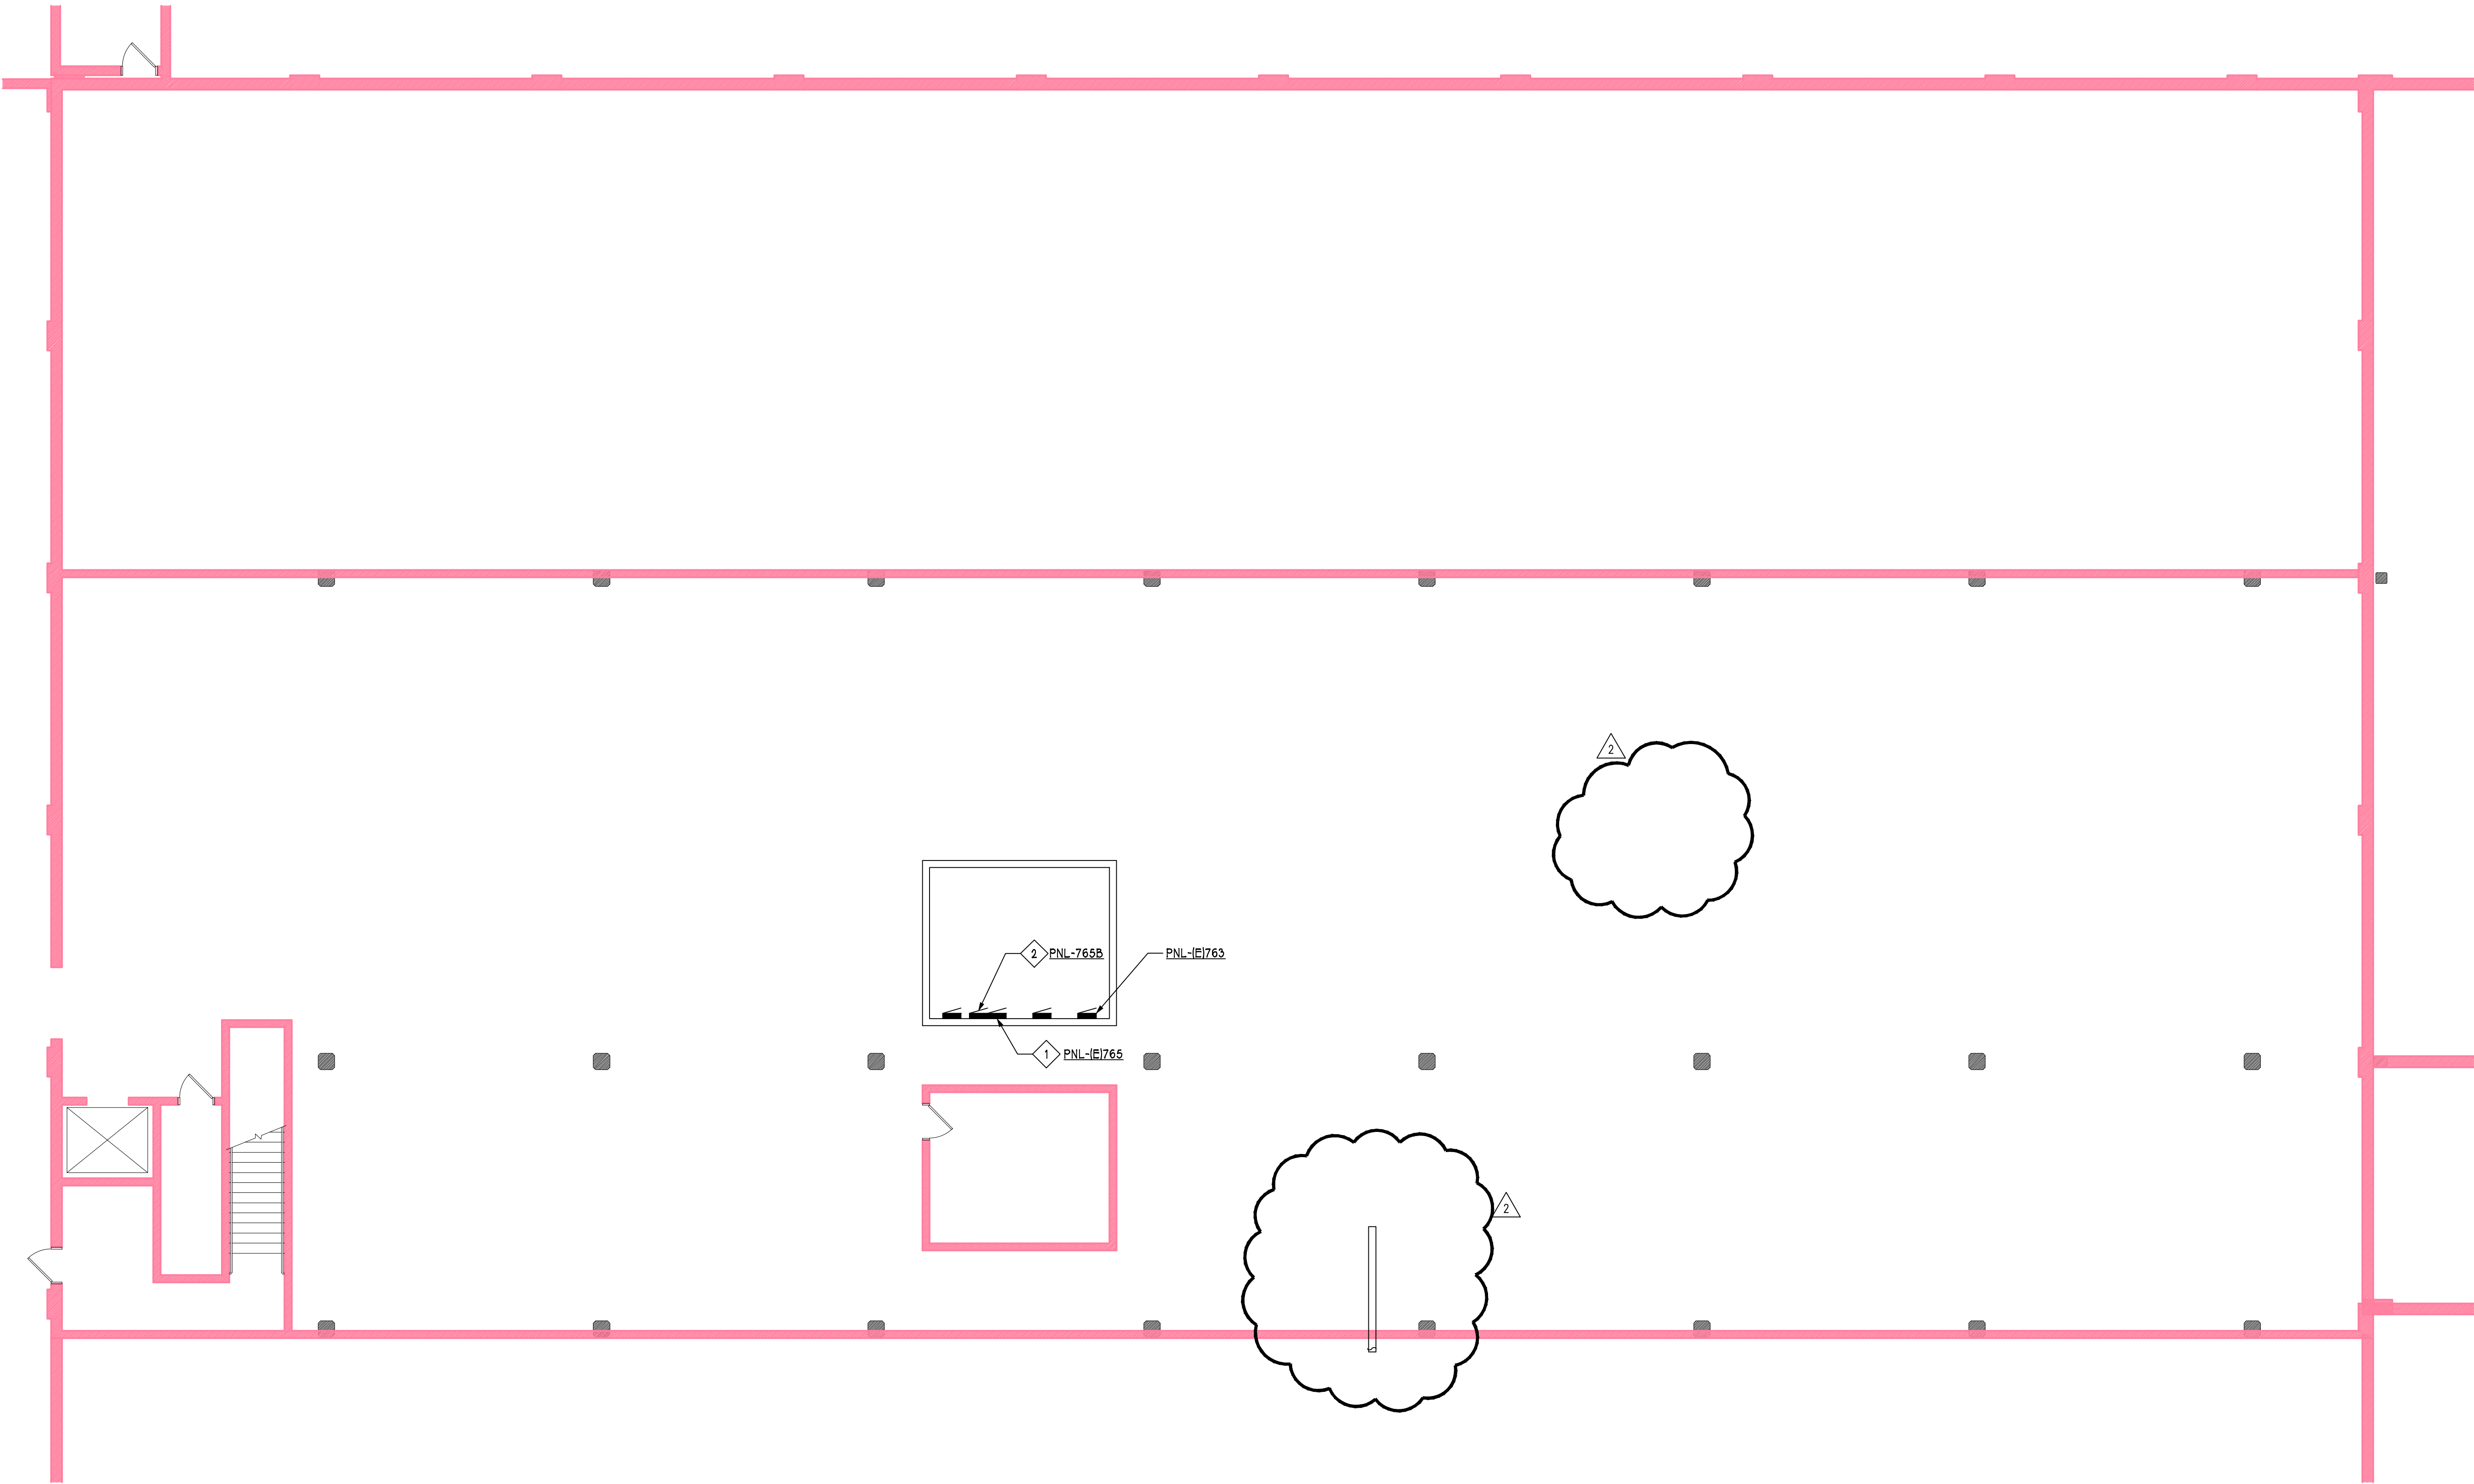


ENLARGED MEZZANINE POWER PLAN
1/8" = 1'-0"

PROGRESS PRINT NOT FOR CONSTRUCTION (09/20/18)



 A triangle with the number 1 inside.



NOT TO SCALE



NOT TO SCALE

NOT TO SCALE

NOT TO SCALE

Revisions:

No: 2	Date: 05/13/2019
-------	------------------

No:	Date:
-----	-------

No:	Date:
-----	-------

No:	Date:
-----	-------

No:	Date:
-----	-------

105 Sheller Avenue Chambersburg, PA 17201 Tel: 717 263 0101 Fax: 717 263 7380 www.newcomerassociates.com

Chambersburg, Pennsylvania 17202

Drawing Title:
LUMINAIRE
SCHEDULE AND
DETAILS

Date: MM/DD/YY

E501

Date: MM/DD/YY

PROGRESS PRINT NOT FOR CONSTRUCTION (09/20/18)